

Tally Associates
Landscape Architecture
Planning
Urban Design
1925 San Joaquin, Suite 400
Dallas, Texas 75201
Tel. 214-871-7500
Fax. 214-871-7985




Project	NB034
Drawn By	ByW
Checked By	KB
Date	SEPTEMBER 5, 2008
Issued:	
Issued:	
Issued:	
Revisions:	
▲	
▲	
▲	

Sheet Title:
EP SITE PLAN

MEP SYSTEMS DESIGN
AND ENGINEERING INC.
918 DRAGON STREET
DALLAS, TX 75207
(214)915-0929

EP1.01

Sheet No.:

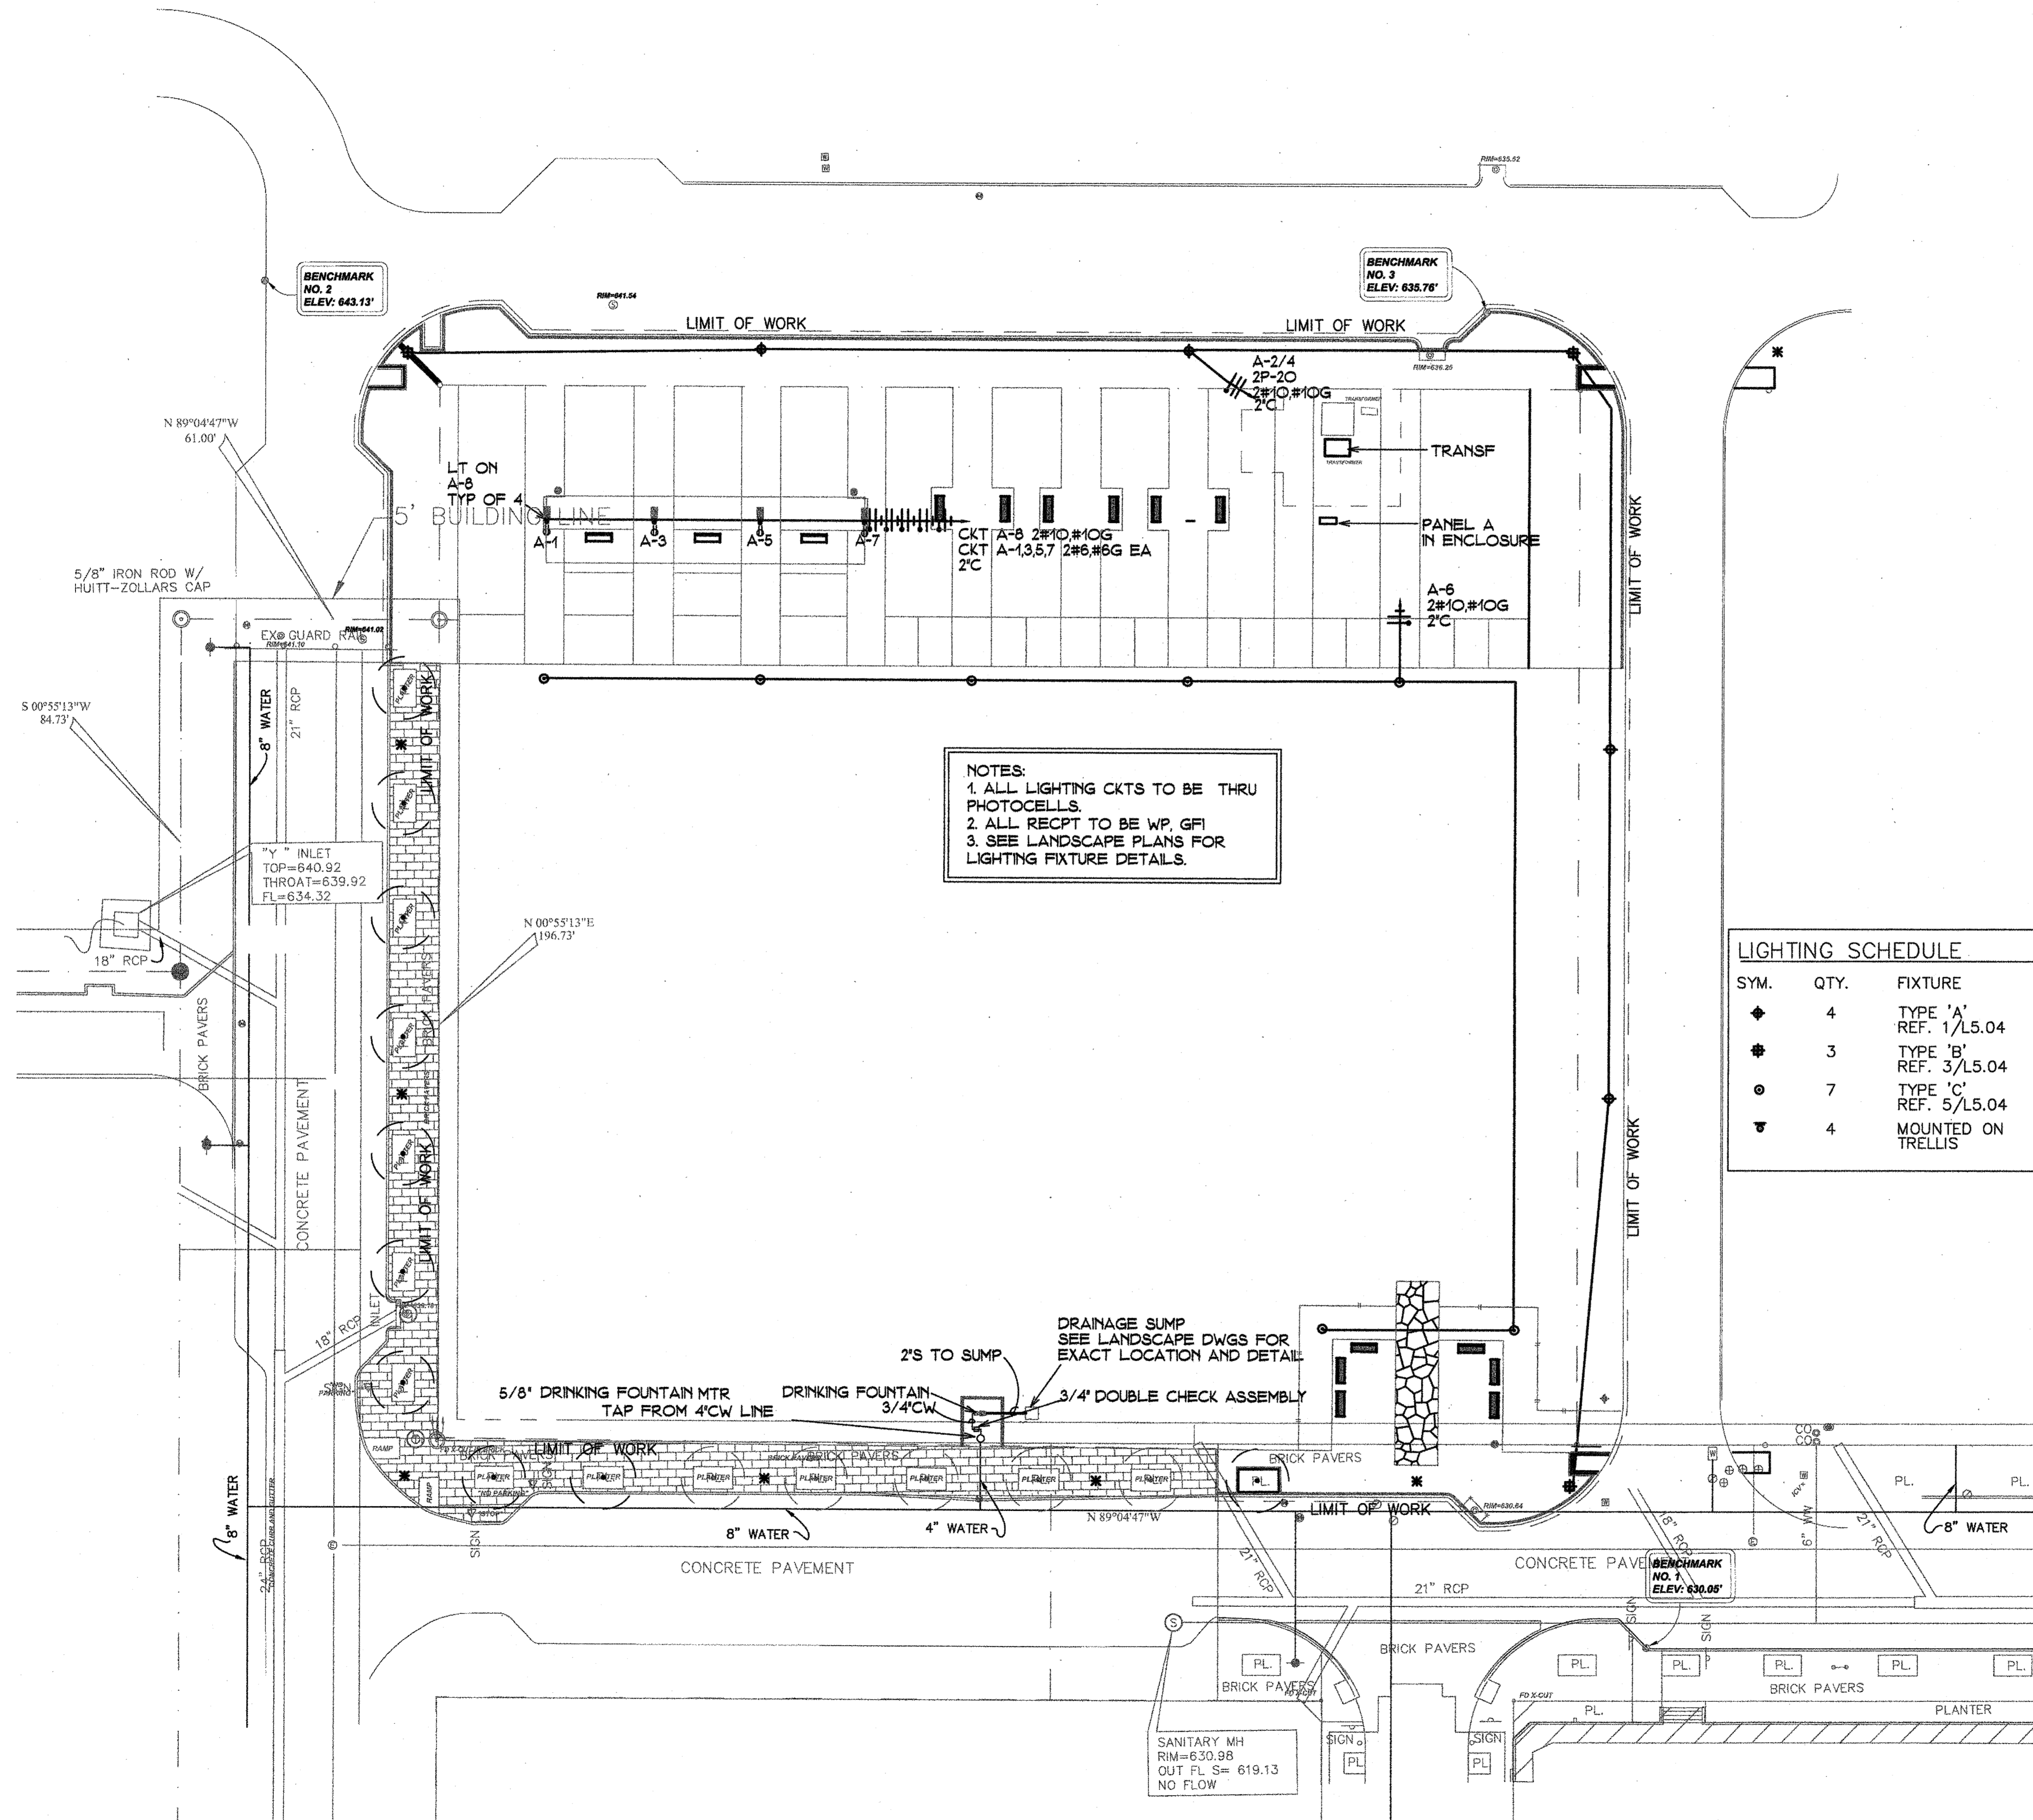

NOTES:
1. ALL LIGHTING CKTS TO BE THRU PHOTOCELLS.
2. ALL RECP TO BE WP GFI
3. SEE LANDSCAPE PLANS FOR LIGHTING FIXTURE DETAILS.

LIGHTING SCHEDULE

SYM.	QTY.	FIXTURE	MANUFACTURER
◆	4	TYPE 'A' REF. 1/L5.04	BEGA 9801MH-MOD-175MH-240V-BLACK BEGA 1508HR-BLACK
◆	3	TYPE 'B' REF. 3/L5.04	BEGA 9802MH-MOD-175MH-240V-BLACK BEGA 1508HR-BLACK
○	7	TYPE 'C' REF. 5/L5.04	POULSEN-KAT-1/150CMHTG-120-277-COP DRA-5-3-12-BLACK
▼	4	MOUNTED ON TRELLIS	BEGA 7511 FLOODLIGHT

