



**VIEW "A-A"**  
NOT TO SCALE

NOTE:  
PROVIDE BITUMINOUS EXPANSION MATERIAL  
WHERE PILOT CHANNEL ABUTS PROPOSED STRUCTURE

**Pilot Channel**  
NOT TO SCALE

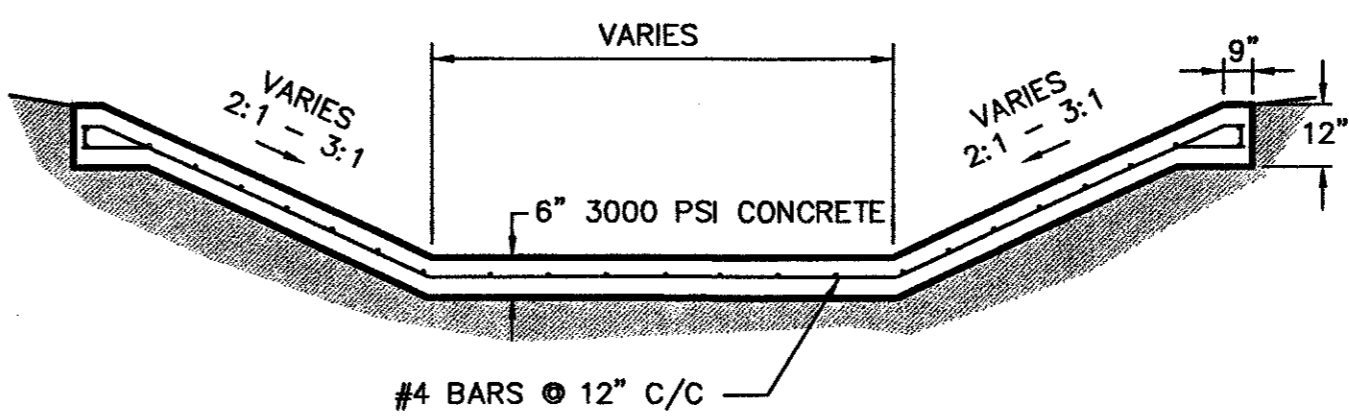



**Channel Lining Section "B-B"**  
NOT TO SCALE

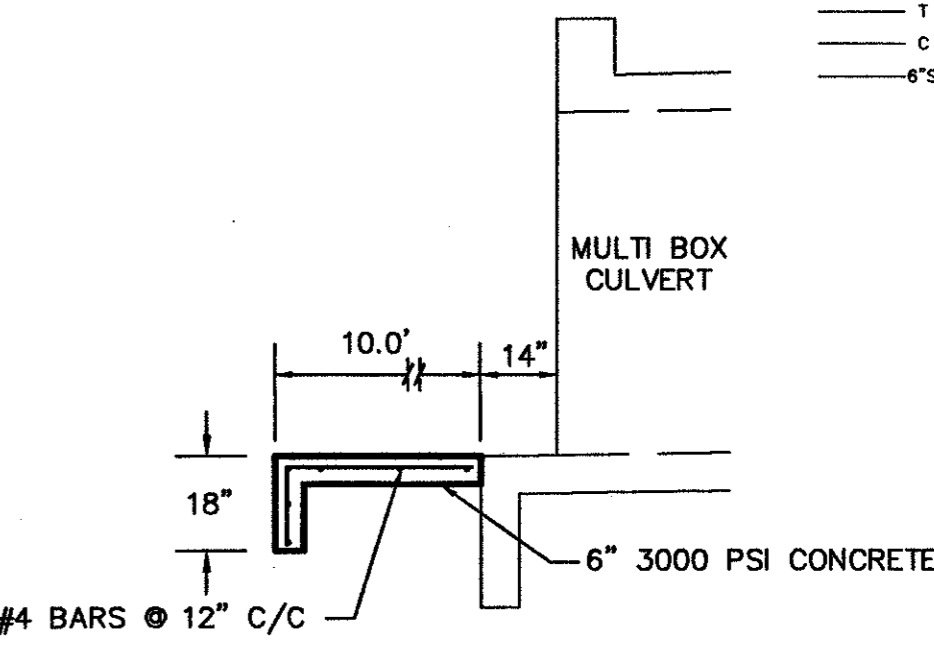

**Channel Lining Section "C-C"**  
NOT TO SCALE

**LEGEND**

B	BOLLARD
EM	ELECTRIC METER
PP	POWER POLE
LS	LIGHT STANDARD
WM	WATER METER
WV	WATER VALVE
ICV	IRRIGATION CONTROL VALVE
FH	FIRE HYDRANT
CO	CLEANOUT
MH	MANHOLE
TSC	TRAFFIC SIGNAL CONTROL
TSP	TRAFFIC SIGNAL POLE
TELE	TELEPHONE BOX
FL	FLOOD LIGHT
FP	FLAG POLE
SIGN	TRAFFIC SIGN
IRS	1/2-INCH IRON ROD
W/P	W/PACHECO KOCH CAP SET
(C.M.)	CONTROLLING MONUMENT
---	PROPERTY LINE
-X-	FENCE
OHL	OVERHEAD UTILITY LINE
UWL	UNDERGROUND WATER LINE
E	UNDERGROUND ELECTRIC LINE
T	UNDERGROUND TELEPHONE LINE
C	UNDERGROUND CABLE LINE
S	UNDERGROUND SANITARY SEWER LINE

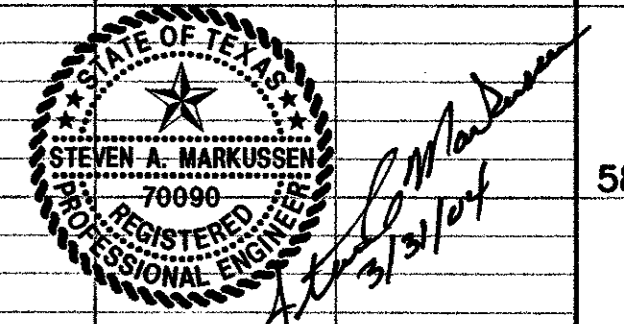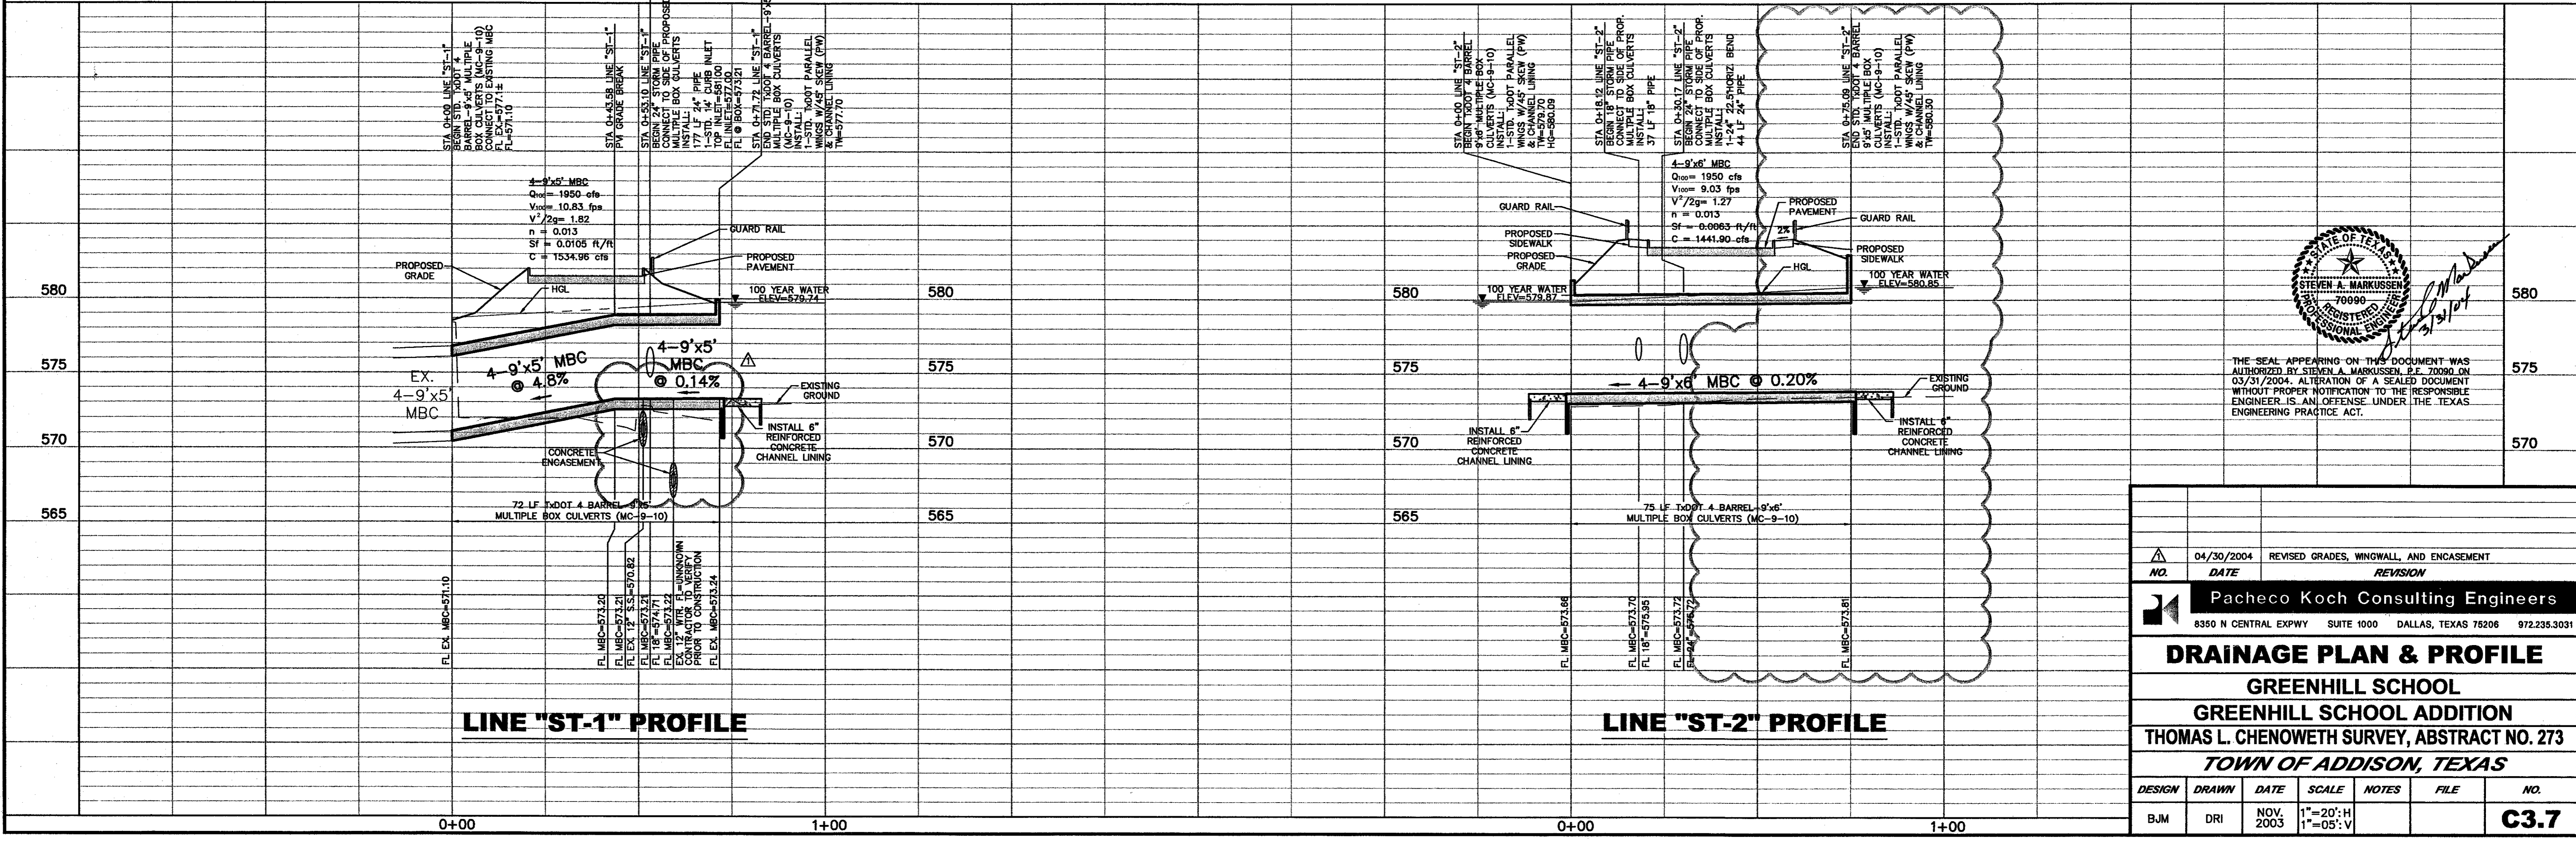

NO.		04/30/2004	REVISED GRADES, WINGWALL, AND ENCASEMENT	
DATE			REVISION	
<b>Pacheco Koch Consulting Engineers</b>				
8350 N CENTRAL EXPWY SUITE 1000 DALLAS, TEXAS 75206 972.235.3031				
<b>DRAINAGE PLAN &amp; PROFILE</b>				
<b>GREENHILL SCHOOL</b>				
<b>GREENHILL SCHOOL ADDITION</b>				
<b>THOMAS L. CHENOWETH SURVEY, ABSTRACT NO. 273</b>				
<b>TOWN OF ADDISON, TEXAS</b>				
DESIGN	DRAWN	DATE	SCALE	NOTES
BJM	DRI	NOV. 2003	1"=20'-H 1"=05'-V	
				<b>NO.</b>
				<b>C3.7</b>

DWG FILE: 1082-03.024CVDWG  
 XREF FILE: FS.DWG  
 PK FILE: 2102-99.350  
 04/29/2004 - 5:30PM  
 M: DWG-10 1082-03-024CVDWG 1082-03.024CVDWG

GREENHILL SCHOOL