

**GREENHILL  
UPPER  
SCHOOL**

**HIDELL**

ARCHITECTS

2811 MCKINNEY AVENUE, SUITE 207  
DALLAS, TEXAS 75204 (214) 855-0336

David Whetzer 7-1-87

PSA ENGINEERING  
CIVIL ENGINEERS  
12747 MONTFORT DR.  
DALLAS, TEXAS 75240 214 960-1127

**Revisions**

ADDED SD SIZES & NOTES; N/C NOTE 7-10-87  
REVISED FOR FINAL DESIGN & CITY 7-20-87

**Job No. 87005**


Issue Date: 7-1-87

Drawn By: PSA

Checked By:

Sheet No. C-2

of:

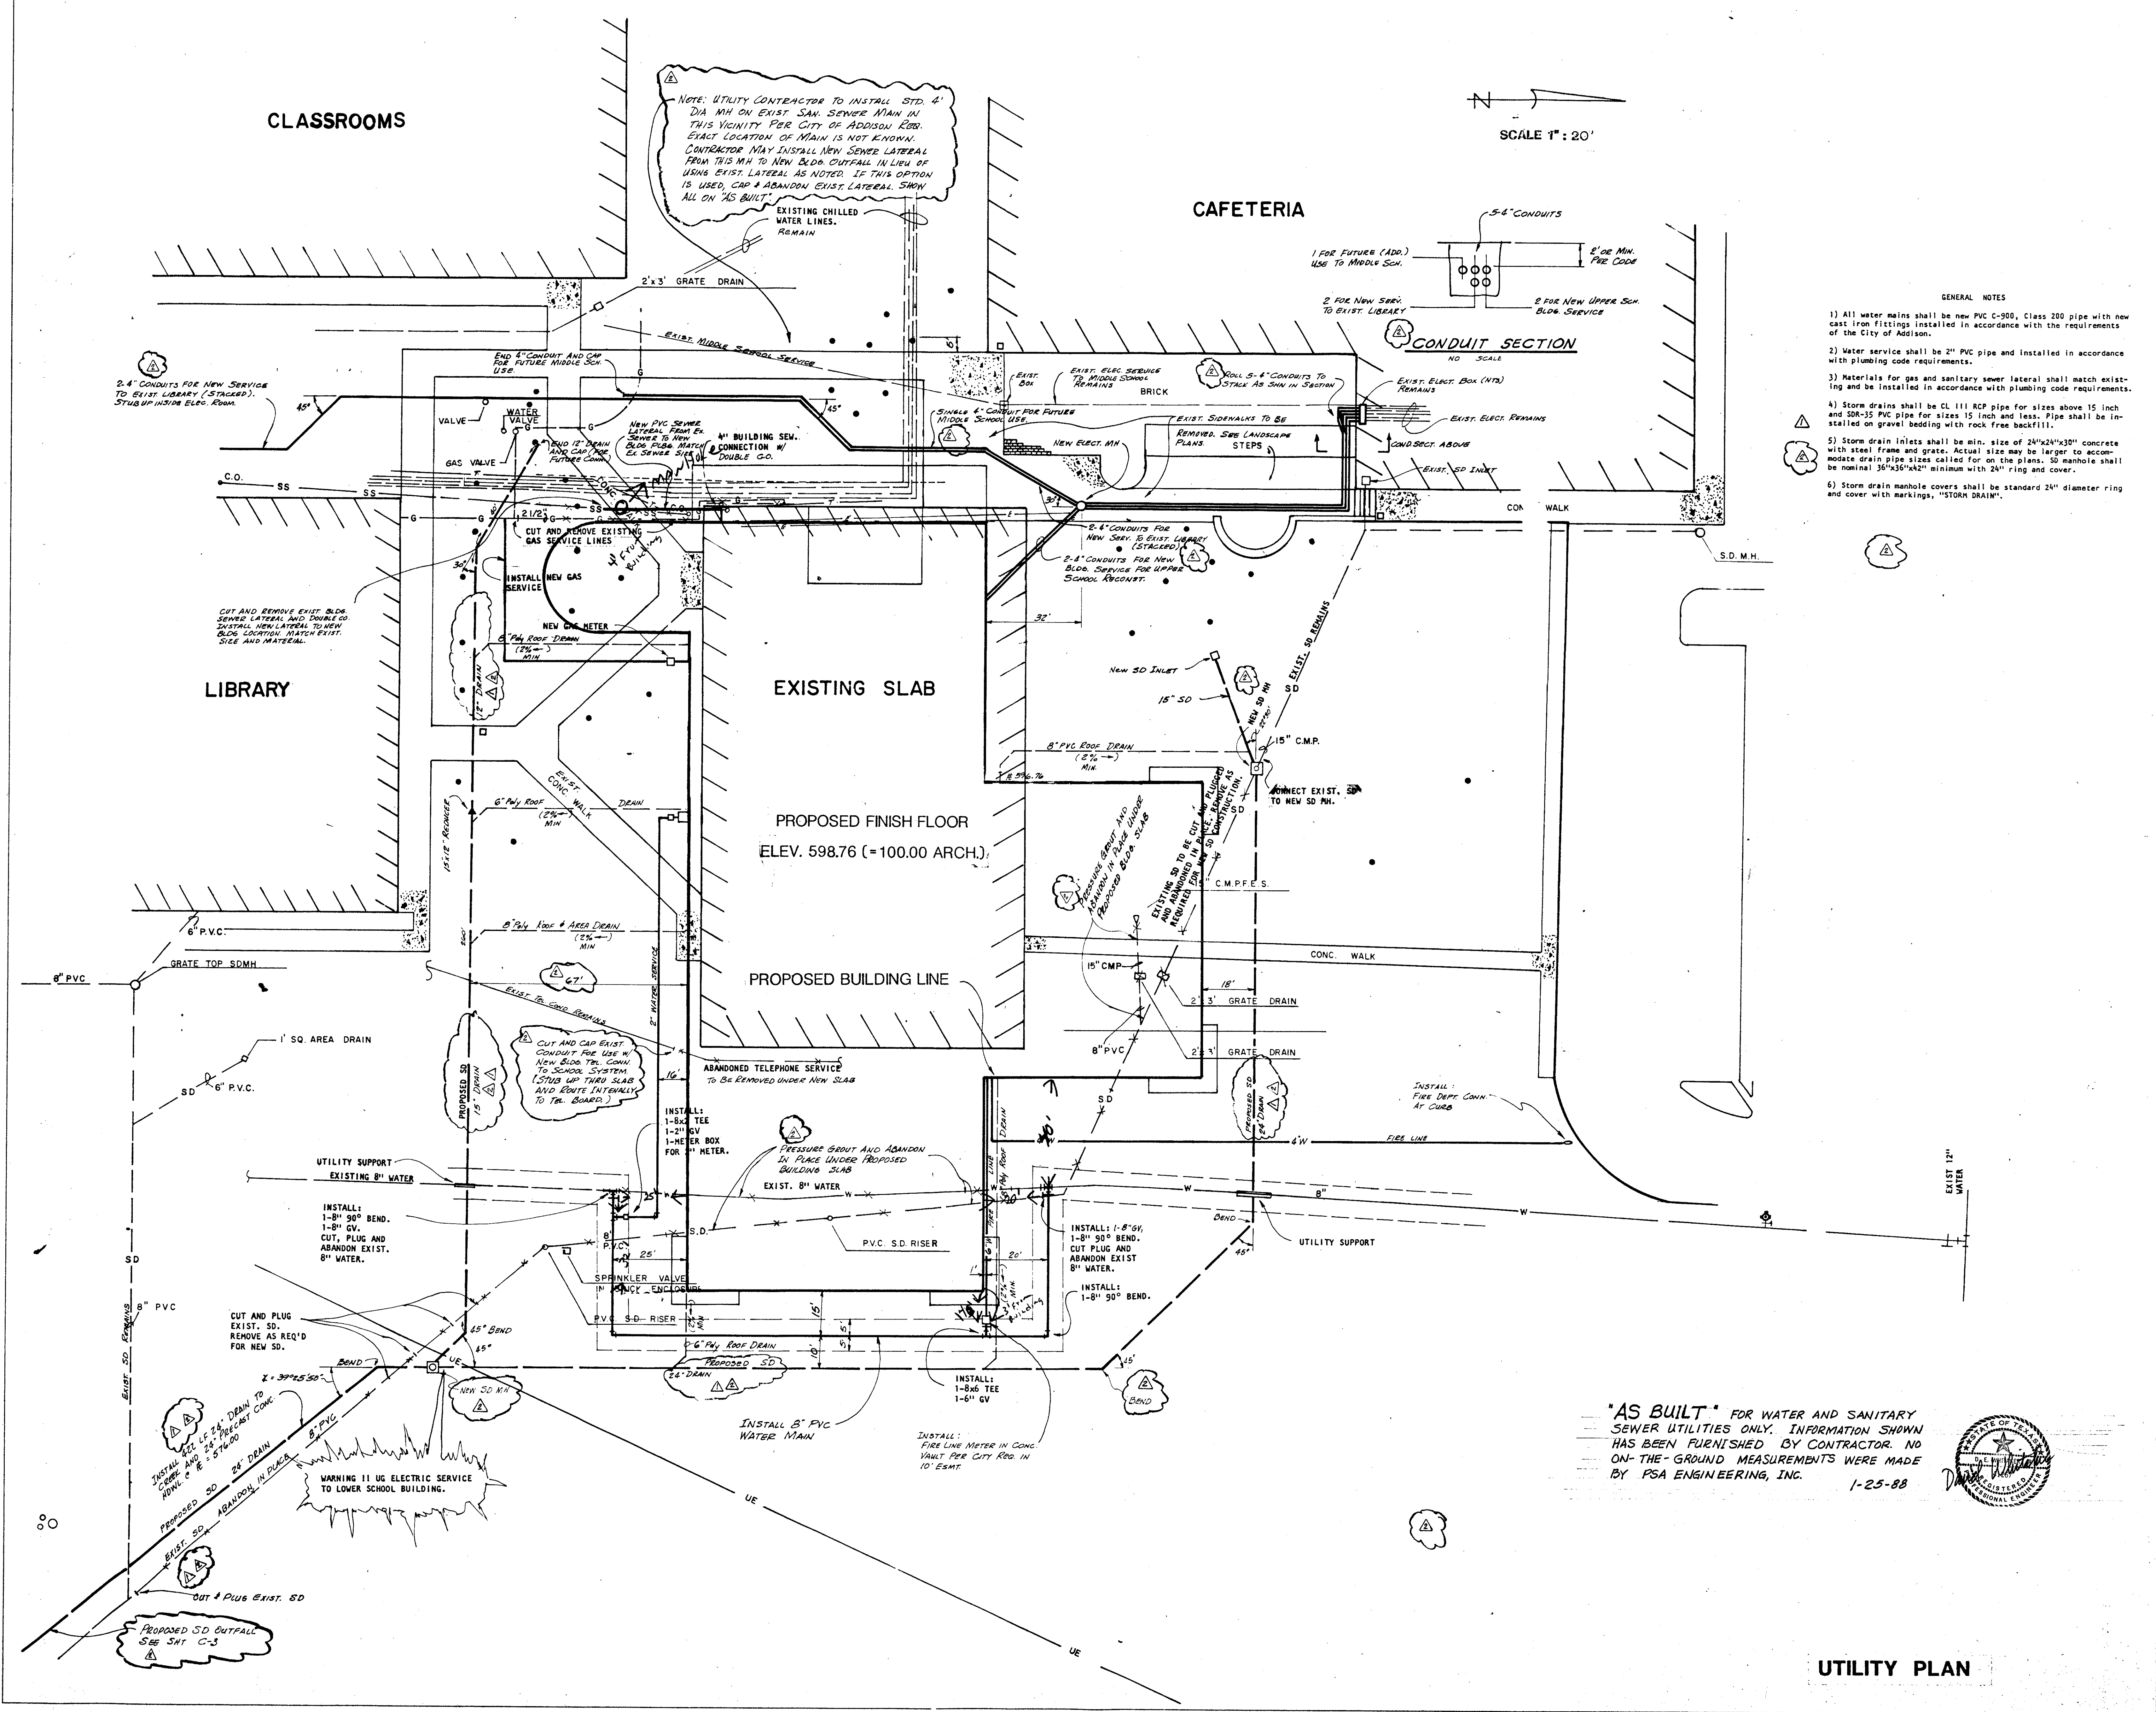

**UTILITY PLAN**

"AS BUILT" FOR WATER AND SANITARY SEWER UTILITIES ONLY. INFORMATION SHOWN HAS BEEN FURNISHED BY CONTRACTOR. NO ON-THE-GROUND MEASUREMENTS WERE MADE BY PSA ENGINEERING, INC. 1-25-88

