
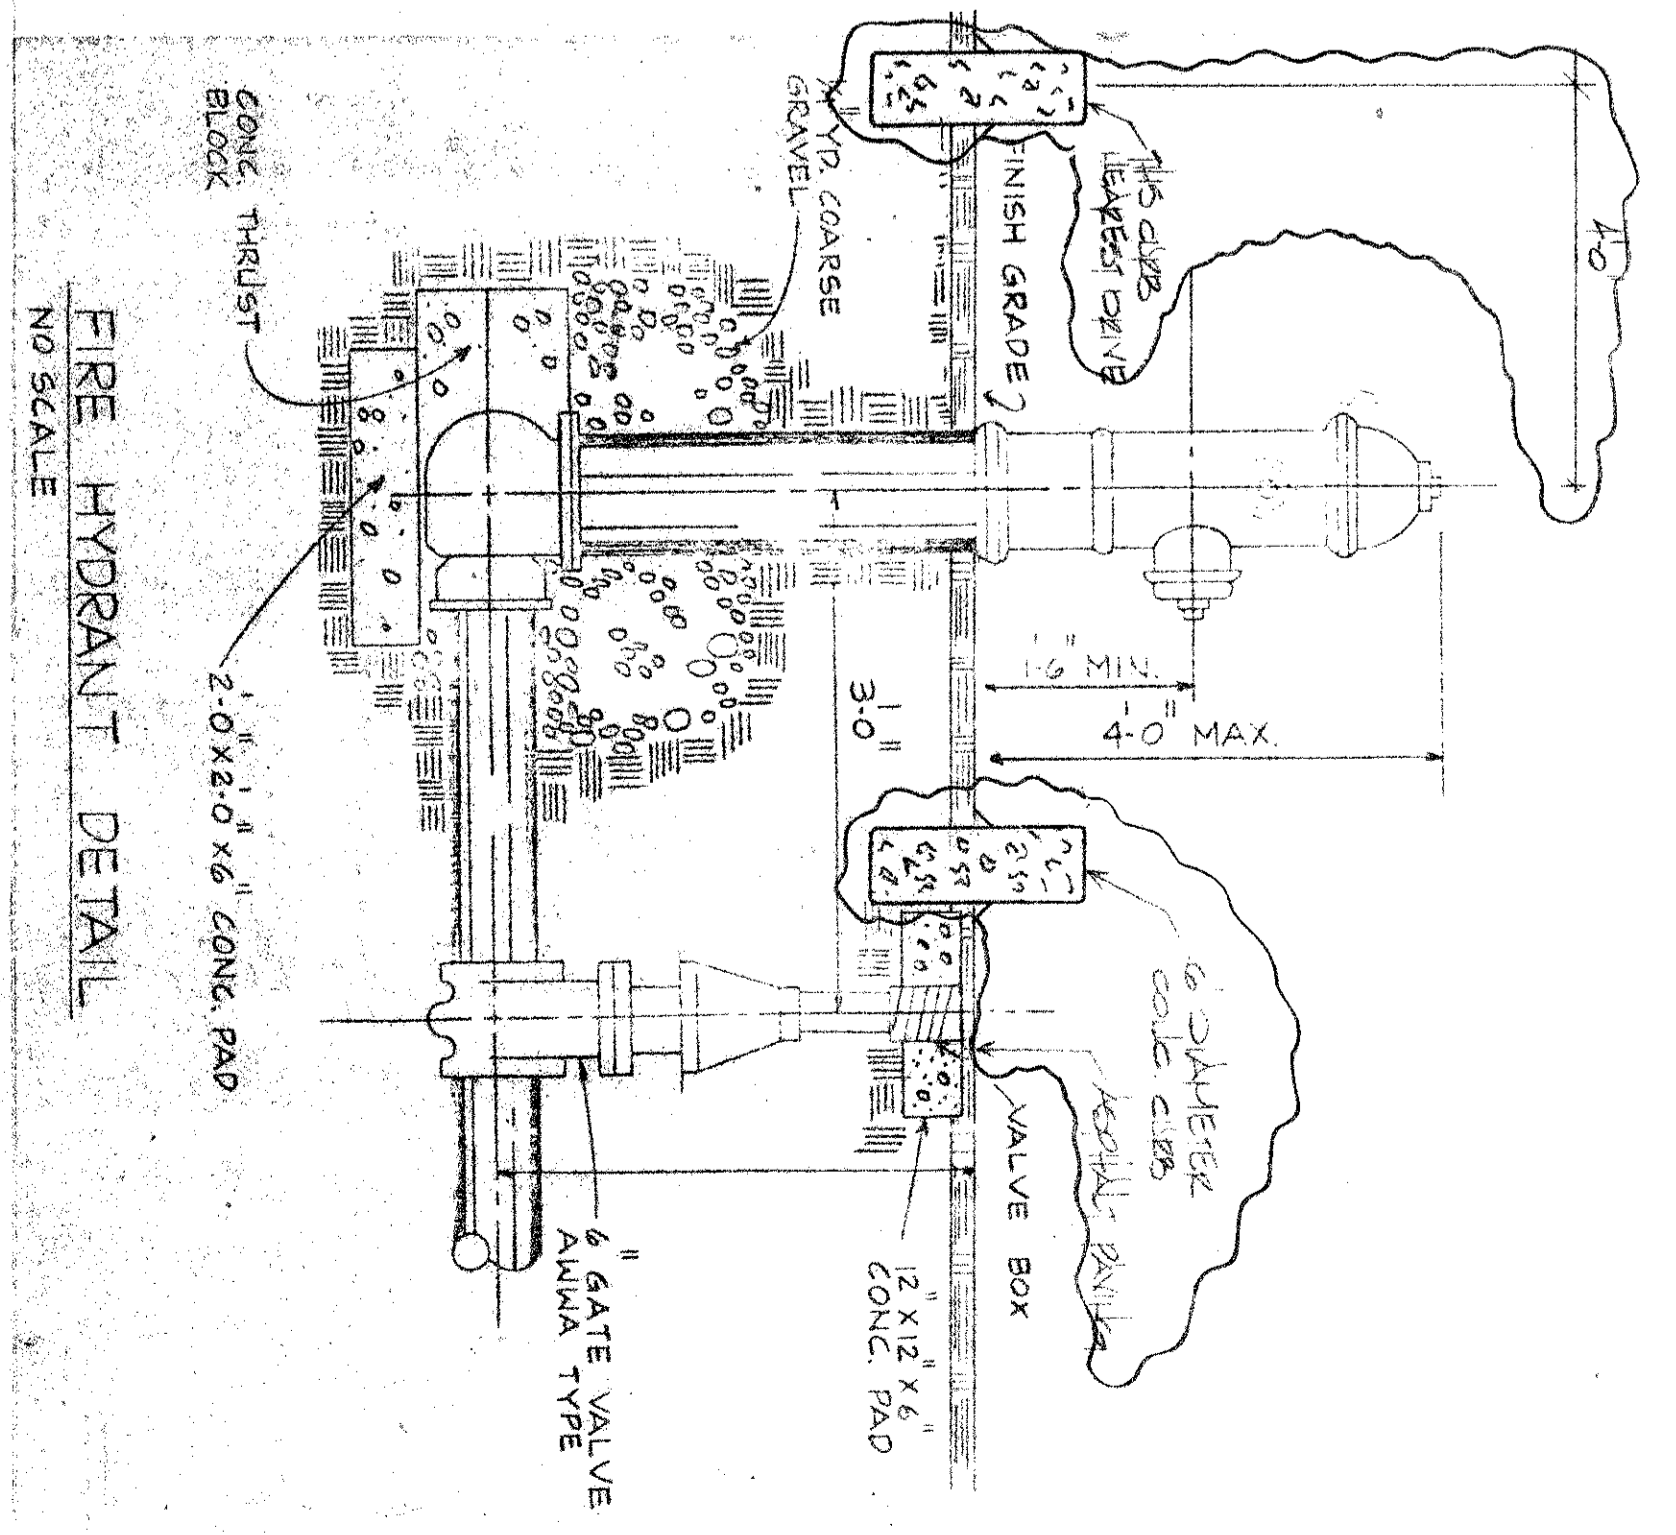
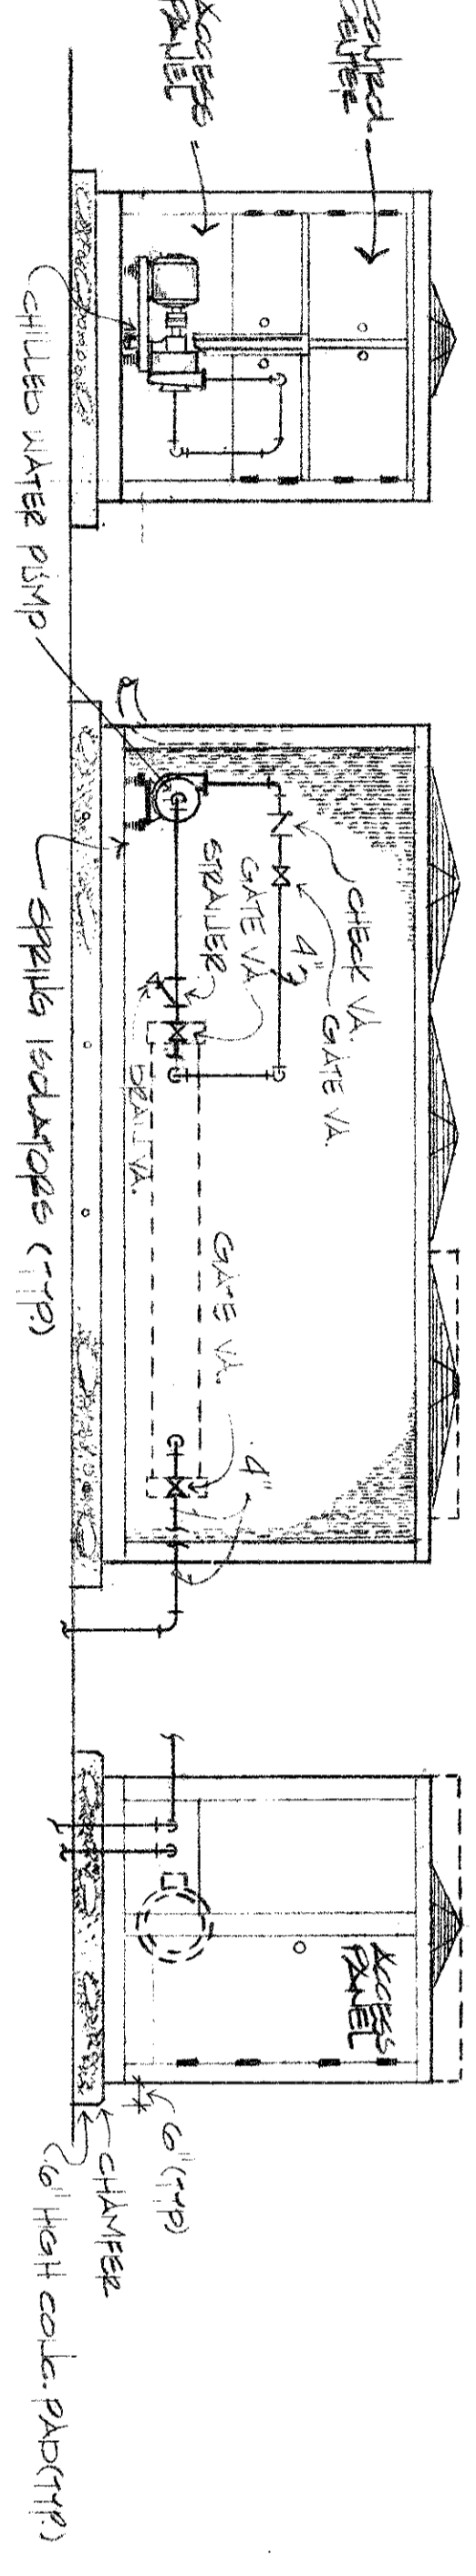


LIGHT FIXTURE SCHEDULE	
AA	STANDARD 4'x4' 2" 48-48-1/2 120-0/3500-4-2-4, BLACK FINISH WITH ALUMINUM LENS
BB	4'x4' 2" 48-48-1/2 120-0/3500-4-2-4, BLACK FINISH WITH ALUMINUM LENS
CC	STANDARD 4'x4' 2" 48-48-1/2 120-0/3500-4-2-4, BLACK FINISH WITH ALUMINUM LENS
DD	STANDARD 4'x4' 2" 48-48-1/2 120-0/3500-4-2-4, BLACK FINISH WITH ALUMINUM LENS
EE	STANDARD 4'x4' 2" 48-48-1/2 120-0/3500-4-2-4, BLACK FINISH WITH ALUMINUM LENS
FF	STANDARD 4'x4' 2" 48-48-1/2 120-0/3500-4-2-4, BLACK FINISH WITH ALUMINUM LENS

- NOTES BY SYMBOL
1. GRID COUNTS OUT AT PROPERTY LINE TO TELEPHONE CO REQUIREMENTS.
 2. UNDERGROUND PRIMARY BY ELECTRIC UTILITY COMPANY, VERIFY EXACT LOCATION.
 3. 2-1/2" PVC FOR TELEPHONE COMPANY.
 4. 0-3/8" CONDUIT, EACH WITH 3500 MCM AND 1-1/2" NEUTRAL.
 5. PAD MOUNTED TRANSFORMER BY ELECTRIC UTILITY CO.
 6. ALL 1/2" HDPE BY ELECTRICAL CODE. ALL 3/4" HDPE BY ELECTRICAL CODE. ALL 1" HDPE BY ELECTRICAL CODE. ALL 1-1/2" HDPE BY ELECTRICAL CODE. ALL 2" HDPE BY ELECTRICAL CODE. ALL 3" HDPE BY ELECTRICAL CODE. ALL 4" HDPE BY ELECTRICAL CODE. ALL 6" HDPE BY ELECTRICAL CODE. ALL 8" HDPE BY ELECTRICAL CODE. ALL 12" HDPE BY ELECTRICAL CODE. ALL 18" HDPE BY ELECTRICAL CODE. ALL 24" HDPE BY ELECTRICAL CODE. ALL 30" HDPE BY ELECTRICAL CODE. ALL 36" HDPE BY ELECTRICAL CODE. ALL 42" HDPE BY ELECTRICAL CODE. ALL 48" HDPE BY ELECTRICAL CODE. ALL 54" HDPE BY ELECTRICAL CODE. ALL 60" HDPE BY ELECTRICAL CODE. ALL 66" HDPE BY ELECTRICAL CODE. ALL 72" HDPE BY ELECTRICAL CODE. ALL 78" HDPE BY ELECTRICAL CODE. ALL 84" HDPE BY ELECTRICAL CODE. ALL 90" HDPE BY ELECTRICAL CODE. ALL 96" HDPE BY ELECTRICAL CODE. ALL 102" HDPE BY ELECTRICAL CODE. ALL 108" HDPE BY ELECTRICAL CODE. ALL 114" HDPE BY ELECTRICAL CODE. ALL 120" HDPE BY ELECTRICAL CODE. ALL 126" HDPE BY ELECTRICAL CODE. ALL 132" HDPE BY ELECTRICAL CODE. ALL 138" HDPE BY ELECTRICAL CODE. ALL 144" HDPE BY ELECTRICAL CODE. ALL 150" HDPE BY ELECTRICAL CODE. ALL 156" HDPE BY ELECTRICAL CODE. ALL 162" HDPE BY ELECTRICAL CODE. ALL 168" HDPE BY ELECTRICAL CODE. ALL 174" HDPE BY ELECTRICAL CODE. ALL 180" HDPE BY ELECTRICAL CODE. ALL 186" HDPE BY ELECTRICAL CODE. ALL 192" HDPE BY ELECTRICAL CODE. ALL 198" HDPE BY ELECTRICAL CODE. ALL 204" HDPE BY ELECTRICAL CODE. ALL 210" HDPE BY ELECTRICAL CODE. ALL 216" HDPE BY ELECTRICAL CODE. ALL 222" HDPE BY ELECTRICAL CODE. ALL 228" HDPE BY ELECTRICAL CODE. ALL 234" HDPE BY ELECTRICAL CODE. ALL 240" HDPE BY ELECTRICAL CODE. ALL 246" HDPE BY ELECTRICAL CODE. ALL 252" HDPE BY ELECTRICAL CODE. ALL 258" HDPE BY ELECTRICAL CODE. ALL 264" HDPE BY ELECTRICAL CODE. ALL 270" HDPE BY ELECTRICAL CODE. ALL 276" HDPE BY ELECTRICAL CODE. ALL 282" HDPE BY ELECTRICAL CODE. ALL 288" HDPE BY ELECTRICAL CODE. ALL 294" HDPE BY ELECTRICAL CODE. ALL 300" HDPE BY ELECTRICAL CODE.
 7. ALL 1/2" HDPE BY ELECTRICAL CODE. ALL 3/4" HDPE BY ELECTRICAL CODE. ALL 1" HDPE BY ELECTRICAL CODE. ALL 1-1/2" HDPE BY ELECTRICAL CODE. ALL 2" HDPE BY ELECTRICAL CODE. ALL 3" HDPE BY ELECTRICAL CODE. ALL 4" HDPE BY ELECTRICAL CODE. ALL 6" HDPE BY ELECTRICAL CODE. ALL 8" HDPE BY ELECTRICAL CODE. ALL 12" HDPE BY ELECTRICAL CODE. ALL 18" HDPE BY ELECTRICAL CODE. ALL 24" HDPE BY ELECTRICAL CODE. ALL 30" HDPE BY ELECTRICAL CODE. ALL 36" HDPE BY ELECTRICAL CODE. ALL 42" HDPE BY ELECTRICAL CODE. ALL 48" HDPE BY ELECTRICAL CODE. ALL 54" HDPE BY ELECTRICAL CODE. ALL 60" HDPE BY ELECTRICAL CODE. ALL 66" HDPE BY ELECTRICAL CODE. ALL 72" HDPE BY ELECTRICAL CODE. ALL 78" HDPE BY ELECTRICAL CODE. ALL 84" HDPE BY ELECTRICAL CODE. ALL 90" HDPE BY ELECTRICAL CODE. ALL 96" HDPE BY ELECTRICAL CODE. ALL 102" HDPE BY ELECTRICAL CODE. ALL 108" HDPE BY ELECTRICAL CODE. ALL 114" HDPE BY ELECTRICAL CODE. ALL 120" HDPE BY ELECTRICAL CODE. ALL 126" HDPE BY ELECTRICAL CODE. ALL 132" HDPE BY ELECTRICAL CODE. ALL 138" HDPE BY ELECTRICAL CODE. ALL 144" HDPE BY ELECTRICAL CODE. ALL 150" HDPE BY ELECTRICAL CODE. ALL 156" HDPE BY ELECTRICAL CODE. ALL 162" HDPE BY ELECTRICAL CODE. ALL 168" HDPE BY ELECTRICAL CODE. ALL 174" HDPE BY ELECTRICAL CODE. ALL 180" HDPE BY ELECTRICAL CODE. ALL 186" HDPE BY ELECTRICAL CODE. ALL 192" HDPE BY ELECTRICAL CODE. ALL 198" HDPE BY ELECTRICAL CODE. ALL 204" HDPE BY ELECTRICAL CODE. ALL 210" HDPE BY ELECTRICAL CODE. ALL 216" HDPE BY ELECTRICAL CODE. ALL 222" HDPE BY ELECTRICAL CODE. ALL 228" HDPE BY ELECTRICAL CODE. ALL 234" HDPE BY ELECTRICAL CODE. ALL 240" HDPE BY ELECTRICAL CODE. ALL 246" HDPE BY ELECTRICAL CODE. ALL 252" HDPE BY ELECTRICAL CODE. ALL 258" HDPE BY ELECTRICAL CODE. ALL 264" HDPE BY ELECTRICAL CODE. ALL 270" HDPE BY ELECTRICAL CODE. ALL 276" HDPE BY ELECTRICAL CODE. ALL 282" HDPE BY ELECTRICAL CODE. ALL 288" HDPE BY ELECTRICAL CODE. ALL 294" HDPE BY ELECTRICAL CODE. ALL 300" HDPE BY ELECTRICAL CODE.

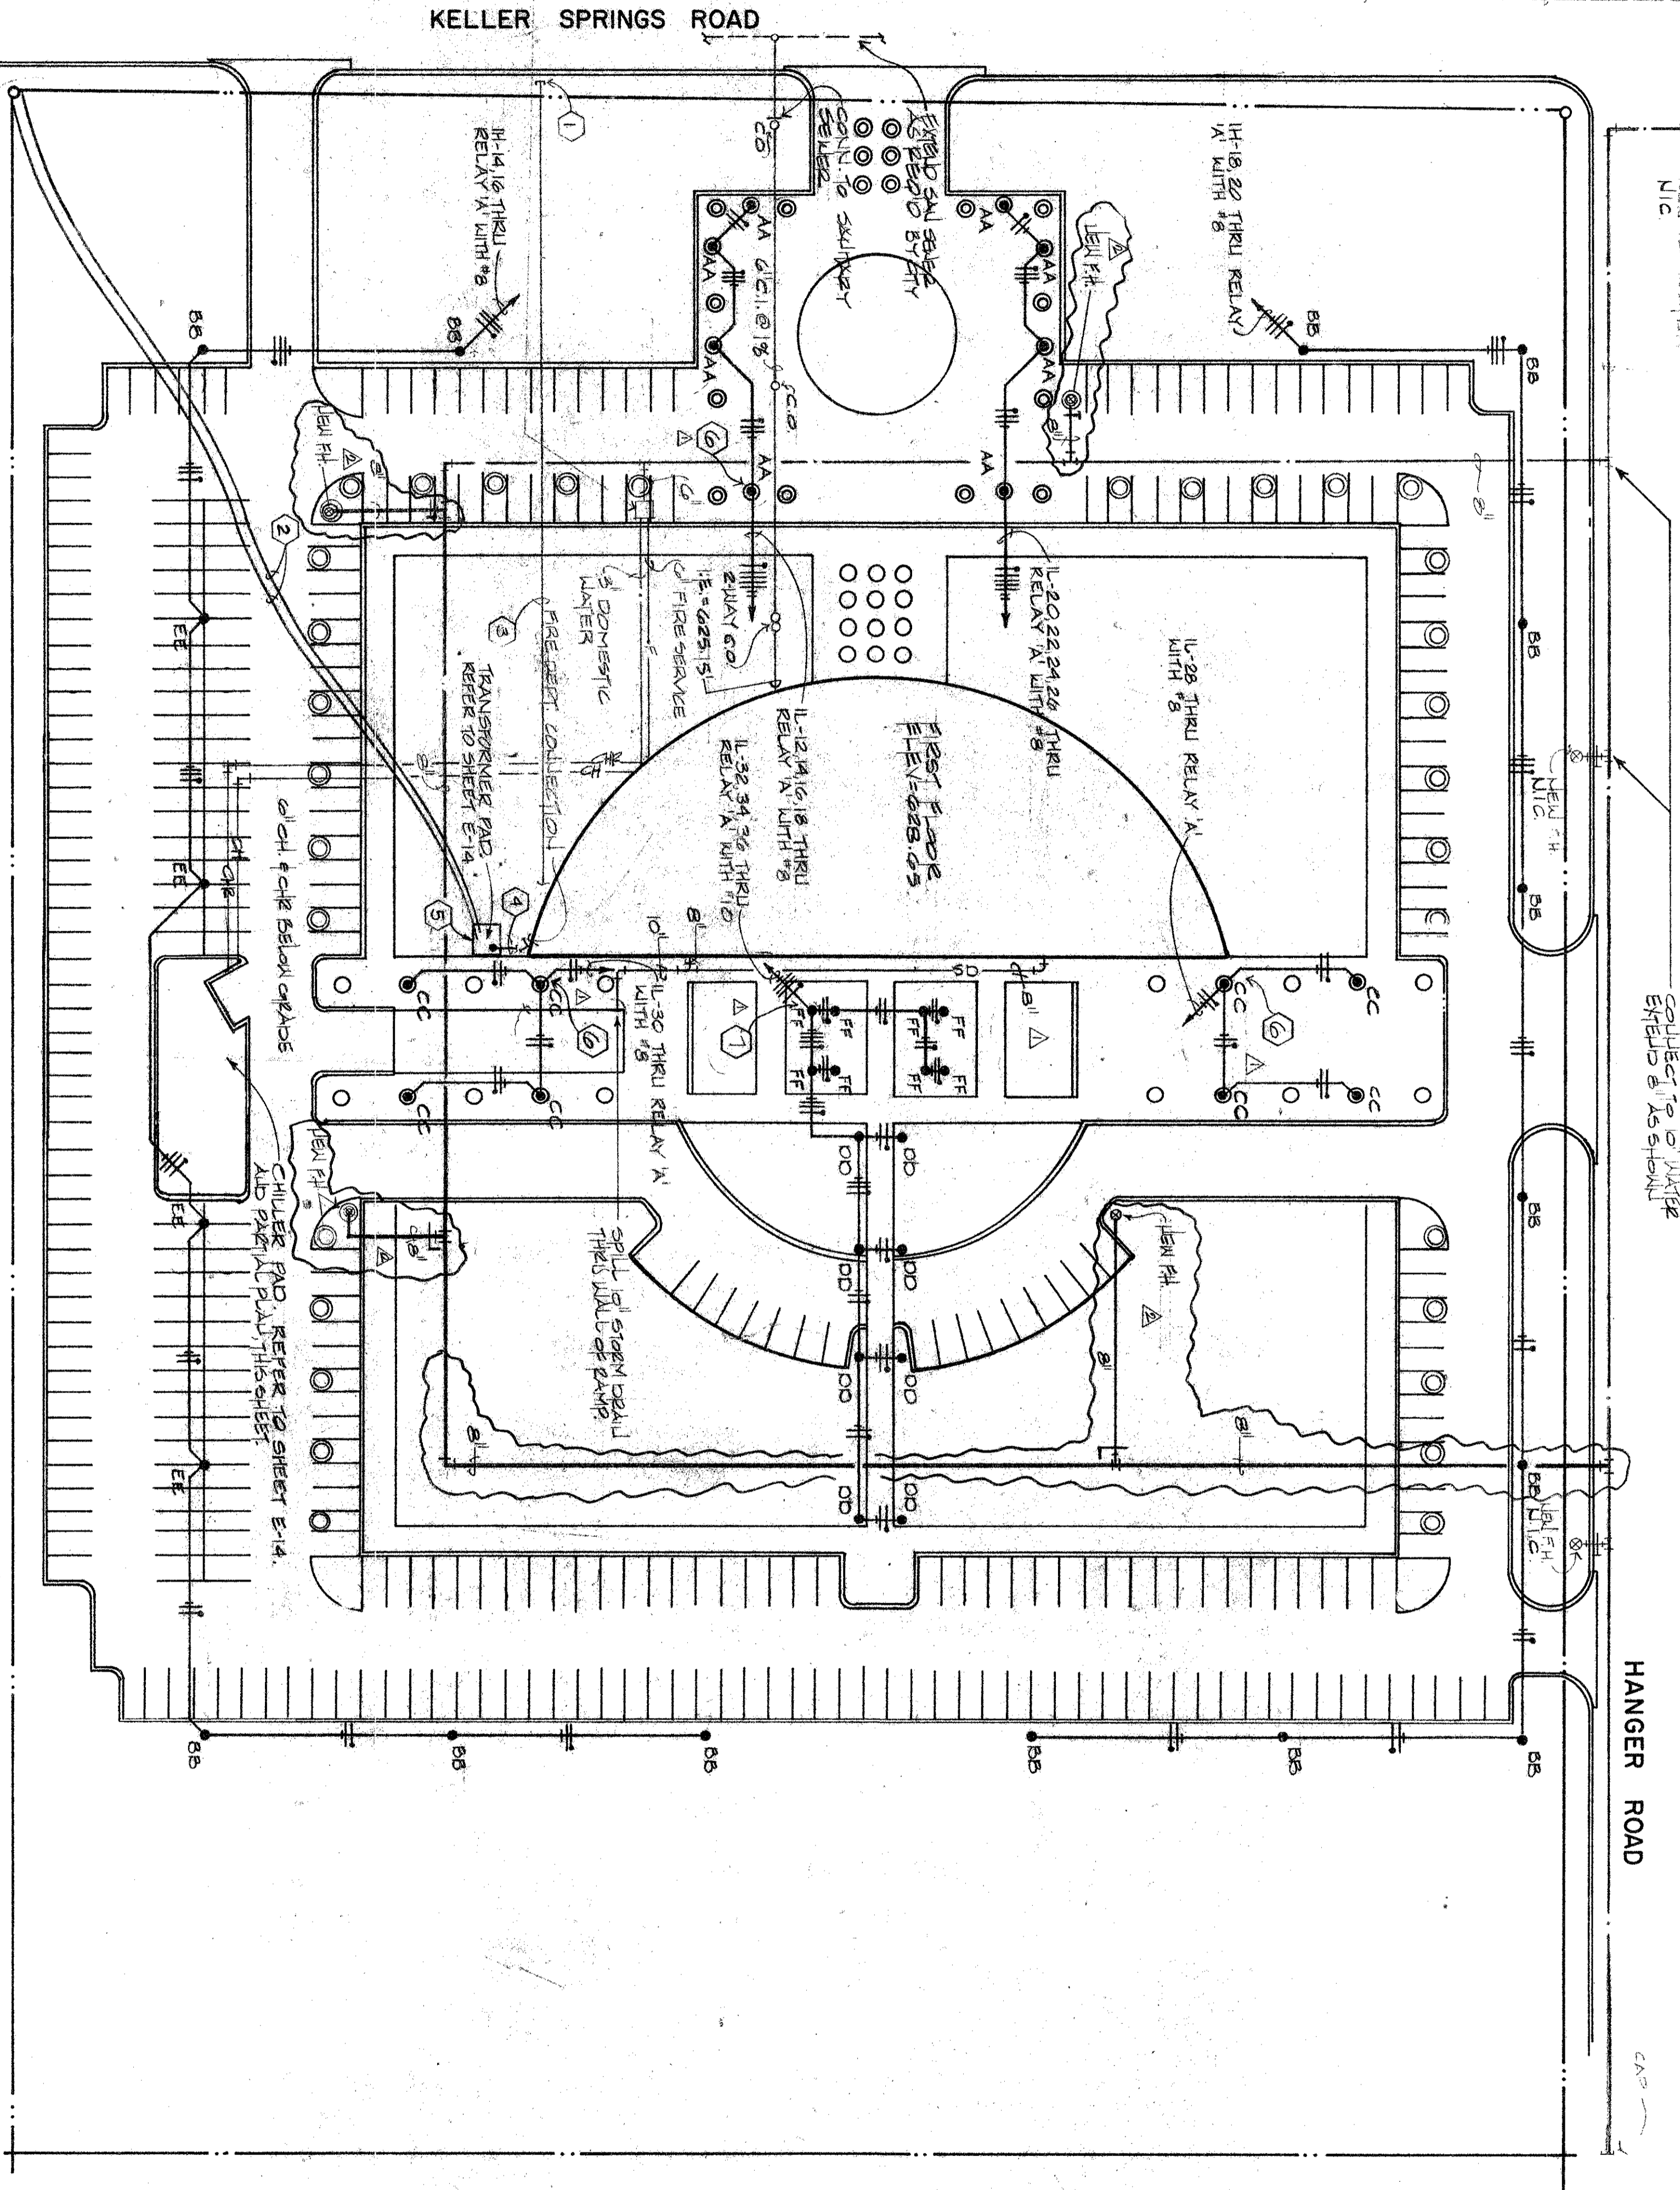

MECHANICAL SYMBOLS LEGEND	
SYMBOL	DESCRIPTION
(Symbol)	COLD WATER
(Symbol)	DOMESTIC HOT WATER
(Symbol)	HEATING WATER SUPPLY
(Symbol)	HEATING WATER RETURN
(Symbol)	CHILLED WATER SUPPLY
(Symbol)	CHILLED WATER RETURN
(Symbol)	CONDENSER WATER SUPPLY
(Symbol)	CONDENSER WATER RETURN
(Symbol)	REFRIGERANT LIQUID
(Symbol)	REFRIGERANT VAPOR
(Symbol)	WASTE
(Symbol)	VENT
(Symbol)	STAINLESS STEEL
(Symbol)	STEEL
(Symbol)	INSULATED CONDENSATE RETURN
(Symbol)	FLUE GAS
(Symbol)	COMBUSTIBLE FIBER
(Symbol)	PIPE
(Symbol)	VALVE
(Symbol)	FLANGE
(Symbol)	UNION
(Symbol)	TELESCOPE
(Symbol)	WALL MOUNT
(Symbol)	BOX MOUNT
(Symbol)	ROOM MOUNT
(Symbol)	ROOF MOUNT
(Symbol)	VENT FAN ROOF
(Symbol)	CLEAR OUT

SITE PLAN
SCALE 1/8"=1'-0"

CHILLER & PUMP DETAIL
SCALE 1/8"=1'-0"

PARTIAL PLAN - MECHANICAL CHILLERS
SCALE 1/8"=1'-0"