

LIGHT FIXTURE SCHEDULE



24	STERNE 441-15-F-48-90-1-2050/R100E 48" x 14" BLACK FINISH WITH DOME FOR EACH LAMP, 10 FOOT TILTING POLE	24-40 WATT INCANDESCENT
30	15" x 24" x 200/81-17914-31888/B1-17914-31888/B1-17914-31888/B1 FORTYFOUR FOOT TILTING POLE WITH BRONZE WHITE BRONZE WHITE BRONZE WHITE BRONZE WHITE BRONZE WHITE BRONZE WHITE BRONZE WHITE BRONZE WHITE	250 WATT INCANDESCENT
CC	STRONG 441-15-F-48-90-1-2050/R100E 48" x 14" BLACK FINISH WITH DOME FOR EACH LAMP, 10 FOOT TILTING POLE	250 WATT INCANDESCENT
DD	LIBERTY 404-4335, 42" HIGH DOLLAND, BLACK FINISH WITH INCANDESCENT	250 WATT INCANDESCENT
EE	SAME AS THE "BB", EXCEPT TALLEY FOOT TILTING BLACK POLE. PIER SHALL EXTEND 24" UP ABOVE PAVEMENT.	250 WATT BRIGHT WHITE DELUXE MERCURY
FF	HUBBELL 800-9-1238, LOCATED AS DIRECTED ON THE JOB SITE, BLACK FINISH.	250 WATT BRIGHT WHITE DELUXE MERCURY

NOTES BY SYMBOL


1. STUD CONDUITS OUT AT PROPERTY LINE TO TELEPHONE CO. REQUIREMENTS.
2. UNDERGROUND PIPING BY ELECTRIC UTILITY COMPANY VERIFY EXACT LOCATION.
3. 2-4" PVC FOR TELEPHONE COMPANY.
4. 6-3/8" CONDUITS, EACH WITH 6500 KWH AND 1-3/8" NEUTRAL.
5. PAD MOUNTED TRANSFORMER BY ELECTRIC UTILITY CO.

① DETECTOR CHECK BY 30' DIAMETER & 30' DEPTH. ALL WORK TO BE IN ACCORDANCE WITH THE LATEST EDITIONS OF THE NATIONAL ELECTRICAL CODE AND ALL LOCAL ORDINANCES. PROVIDE 3" SLAB FOR 4" CONDUIT. PROVIDE 3" SLAB FOR 4" CONDUIT BY LANDSCAPE CONTRACTOR FOR IRRIGATION SYSTEM.


EXIST'G. F.H.
EXIST'G. W/ATER
COLLECT TO EXIST'G. W/ATER

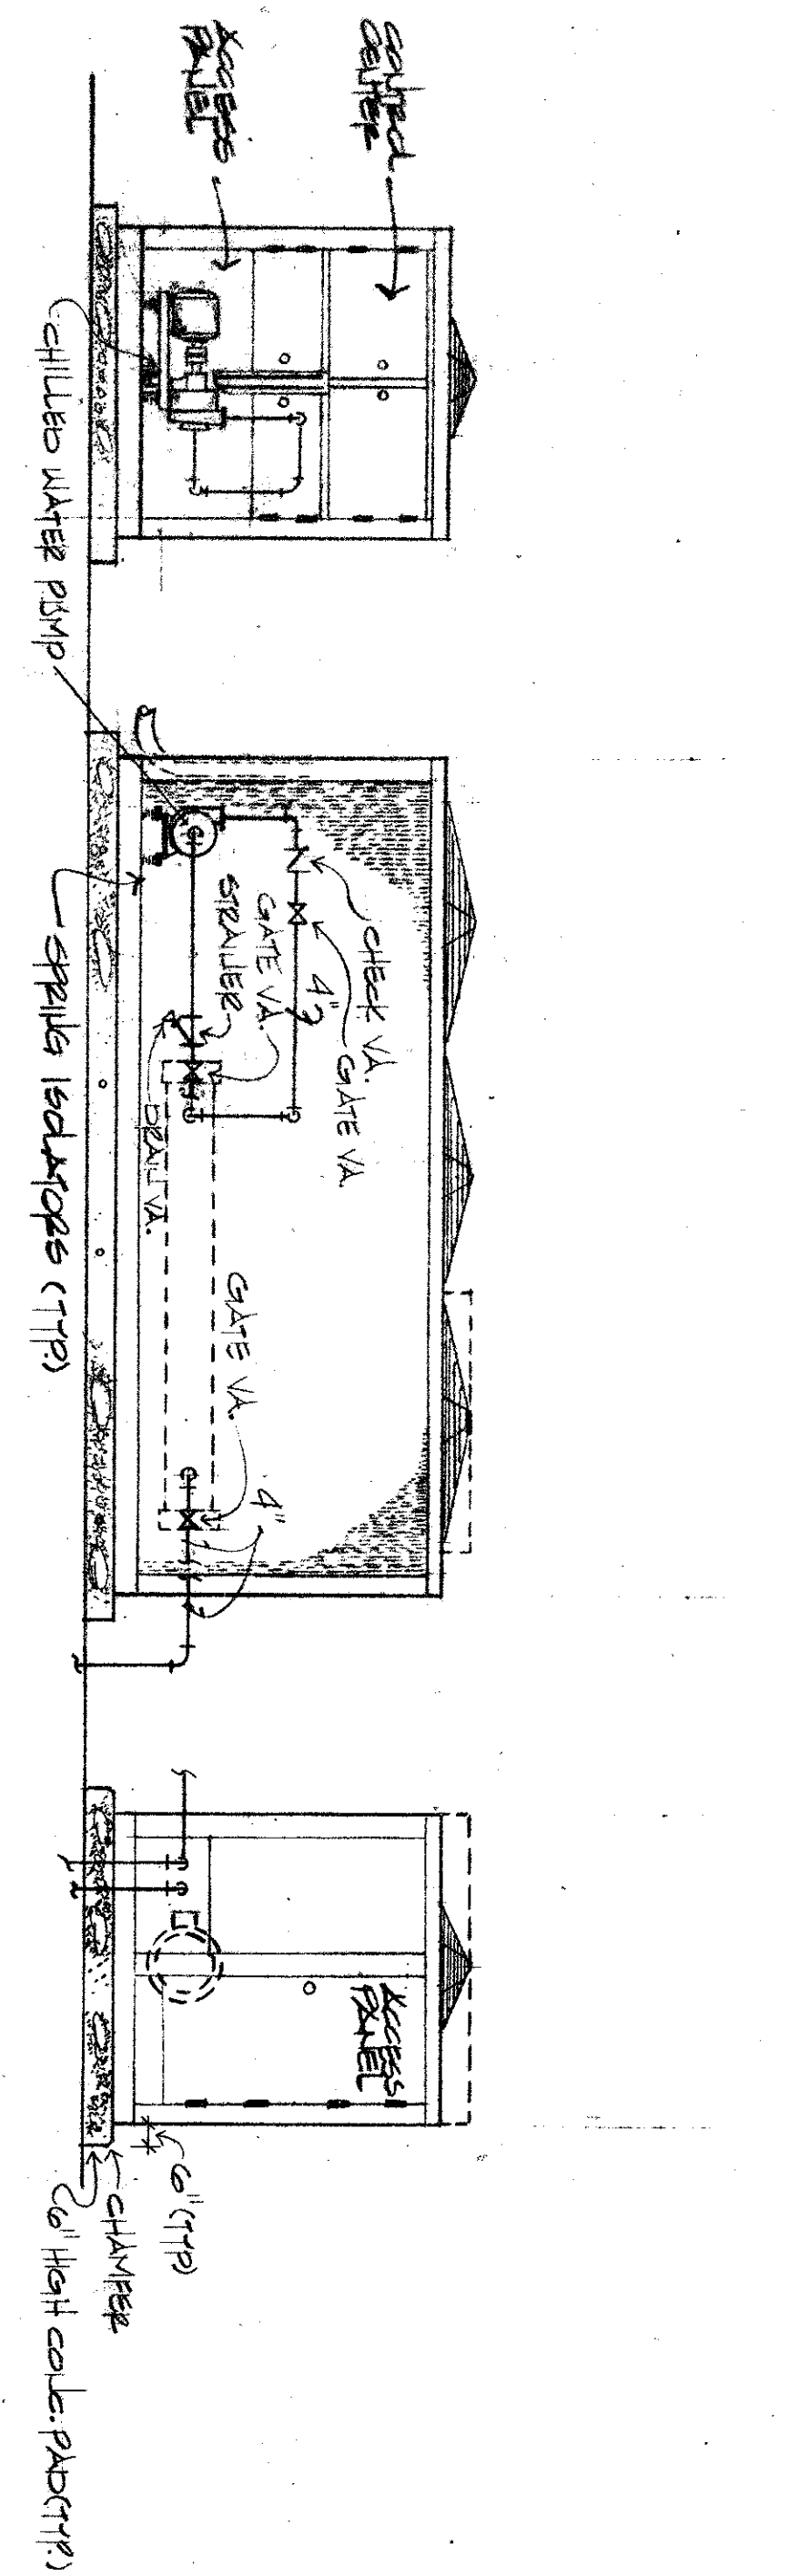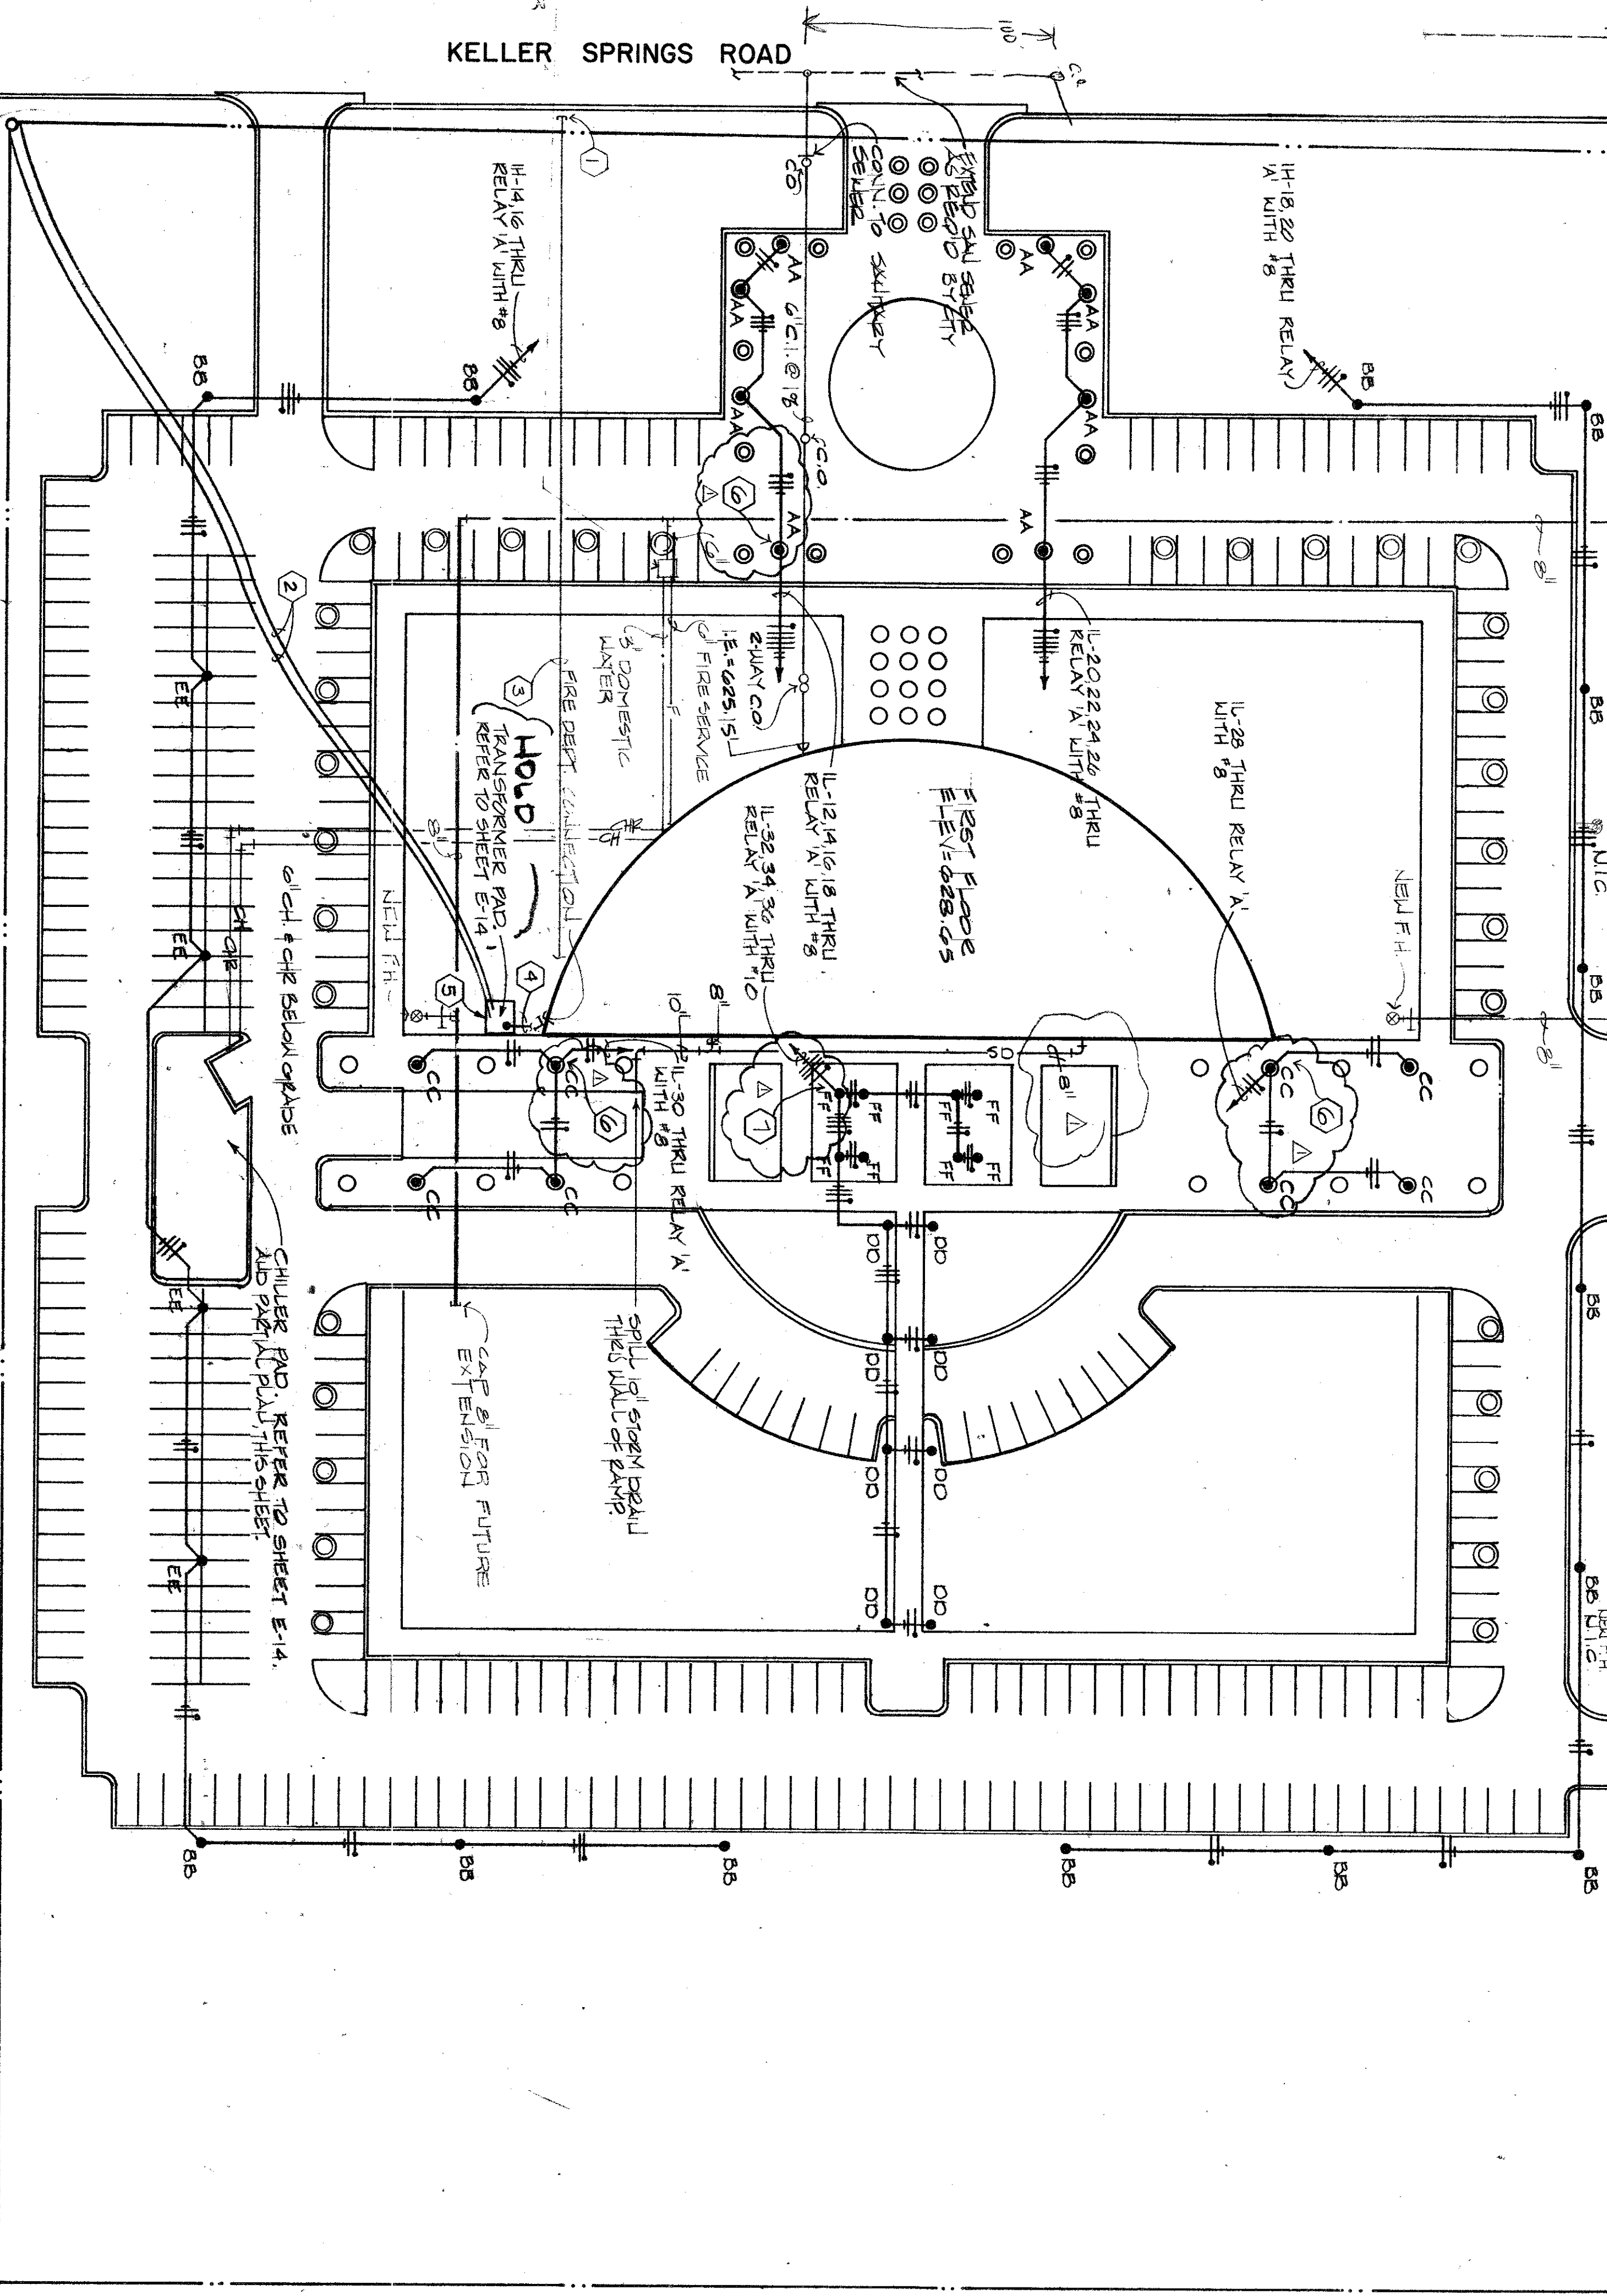

CHILLER & PUMP DETAIL
SCALE: 1/8"=1'-0"

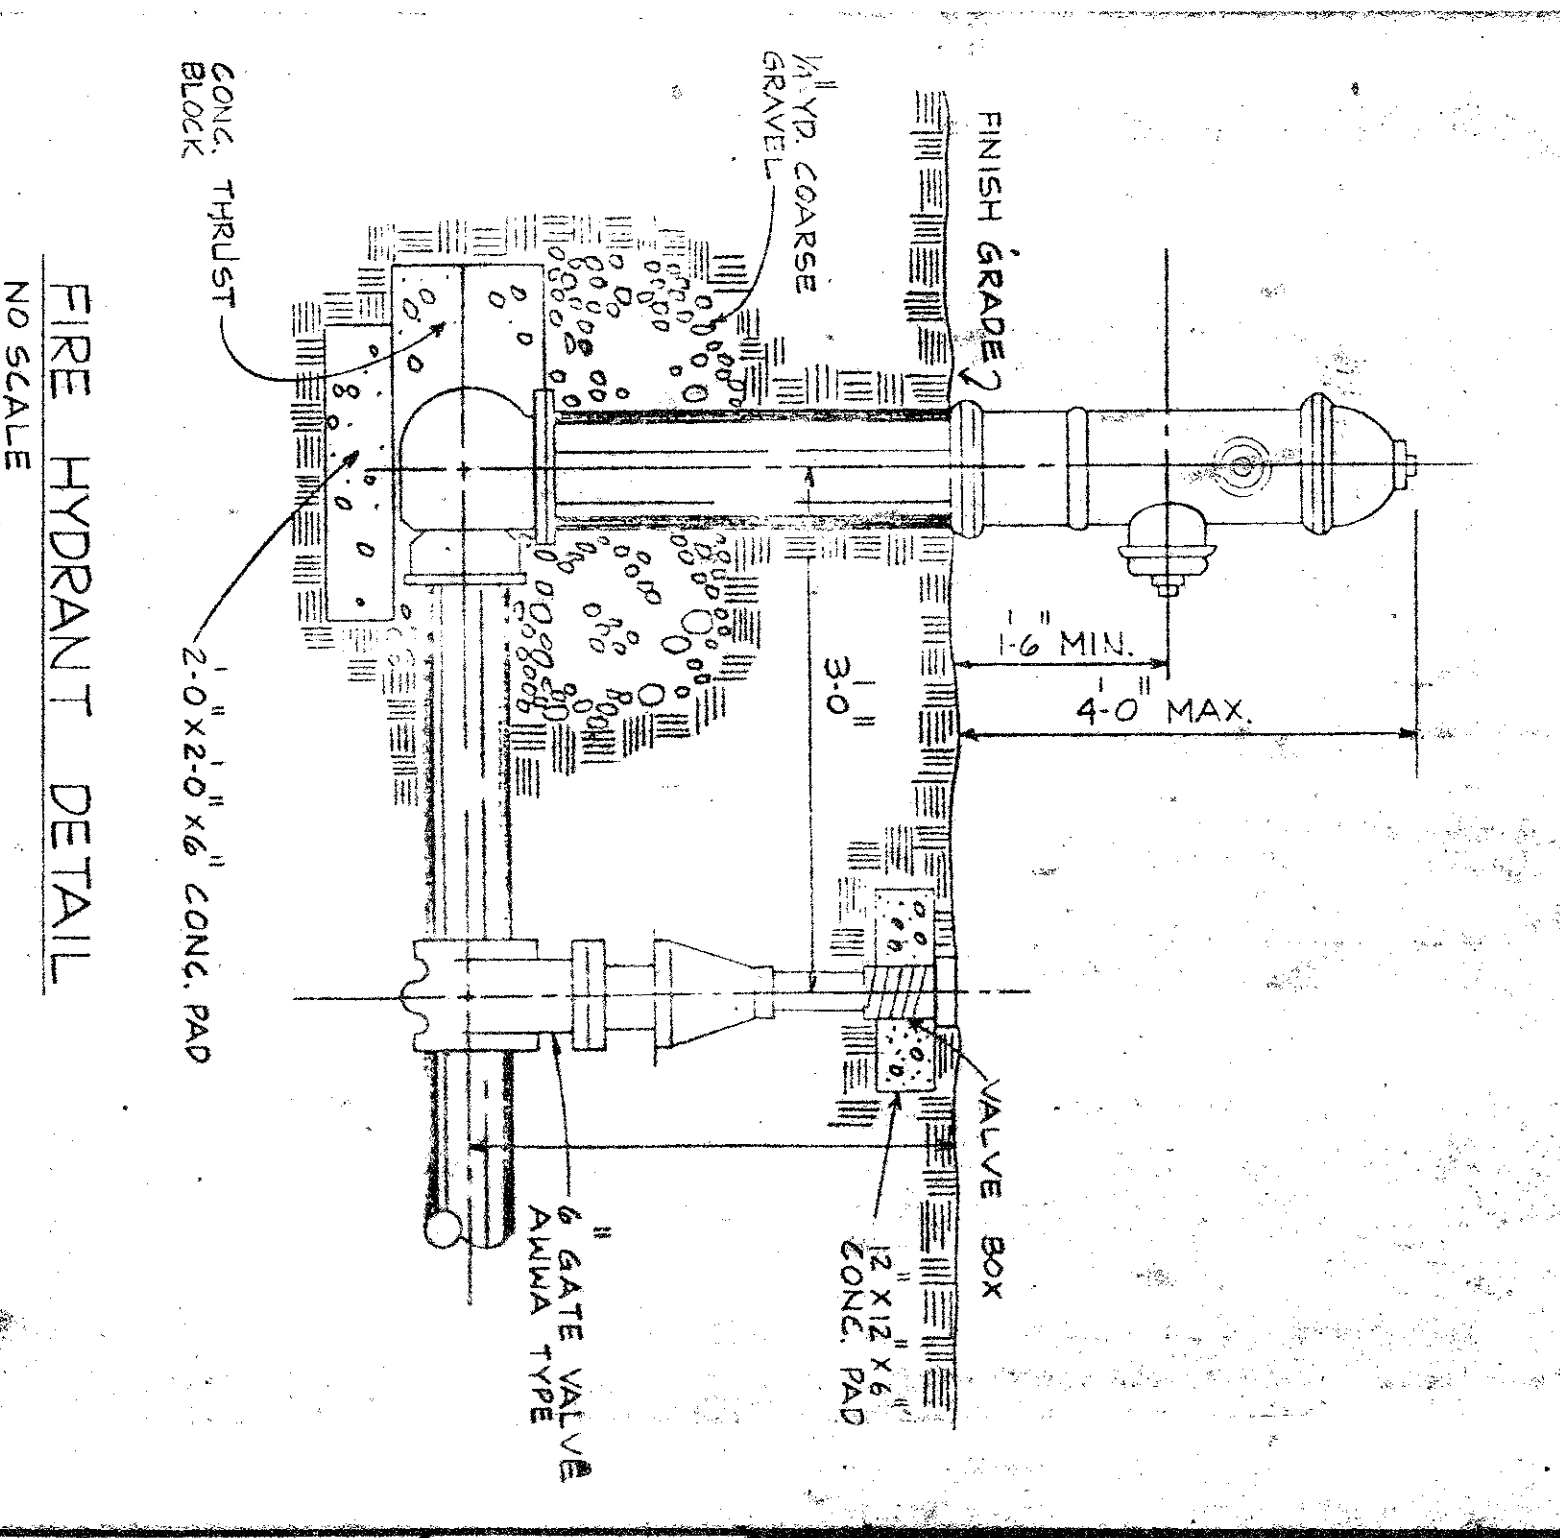

FIRE HYDRANT DETAIL
NO SCALE

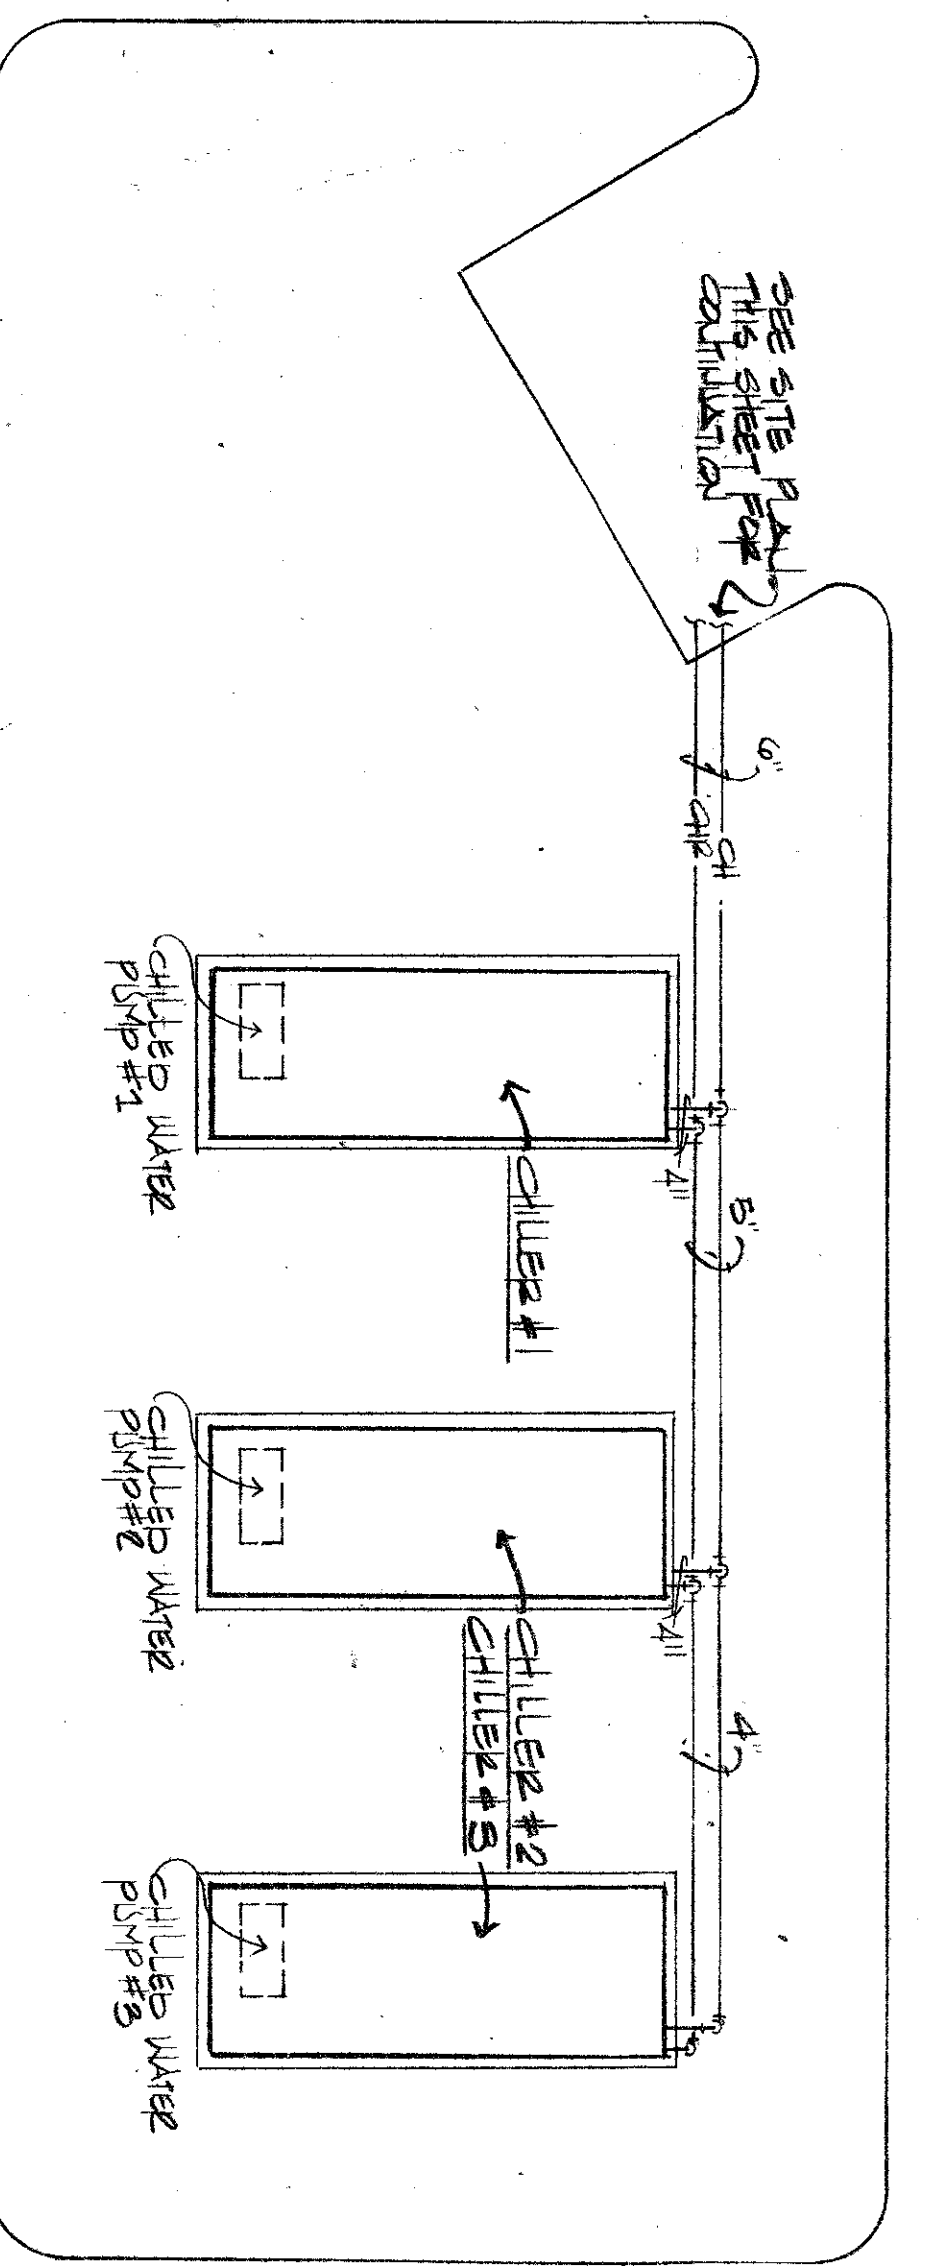

PARTIAL PLAN - VERTICAL CHILLERS
SCALE: 1/8"=1'-0"

MECHANICAL SYMBOLS LEGEND

ALL SYMBOLS NOT NECESSARILY USED

SYMBOL	DESCRIPTION
---	COLD WATER
---	DOMESTIC HOT WATER RETURN
---	HEATING WATER RETURN
---	CHILLED WATER SUPPLY
---	CONDENSER WATER RETURN
---	CONDENSER WATER SUPPLY
---	REFRIGERANT RETURN
---	REFRIGERANT SUPPLY
---	GAS
---	VENT
---	WASTE
---	WASTE VENT
---	STEAM SUPPLY
---	SHARPT CORNER/90° RETURN
---	PUMPED CONDENSATE RETURN
---	CONDENSATE AIR
---	CONDENSATE AIR
---	CHECK VALVE
---	SAFETY VALVE
---	SHRINKER
---	VALVE
---	UNION
---	FLANGE
---	WELD
---	WELD BEAD
---	WELD WIRE
---	WELD WIRE
---	WELD WIRE
---	WELD WIRE
---	WELD WIRE
---	WELD WIRE