


# KELLER SPRINGS LOFTS

## LOFT APARTMENTS IN ADDISON TOWN OF ADDISON, DALLAS COUNTY, TEXAS

### PLANS SUBMITTAL/REVIEW LOG

PERMIT SET - NOT FOR CONSTRUCTION.	08/05/2011
PROJECT COORDINATION SET	08/19/2011
100% COORDINATION SET CITY SUBMITTAL #2	08/26/2011
100% COORDINATION SET CITY SUBMITTAL #3	09/14/2011
ISSUES FOR CONSTRUCTION	10/11/2011

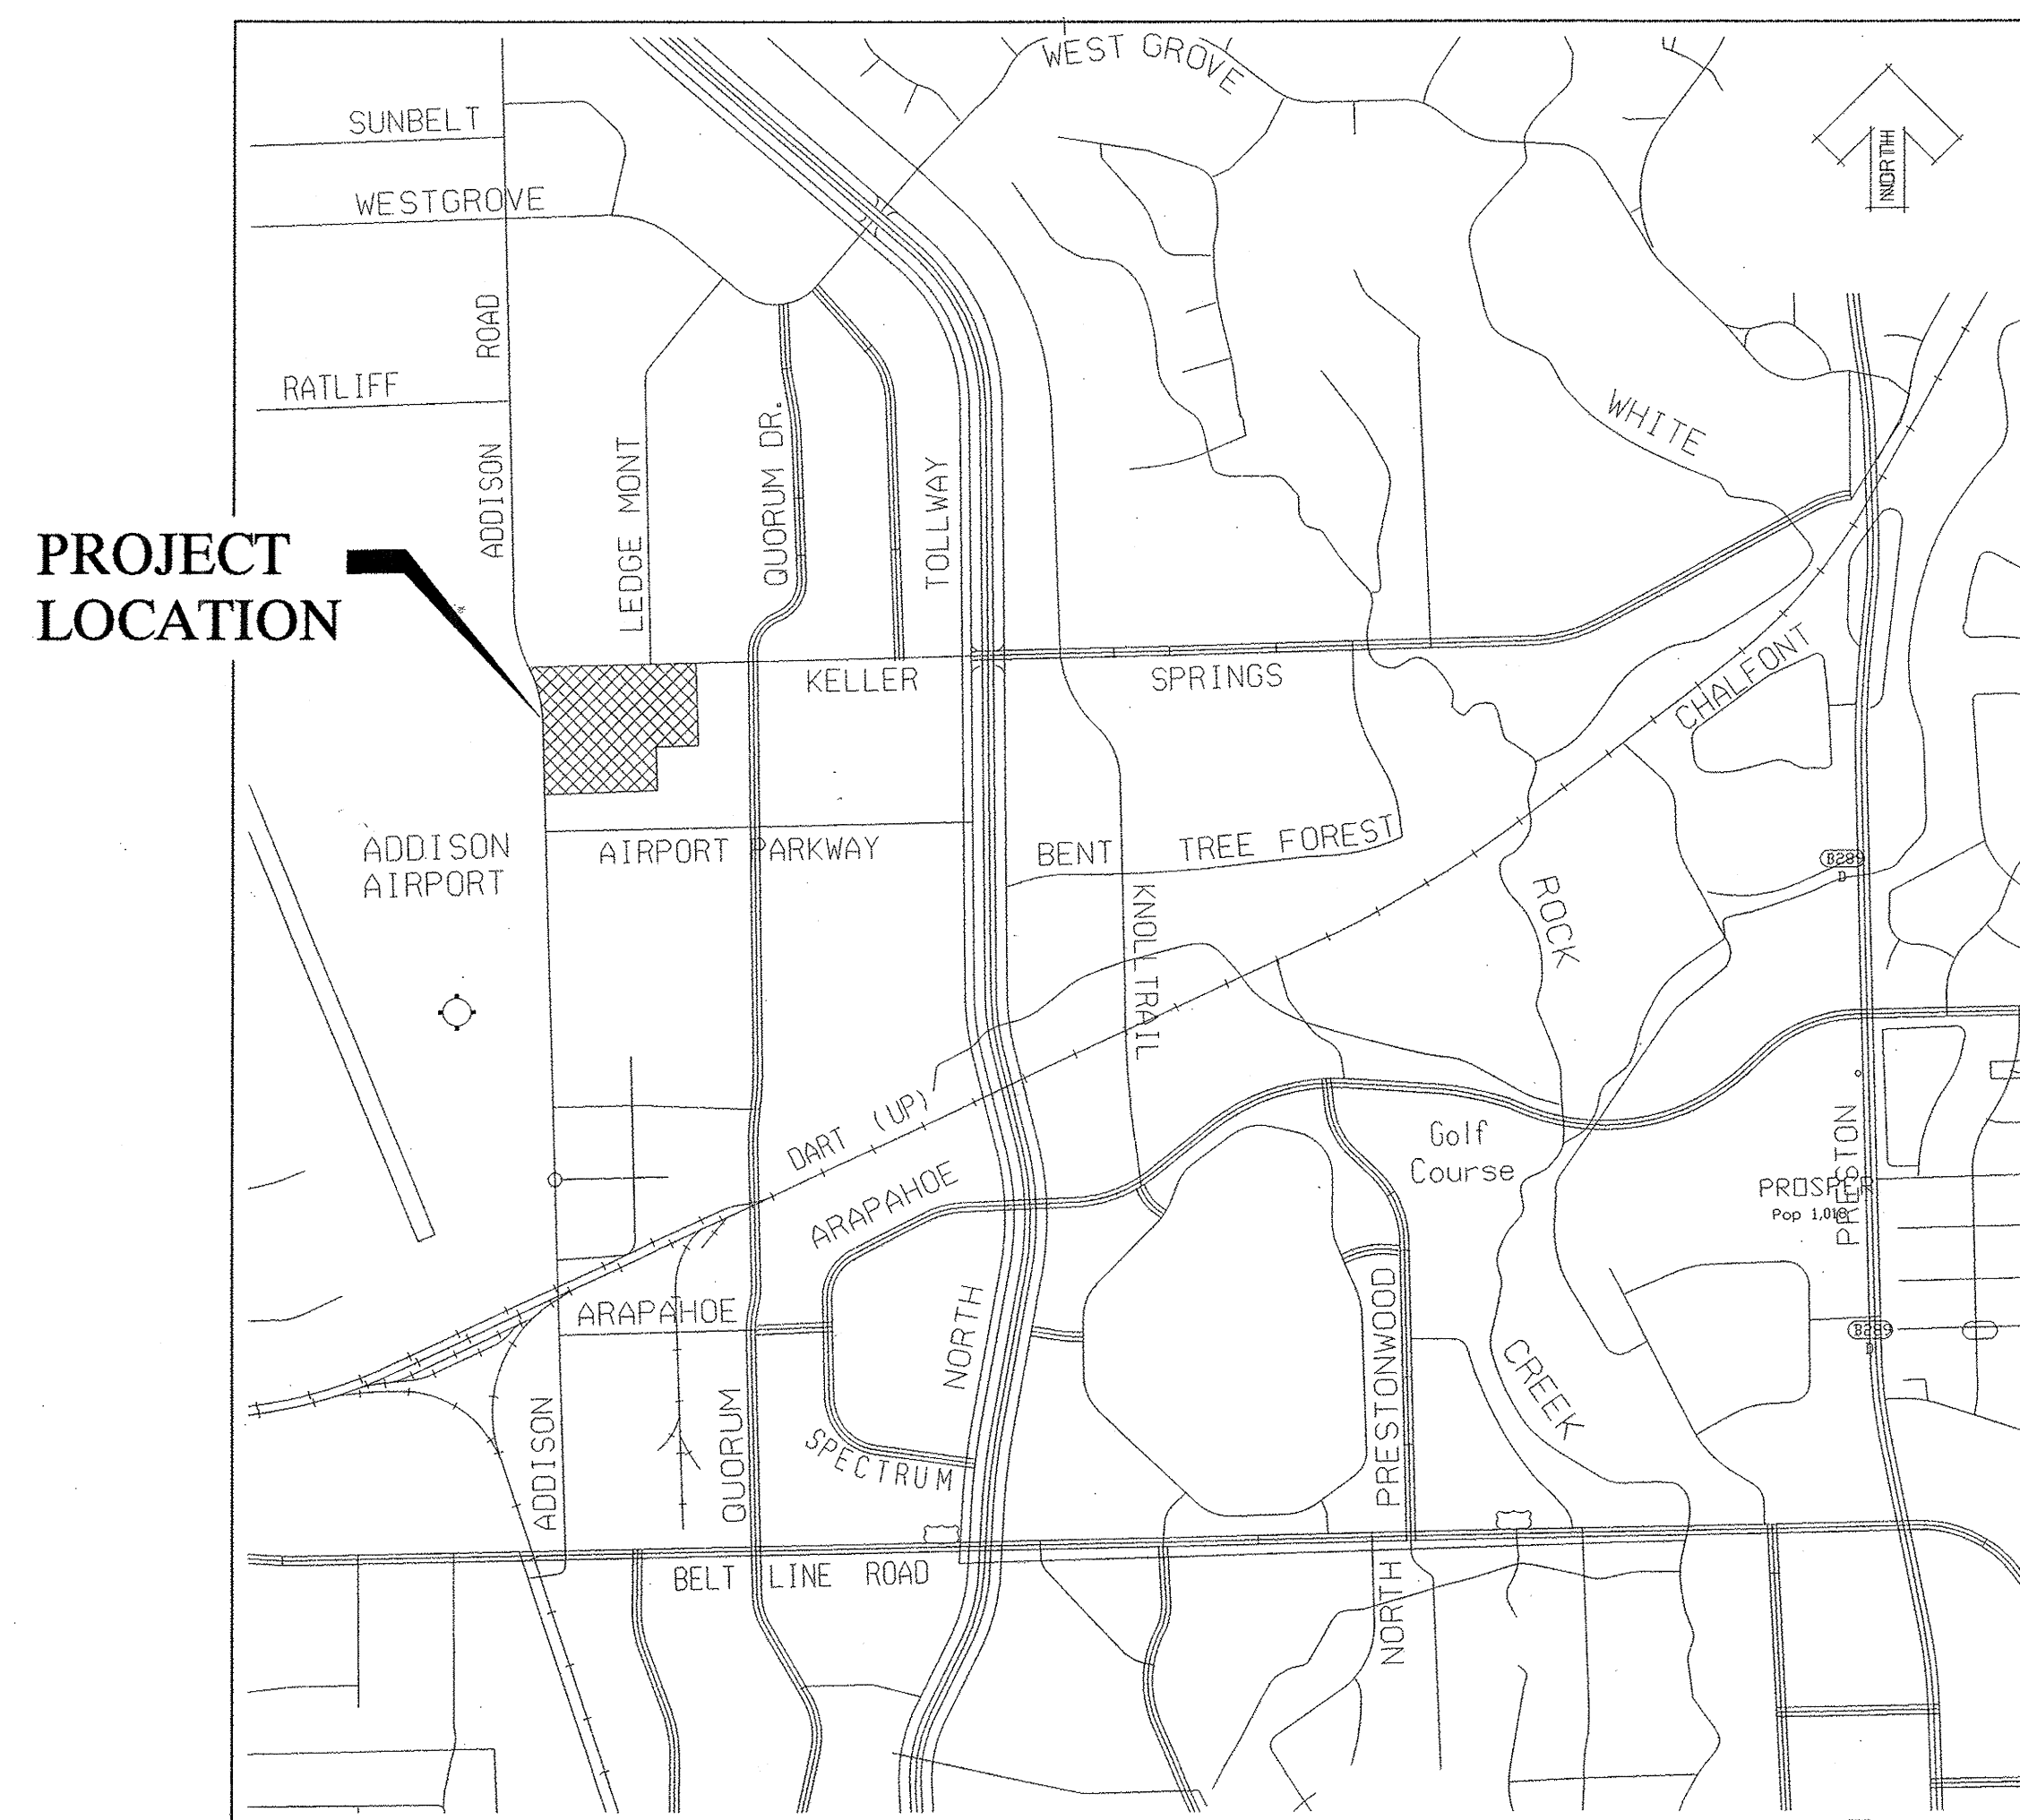

VICINITY MAP  
(NOT TO SCALE)

SHEET LIST	
SHEET NUMBER	SHEET TITLE
C1	COVER SHEET
	FINAL PLAT
C2	GENERAL NOTES
C2a	TOWN OF ADDISON WATER AND WASTEWATER REQUIREMENTS
C2b	TOWN OF ADDISON WATER AND WASTEWATER REQUIREMENTS
C3	DIMENSION CONTROL PLAN
C4	GRADING PLAN
C4a	PAVING PLAN
C5	DRAINAGE AREA MAP
C6	DETENTION POND CALCULATIONS
C7	DRAINAGE CALCULATIONS
C8	STORM SEWER PLAN
C8a	TREE DRAIN PLAN
C9	STORM SEWER PROFILES
C10	WATER & WASTEWATER PLAN - PROFILE
C10a	ELECTRICAL SITE PLAN
C11-11a	POLLUTION CONTROL PLAN
C12-12b	PAVING DETAILS
C13-C14	STORM WATER DETAILS
C15-C20	JUNCTION STRUCTURE DETAILS
C21-C22a	WATER DETAILS
C23	WASTEWATER DETAILS
C24	UTILITY DETAILS

PREPARED FOR:

**Embrey Partners, Ltd.**

1020 NE Loop 410, Ste 700  
San Antonio, Texas 78209

PREPARED BY:



**Kimley-Horn  
and Associates, Inc.**

12700 Park Central Drive, Suite 1800, Dallas, TX 75251-1516 972-770-1300  
Firm Registration No. F-928

**OCTOBER 11, 2011**  
**PW# 2006-001**

