


REVISIONS

1	9-2-2011	DESIGN REVISIONS
2	9-13-2011	ANSI/FHA COMMENTS
3	9-23-2011	DESIGN REVISIONS
4	10-17-2011	CONSTRUCTION ISSUE

KELLER SPRINGS LOFTS

LOFT APARTMENTS IN ADDISON, TEXAS

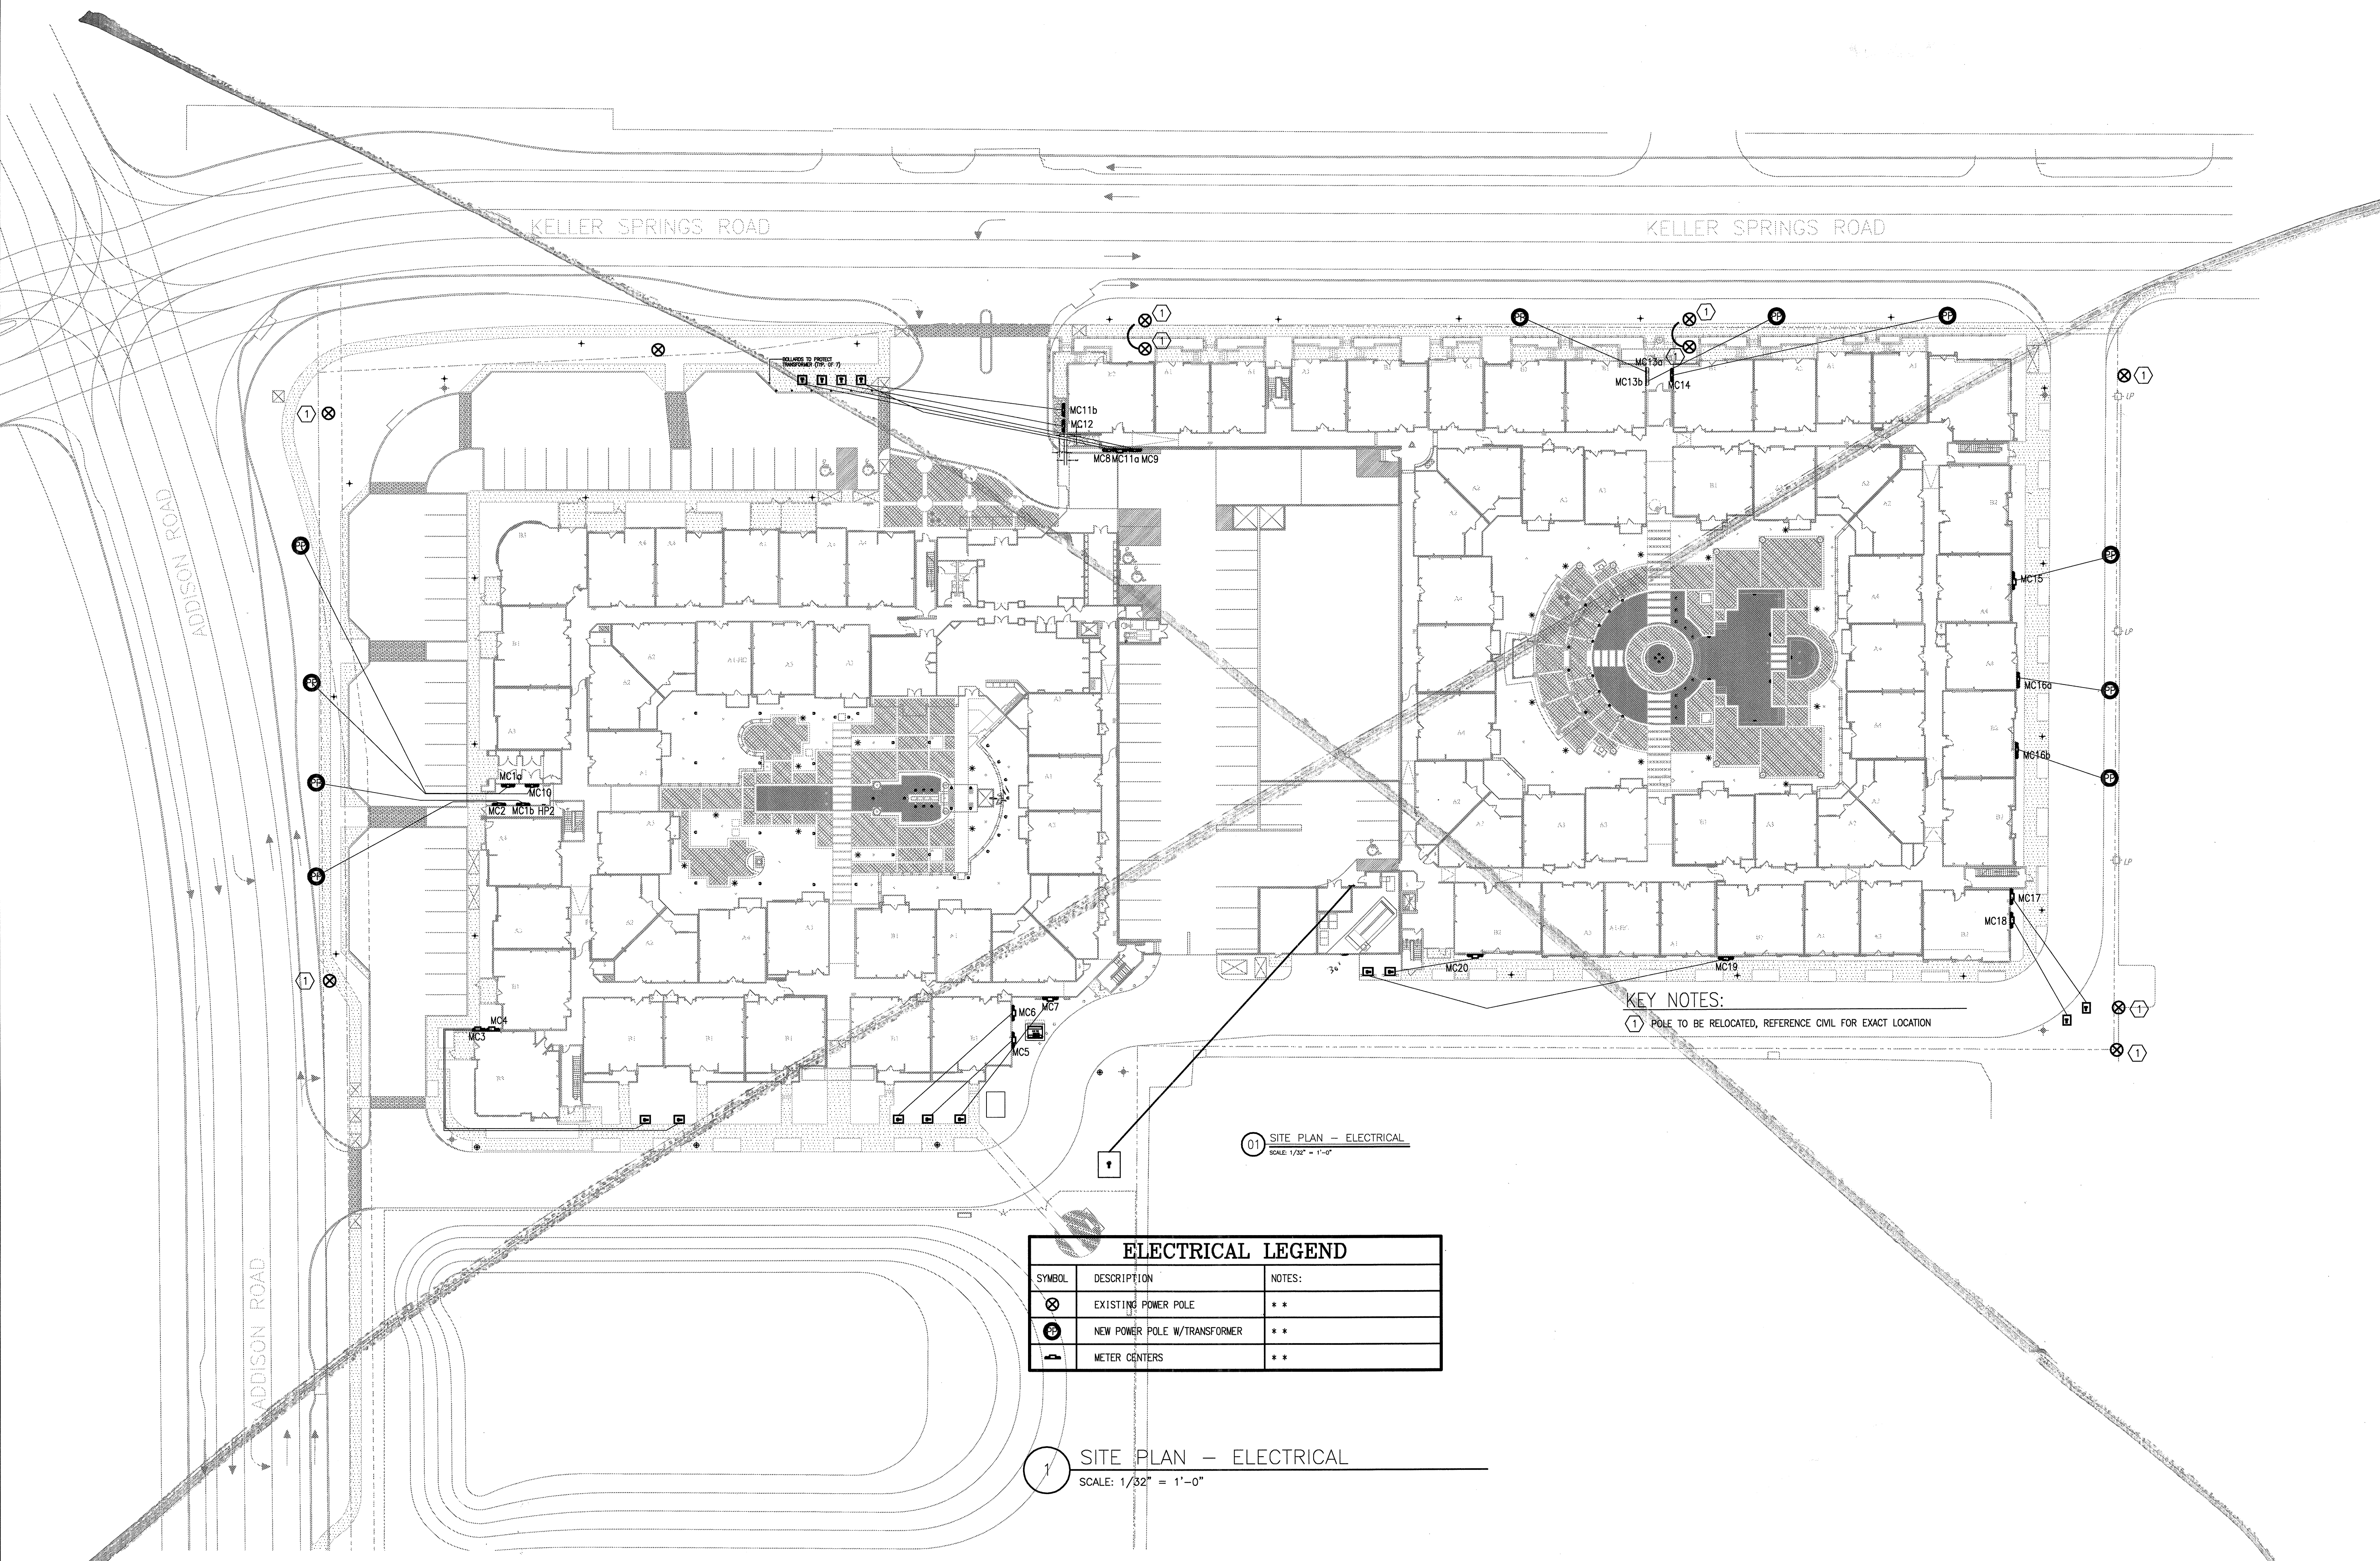

KEY NOTES:
 ① POLE TO BE RELOCATED, REFERENCE CIVIL FOR EXACT LOCATION

01 SITE PLAN - ELECTRICAL
 SCALE: 1/32" = 1'-0"

ELECTRICAL LEGEND		
SYMBOL	DESCRIPTION	NOTES:
⊗	EXISTING POWER POLE	**
⊕	NEW POWER POLE W/TRANSFORMER	**
Ⓜ	METER CENTERS	**

1 SITE PLAN - ELECTRICAL
 SCALE: 1/32" = 1'-0"

JSE Jordan & Skala Engineers
 14200 Midway Road, Suite 350
 Dallas, TX 75244-9138
 V: (469) 383-1616 F: (469) 383-1613
 Project Number - 113-0355 Texas Firm Registration # F-4990
 Drawn By: MJ Checked By: RAD

BGO architects
 4144 N. Central Exp.
 Suite 855
 Dallas, TX 75204
 214.520.8878
 bgoarchitects.com

DATE
 08-05-11

PROJECT
 11129

SHEET NUMBER

E-10.1
 SITE PLAN
 ELECTRICAL