

REVISIONS	
1	9-2-2011 DESIGN REVISIONS
2	9-13-2011 ANSI/FHA COMMENTS
3	9-23-2011 DESIGN REVISIONS
4	10-17-2011 CONSTRUCTION ISSUE

KELLER SPRINGS LOFTS

LOFT APARTMENTS IN ADDISON, TEXAS

BGO architects
 4144 N. Central Expy.
 Suite 855
 Dallas, TX 75204
 214.520.8878
 bgoarchitects.com

DATE
 08-05-11


PROJECT
 11129

SHEET NUMBER
E-3.1C

GENERAL NOTES:

G-1 U.N.O., ALL LIGHTING FIXTURES SHALL BE TYPE 'B'.

G-2 ALL EMERGENCY LIGHTS (E.A.) SHALL BE CONNECTED TO THE UNSWITCHED PHASE CONDUCTOR OF THE CIRCUIT SERVING THE RESPECTIVE AREA.

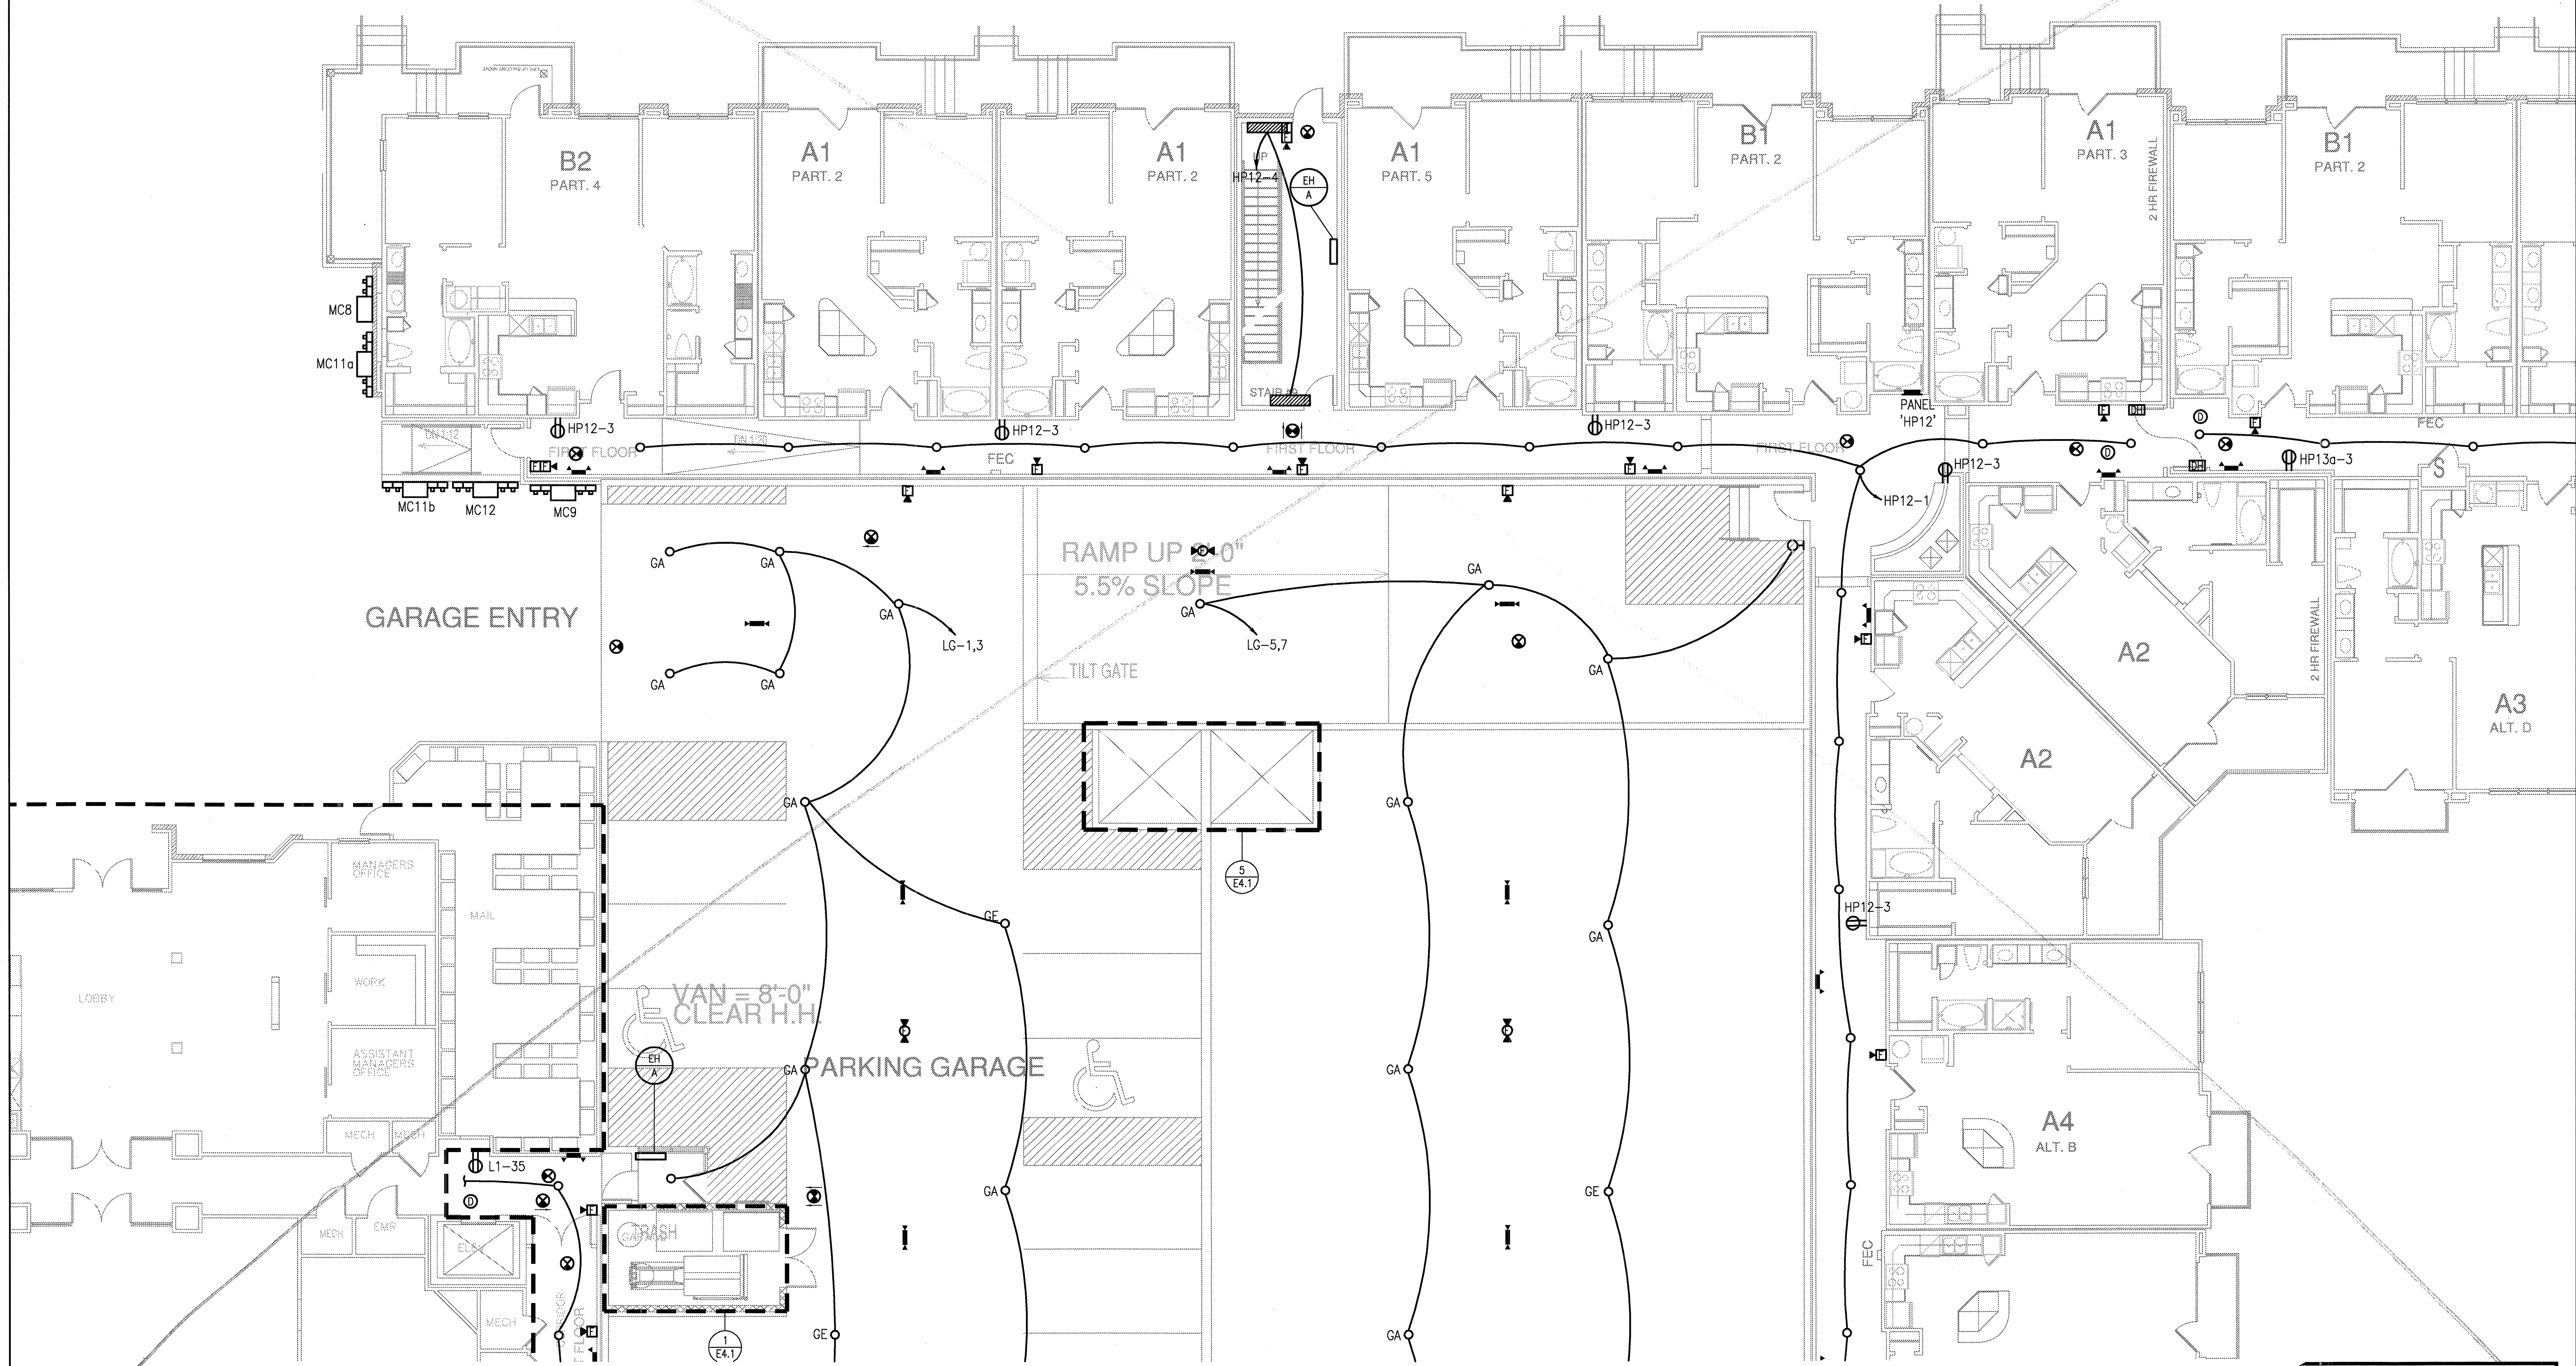

1 DIVISION 'C' FIRST FLOOR PLAN
 SCALE: 1/8" = 1'-0"

JSE Jordan & Skala Engineers
 14250 Midway Road, Suite 350
 Dallas, TX 75244-5138
 V: (469) 383-1616 F: (469) 383-1613
 Project Number - 113-055 Texas Firm Registration # F-4990
 Drawn By: MB Checked By: RAD