


CLUBHOUSE

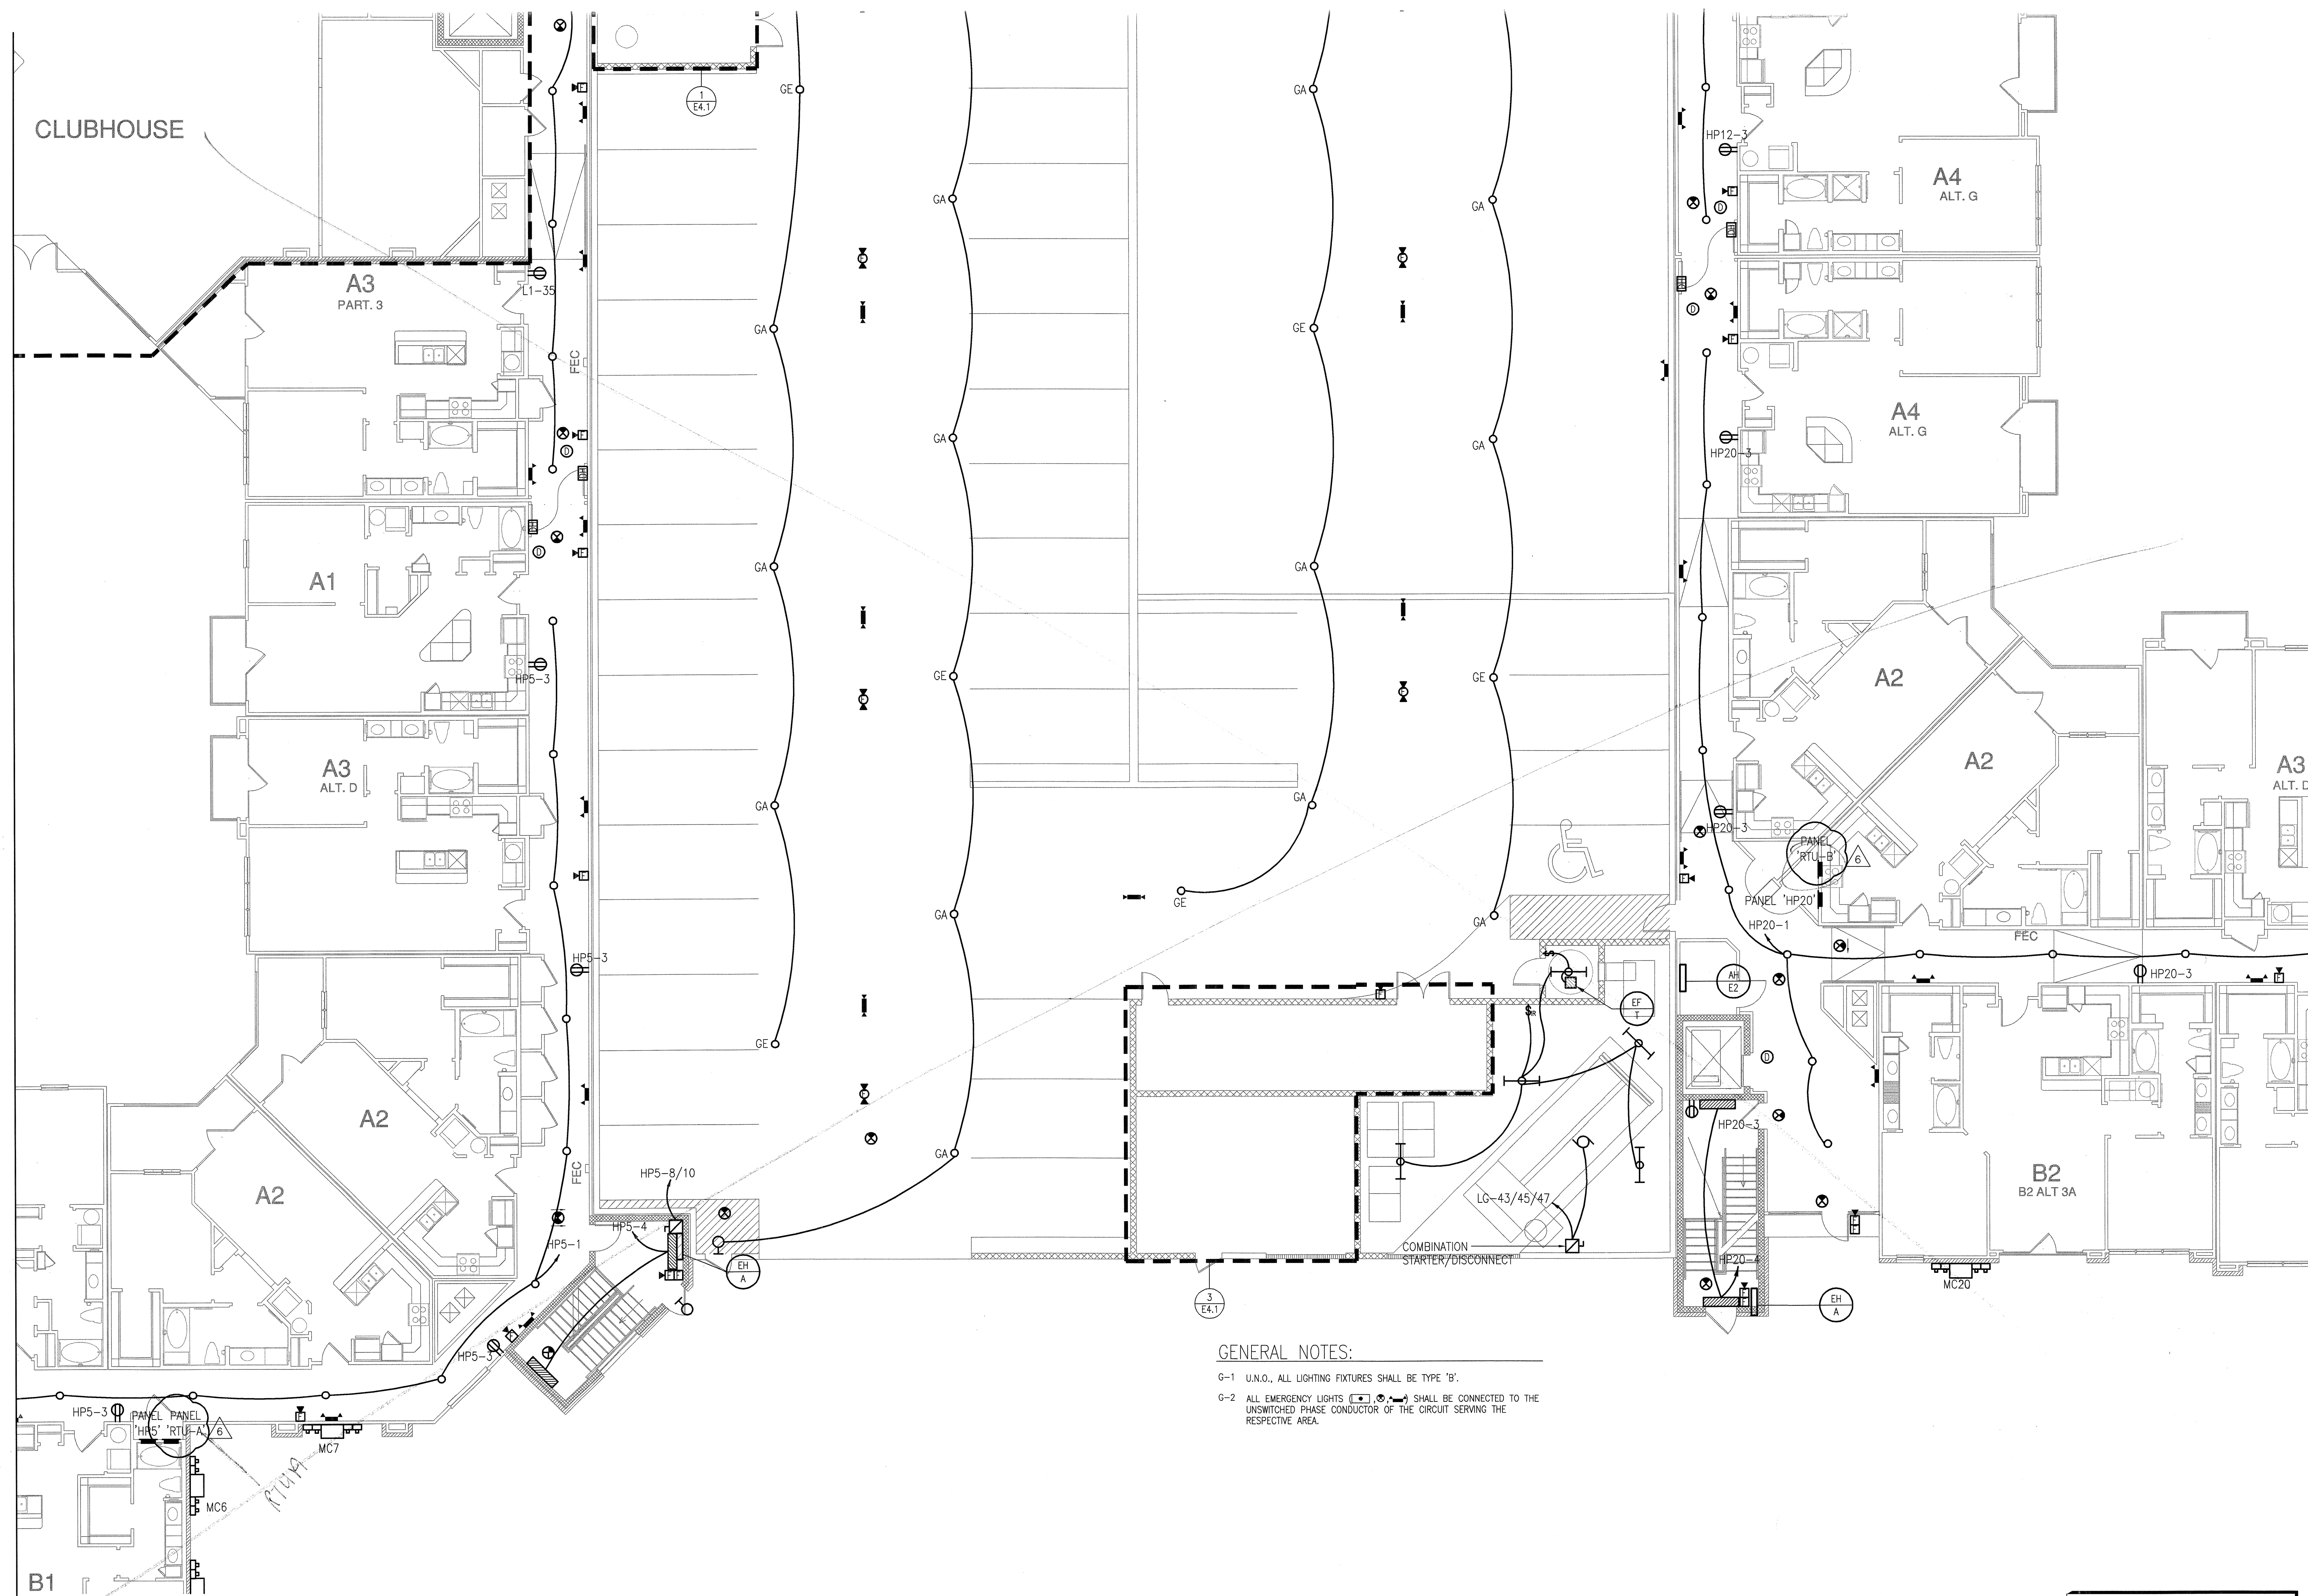

GENERAL NOTES:

- G-1 U.N.O., ALL LIGHTING FIXTURES SHALL BE TYPE 'B'.
- G-2 ALL EMERGENCY LIGHTS (E) SHALL BE CONNECTED TO THE UNSWITCHED PHASE CONDUCTOR OF THE CIRCUIT SERVING THE RESPECTIVE AREA.

1 DIVISION 'D' FIRST FLOOR PLAN
 SCALE: 1/8" = 1'-0"

REVISIONS		
1	9-2-2011	DESIGN REVISIONS
2	9-13-2011	ANSI/FHA COMMENTS
3	9-23-2011	DESIGN REVISIONS
4	10-17-2011	CONSTRUCTION ISSUE
5	12-21-2011	DESIGN REVISIONS

KELLER SPRINGS LOFTS
 LOFT APARTMENTS IN ADDISON, TEXAS

BGO
 architects
 4144 N. Central Expy.
 Suite 855
 Dallas, TX 75204
 214.520.8878
 bgoarchitects.com

DATE
 08-05-11

PROJECT
 11129

SHEET NUMBER
E-3.1D

JSE Jordan & Skala Engineers
 14248 Midway Road, Suite 330
 Dallas, TX 75244-5138
 V: (469) 385-1616 F: (469) 385-1615
 Project Number - 113-0355 Texas Firm Registration # F-4990
 Drawn By: MJ Checked By: RAD

JHP