

REVISIONS	
9-2-2011	DESIGN REVISIONS
9-13-2011	ANSI/FHA COMMENTS
9-23-2011	DESIGN REVISIONS
10-17-2011	CONSTRUCTION ISSUE

# KELLER SPRINGS LOFTS

LOFT APARTMENTS IN ADDISON, TEXAS

**BGO**  
architects  
4144 N. Central Expy.  
Suite 855  
Dallas, TX 75204  
214.520.8878  
bgoarchitects.com


DATE  
08-05-11

PROJECT  
11129

SHEET NUMBER

**E-3.1D**

**JSE** Jordan & Skala Engineers  
14240 Midway Road, Suite 350  
Dallas, TX 75244-5139  
Project Number - 113-0355 Texas Firm Registration # F-4990  
Drawn By: MJ Checked By: RAD

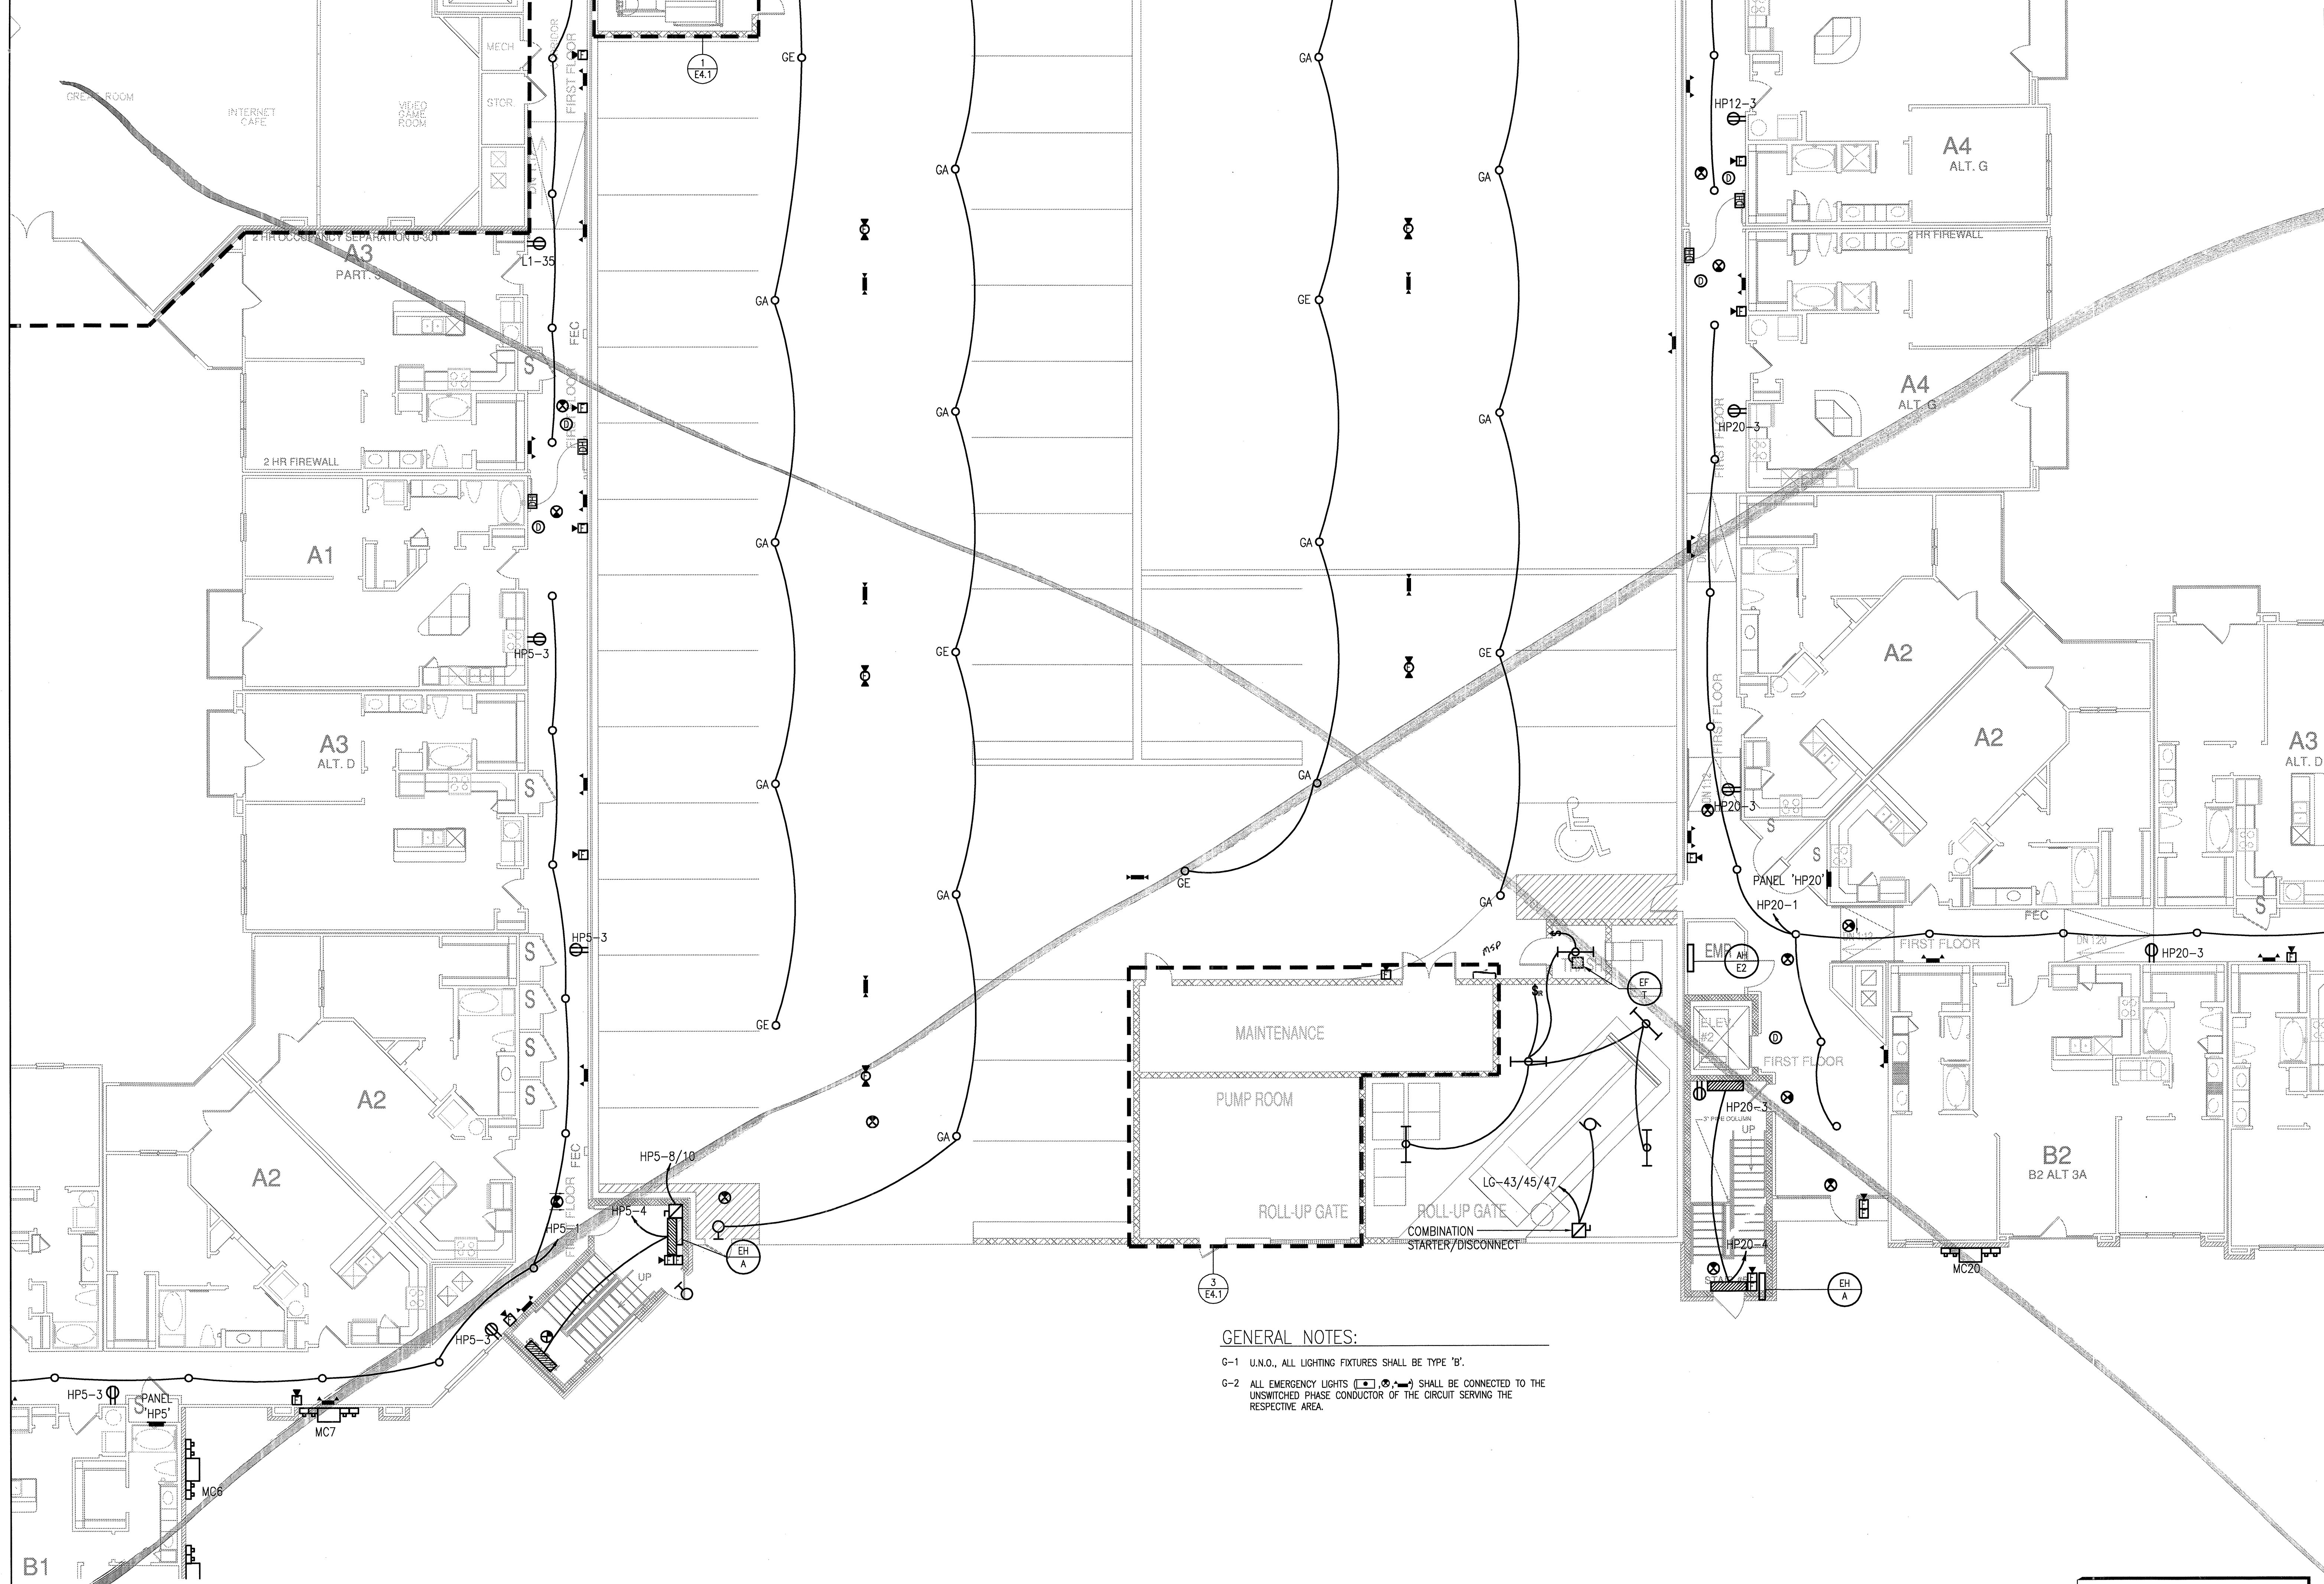

- GENERAL NOTES:**
- G-1 U.N.O., ALL LIGHTING FIXTURES SHALL BE TYPE 'B'.
  - G-2 ALL EMERGENCY LIGHTS (EH A) SHALL BE CONNECTED TO THE UNSWITCHED PHASE CONDUCTOR OF THE CIRCUIT SERVING THE RESPECTIVE AREA.

1 DIVISION 'D' FIRST FLOOR PLAN  
SCALE: 1/8" = 1'-0"