


REVISIONS	
1	9-2-2011 DESIGN REVISIONS
2	9-13-2011 ANSI/FHA COMMENTS
3	9-23-2011 DESIGN REVISIONS
4	10-17-2011 CONSTRUCTION ISSUE

GENERAL NOTES:
 G-1 U.N.O., ALL LIGHTING FIXTURES SHALL BE TYPE 'B'.
 G-2 ALL EMERGENCY LIGHTS (EHL) SHALL BE CONNECTED TO THE UNSWITCHED PHASE CONDUCTOR OF THE CIRCUIT SERVING THE RESPECTIVE AREA.

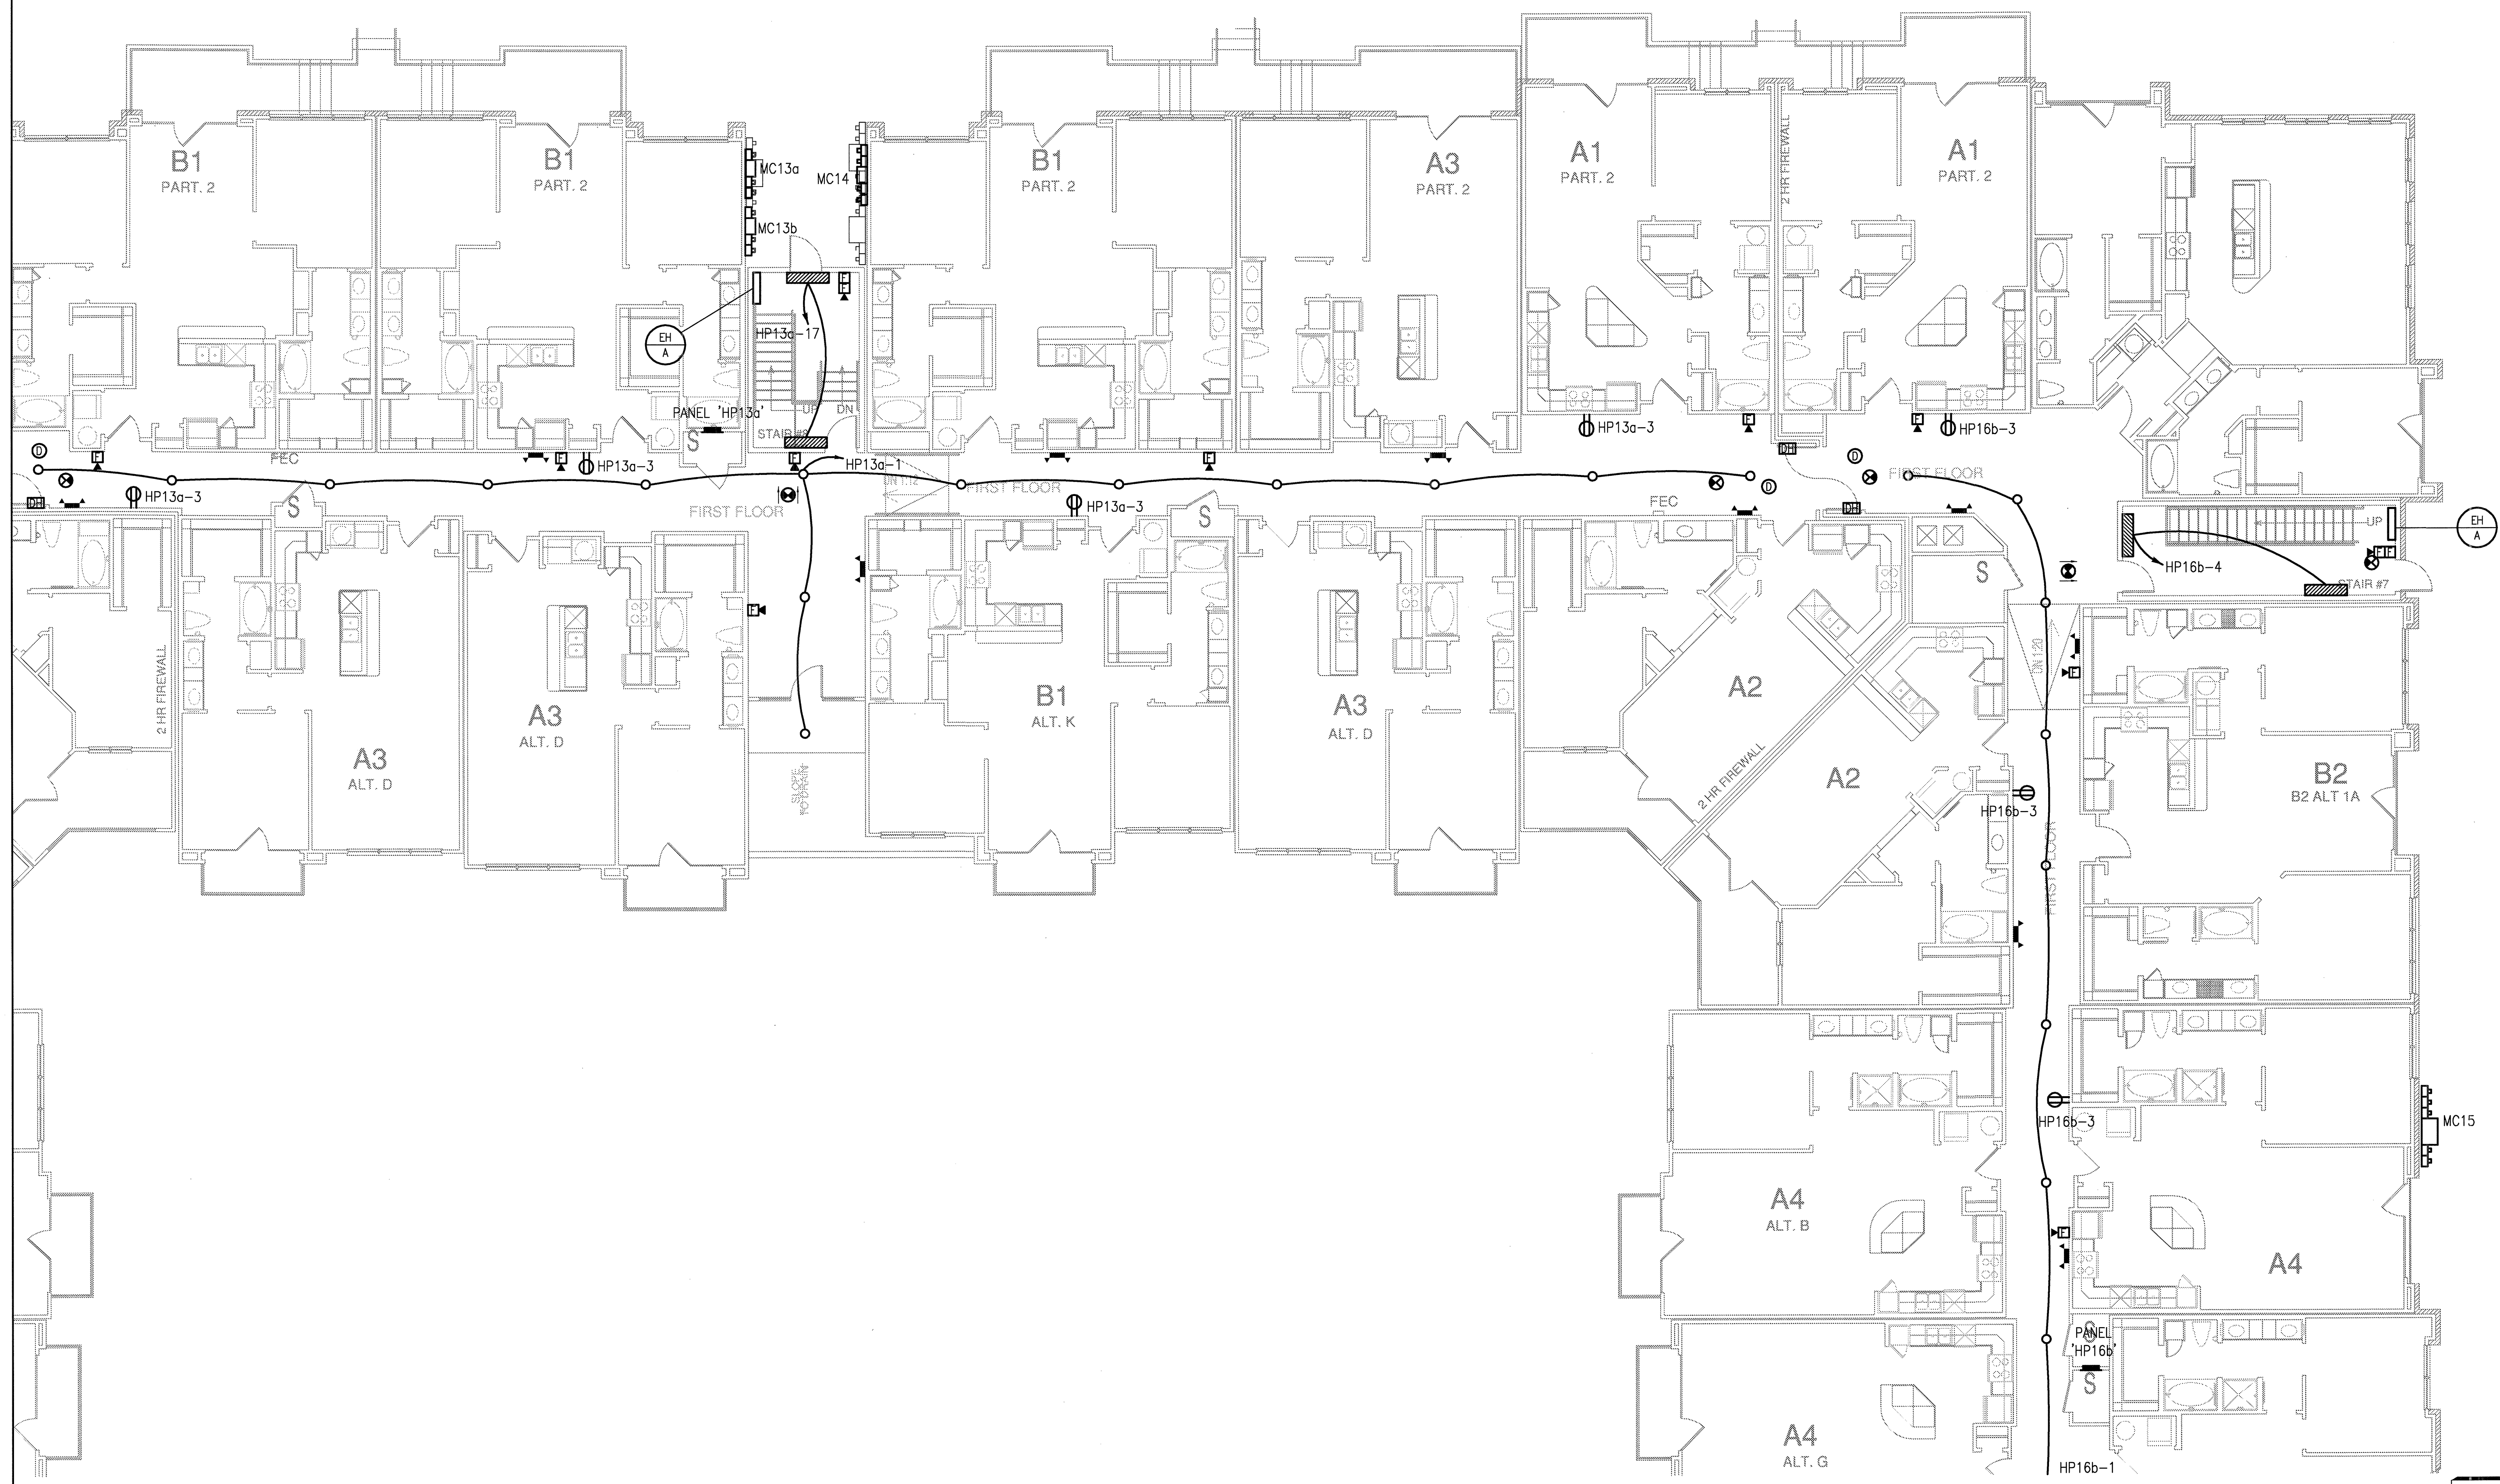

KELLER SPRINGS LOFTS
 LOFT APARTMENTS IN ADDISON, TEXAS

BGO
architects
 4144 N. Central Expy.
 Suite 855
 Dallas, TX 75204
 214.520.8878
 bgoarchitects.com

DATE
 08-05-11

PROJECT
 11129

SHEET NUMBER
E-3.1E

1 DIVISION 'E' FIRST FLOOR PLAN
 SCALE: 1/8" = 1'-0"

JSE Jordan & Skala Engineers
 14240 Midway Road, Suite 350
 Dallas, TX 75244-5138
 Project Number - 113-0355 Texas Firm Registration # F-4990
 Drawn By: MJ Checked By: RAD