



GENERAL NOTES:

G-1 U.N.O., ALL LIGHTING FIXTURES SHALL BE TYPE 'B'.

G-2 ALL EMERGENCY LIGHTS (E.L.) SHALL BE CONNECTED TO THE UNSWITCHED PHASE CONDUCTOR OF THE CIRCUIT SERVING THE RESPECTIVE AREA.

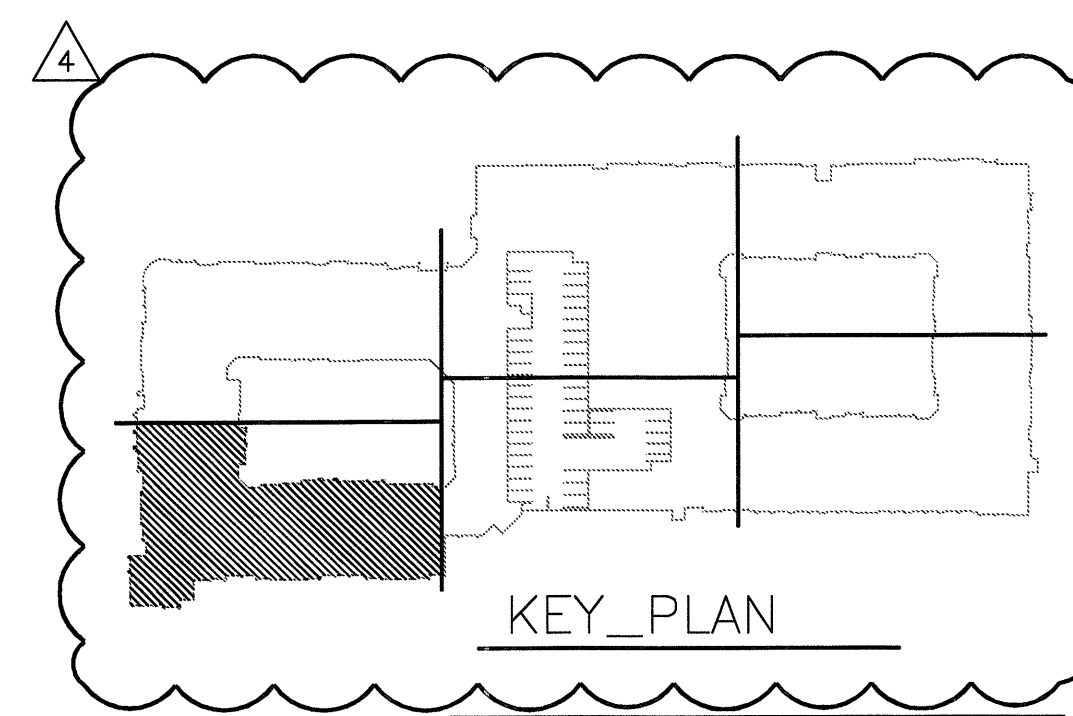

1 DIVISION 'B' SECOND FLOOR PLAN
SCALE: 1/8" = 1'-0"

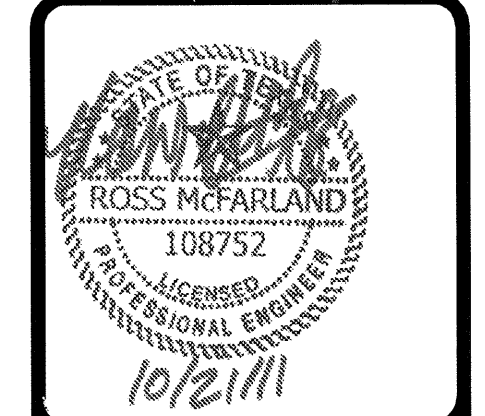


REVISIONS

1	9-2-2011	DESIGN REVISIONS
2	9-13-2011	ANSI/FHA COMMENTS
3	9-23-2011	DESIGN REVISIONS
4	10-17-2011	CONSTRUCTION ISSUE

KELLER SPRINGS LOFTS

LOFT APARTMENTS IN ADDISON, TEXAS

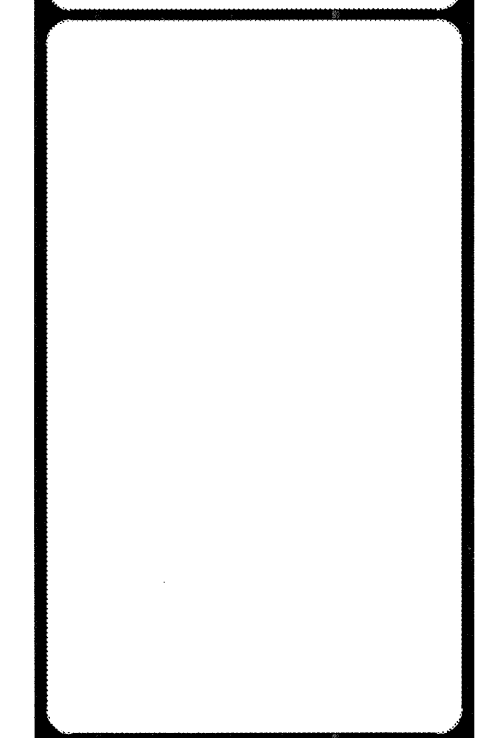

BGO architects
4144 N. Central Expy. Suite 855
Dallas, TX 75204
214.520.8878
bgoarchitects.com

DATE
08-05-11

PROJECT
11129

SHEET NUMBER

E-3.2B

JSE Jordan & Skala Engineers
14200 Midway Road, Suite 350
Dallas, TX 75244-5138
V: (469) 383-1616 F: (469) 383-1613
Project Number - 113-0355 Texas Firm Registration # F-4990
Drawn By: MJ Checked By: RAD