

**GENERAL NOTES:**

- G-1 U.N.O., ALL LIGHTING FIXTURES SHALL BE TYPE 'B'.
- G-2 ALL EMERGENCY LIGHTS (EFT) SHALL BE CONNECTED TO THE UNSWITCHED PHASE CONDUCTOR OF THE CIRCUIT SERVING THE RESPECTIVE AREA.

1 DIVISION 'D' SECOND FLOOR PLAN  
SCALE: 1/8" = 1'-0"



REVISIONS	
1	9-2-2011 DESIGN REVISIONS
2	9-13-2011 ANSI/FHA COMMENTS
3	9-23-2011 DESIGN REVISIONS
4	10-17-2011 CONSTRUCTION ISSUE

**KELLER SPRINGS LOFTS**  
LOFT APARTMENTS IN ADDISON, TEXAS


**BGO**  
architects  
4144 N. Central Expy.  
Suite 895  
Dallas, TX 75204  
214.520.8878  
bgoarchitects.com

DATE  
08-05-11

PROJECT  
11129

SHEET NUMBER

**E-3.2D**

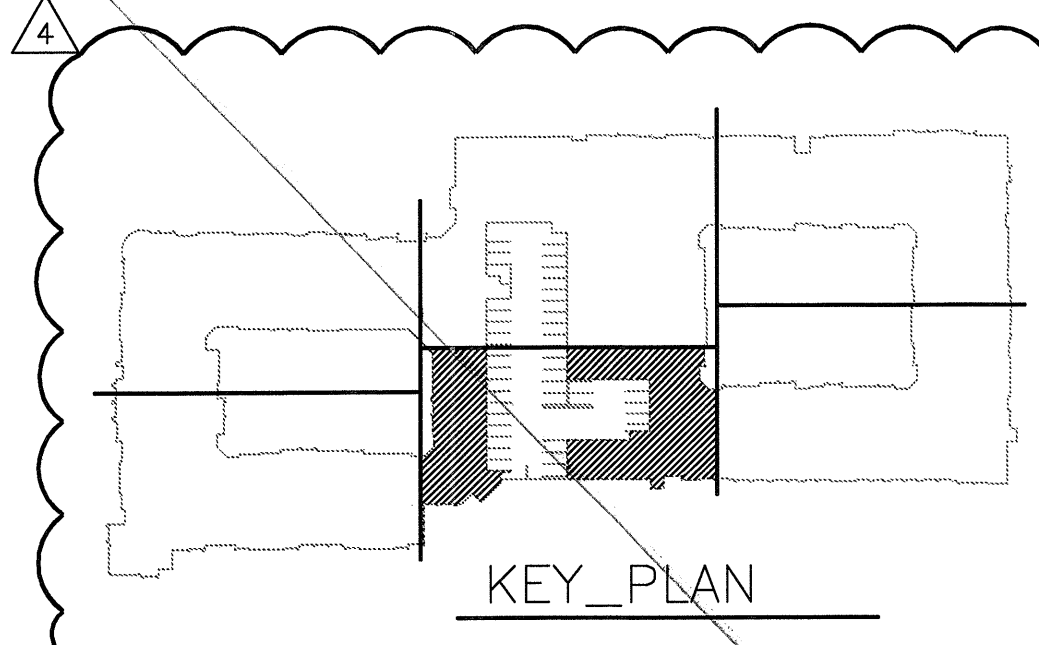

**JSE** Jordan & Skala Engineers  
14240 Midway Road, Suite 350  
Dallas, TX 75244-1138  
V: (469) 383-1616 F: (469) 383-1615  
Project Number - 113-0355 Texas Firm Registration # F-4990  
Drawn By: MJ Checked By: RAD