


REVISIONS	
1	9-2-2011 DESIGN REVISIONS
2	9-13-2011 ANSI/FHA COMMENTS
3	9-23-2011 DESIGN REVISIONS
4	10-17-2011 CONSTRUCTION ISSUE


KELLER SPRINGS LOFTS
LOFT APARTMENTS IN ADDISON, TEXAS

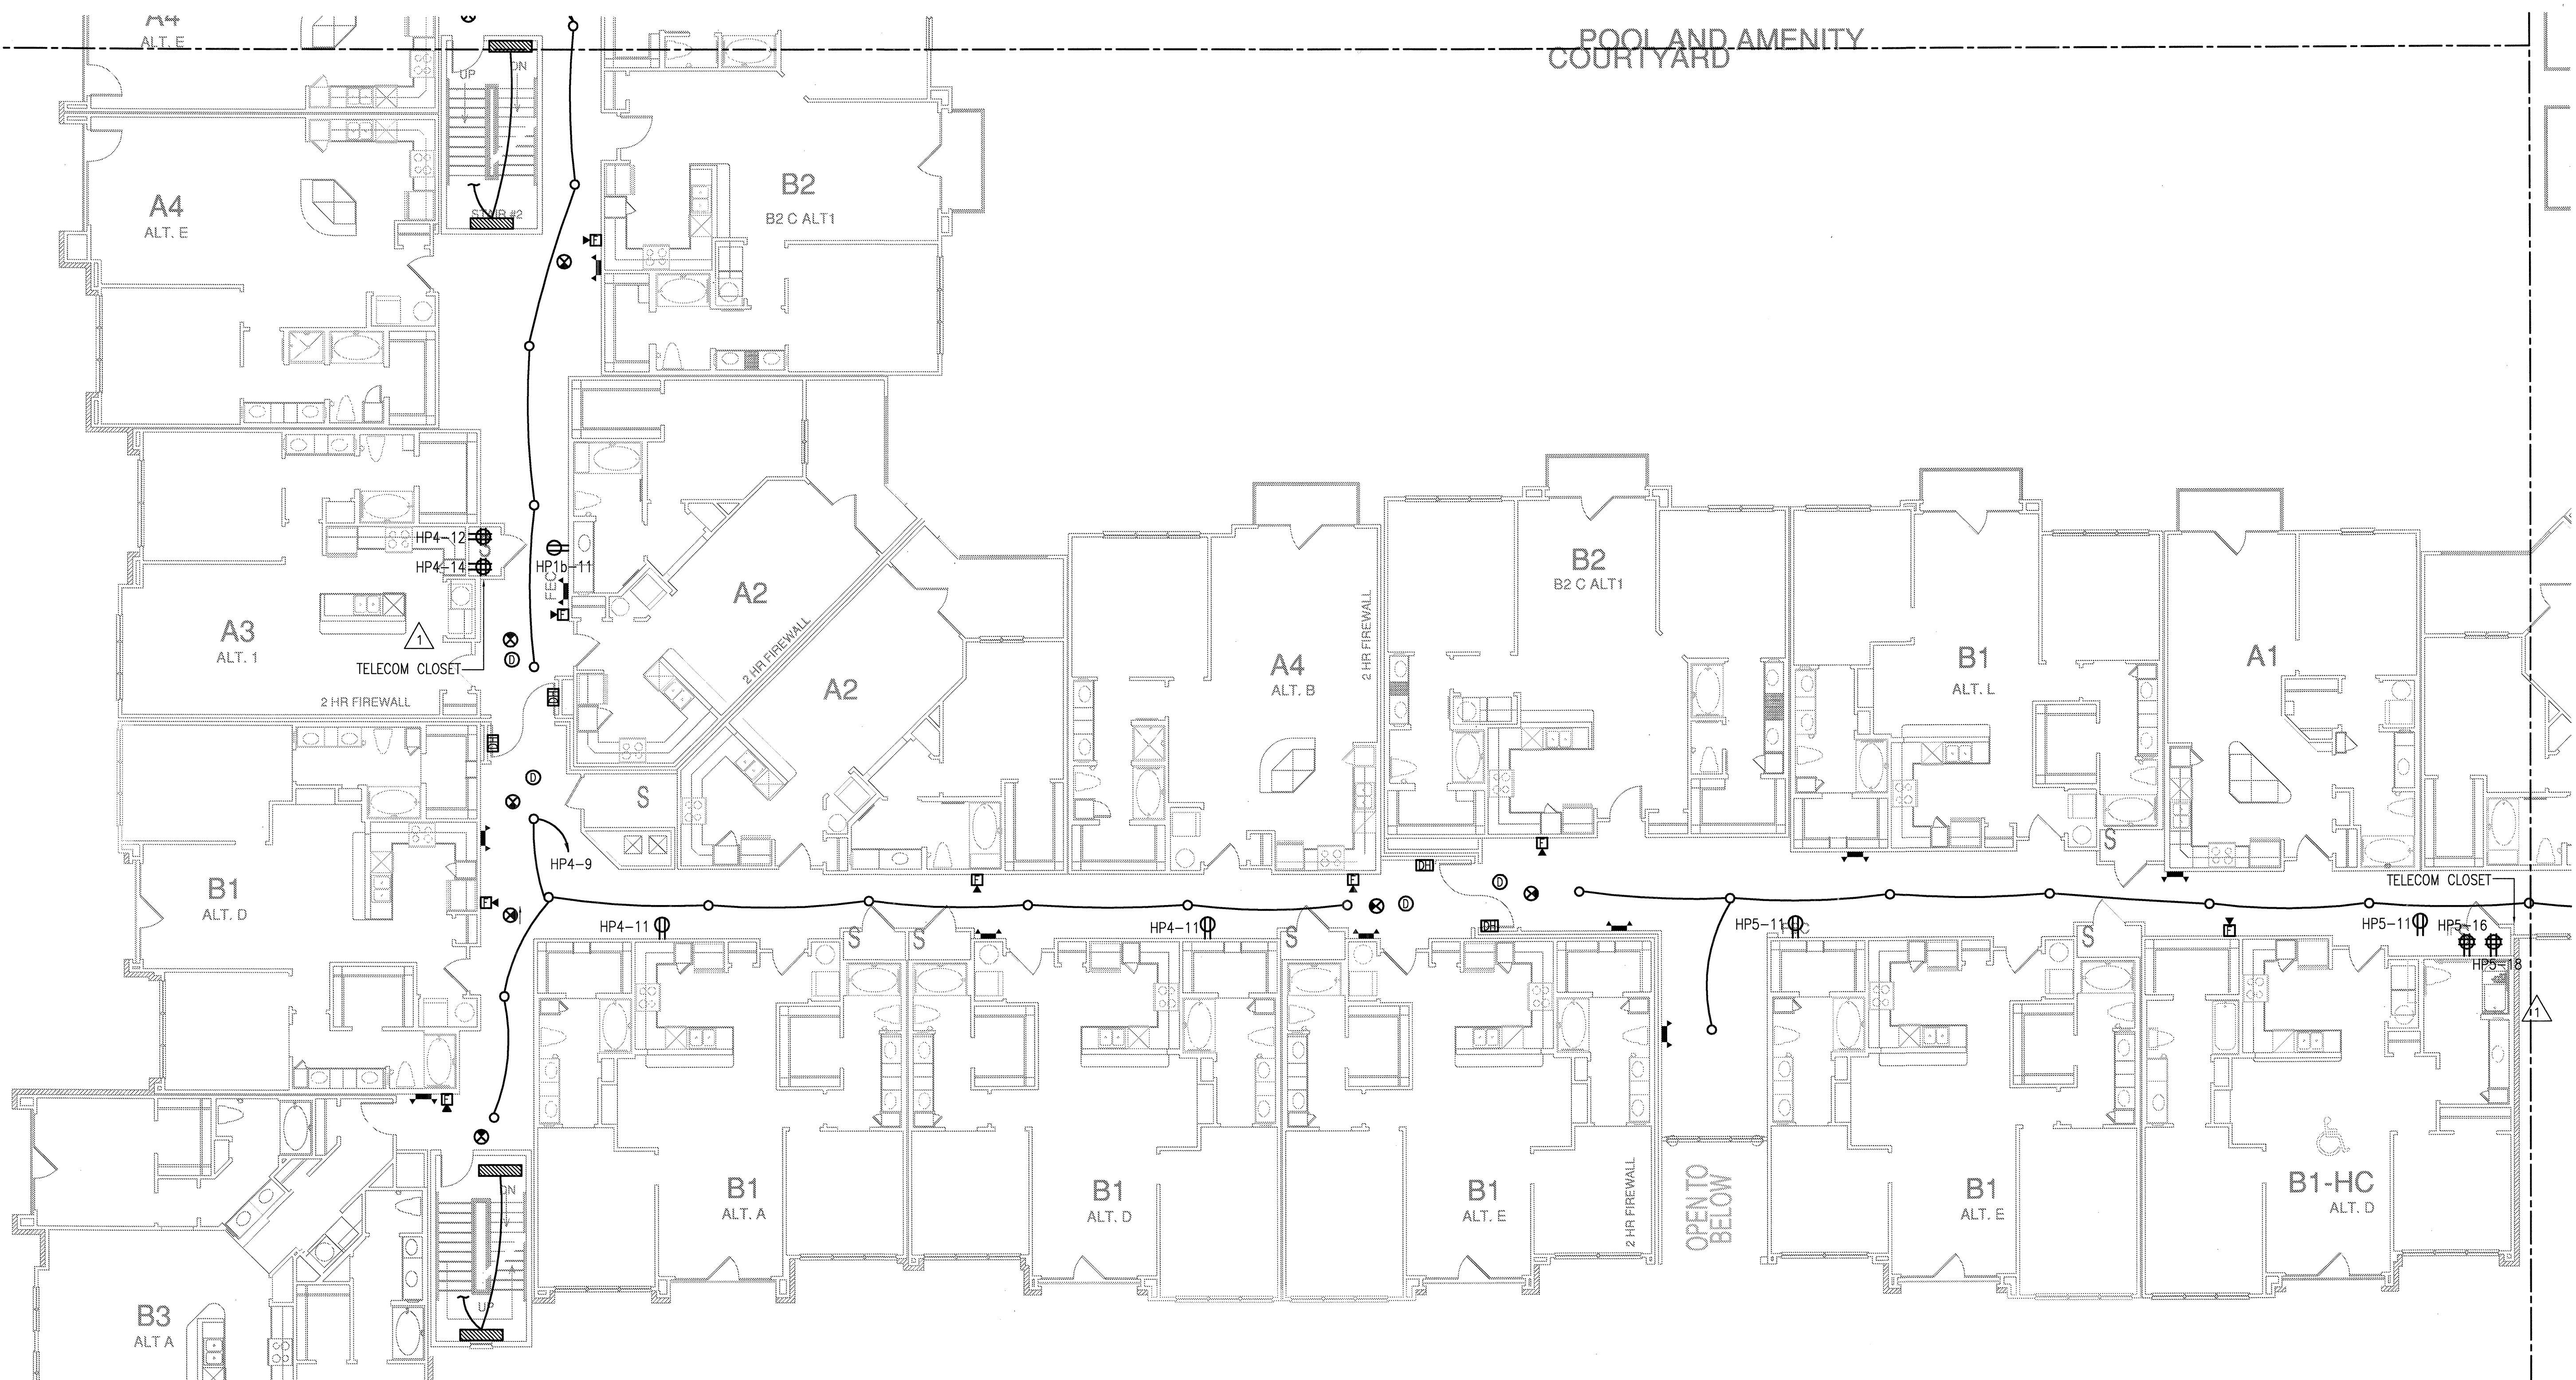

GENERAL NOTES:

G-1 U.N.O., ALL LIGHTING FIXTURES SHALL BE TYPE 'B'.

G-2 ALL EMERGENCY LIGHTS (E.L.) SHALL BE CONNECTED TO THE UNSWITCHED PHASE CONDUCTOR OF THE CIRCUIT SERVING THE RESPECTIVE AREA.

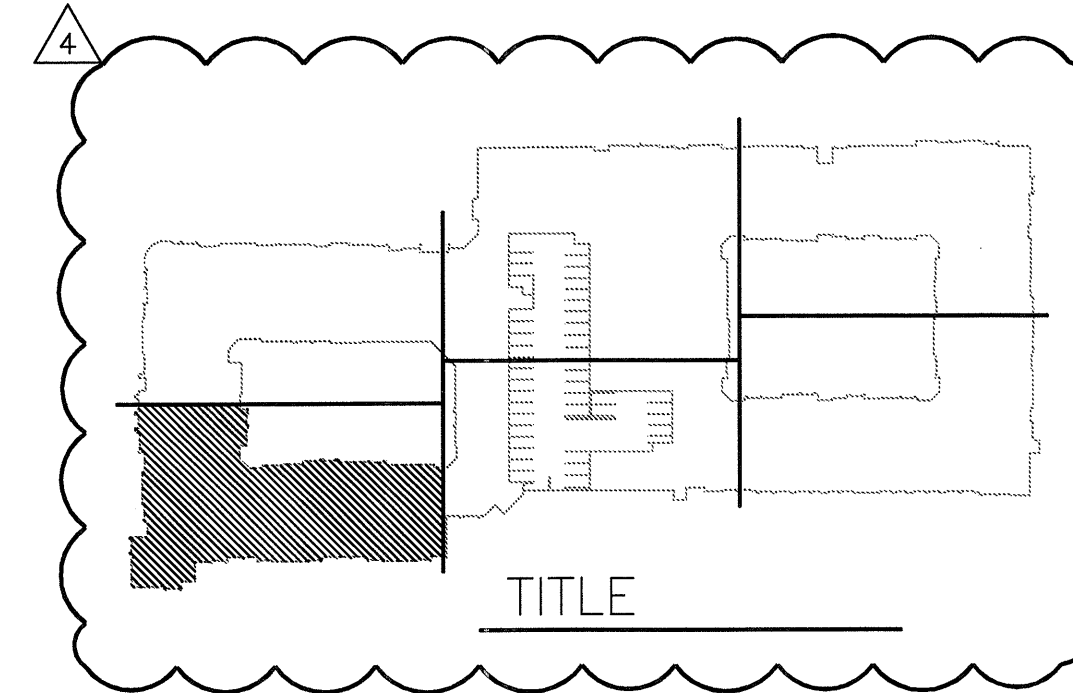

BGO
architects
4144 N. Central Expy.
Suite 855
Dallas, TX 75204
214.520.8878
bgoarchitects.com

DATE
08-05-11

PROJECT
11129

SHEET NUMBER

E-3.3B

1 DIVISION 'B' THIRD FLOOR PLAN
SCALE: 1/8" = 1'-0"

JSE Jordan & Skala Engineers
14240 Midway Road, Suite 350
Dallas, TX 75244-5138
P: (469) 385-1616, F: (469) 385-7613
Project Number - 113-0355 Texas Firm Registration # F-4990
Drawn By: MJ Checked By: RAD