


GENERAL NOTES:

- G-1 U.N.O., ALL LIGHTING FIXTURES SHALL BE TYPE 'B'.
- G-2 ALL EMERGENCY LIGHTS (E) SHALL BE CONNECTED TO THE UNSWITCHED PHASE CONDUCTOR OF THE CIRCUIT SERVING THE RESPECTIVE AREA.

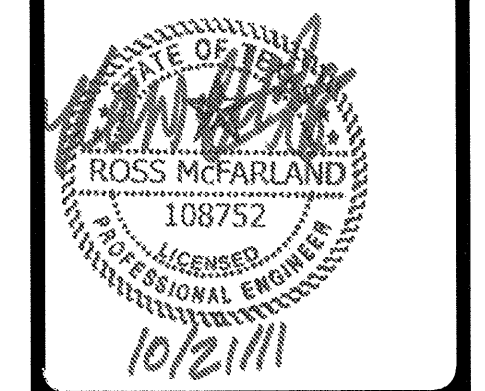

REVISIONS	
1	9-2-2011 DESIGN REVISIONS
2	9-13-2011 ANS/FHA COMMENTS
3	9-23-2011 DESIGN REVISIONS
4	10-17-2011 CONSTRUCTION ISSUE


KELLER SPRINGS LOFTS
LOFT APARTMENTS IN ADDISON, TEXAS

BGO architects
4144 N. Central Expy.
Suite 855
Dallas, TX 75204
214.520.8878
bgoarchitects.com

DATE
08-05-11

PROJECT
11129

SHEET NUMBER
E-3.3D

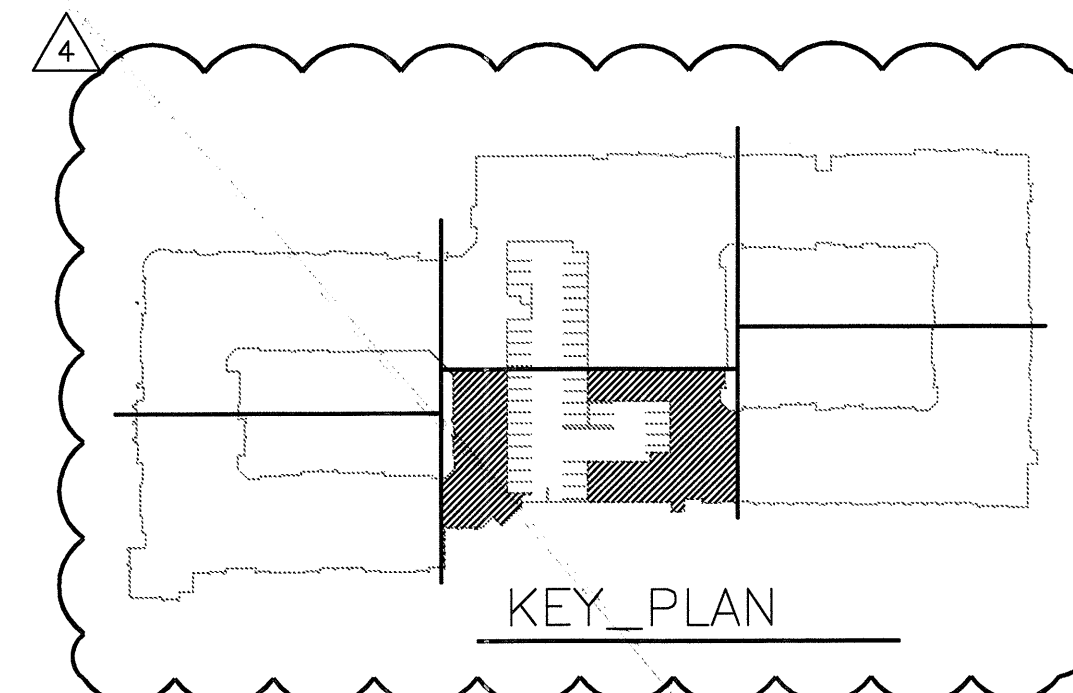

JSE Jordan & Skala Engineers
14210 Midway Road, Suite 350
Dallas, TX 75244-0139
Project Number - 113-0355 Texas Firm Registration # F-4990
Drawn By: MJ Checked By: RAD

1 DIVISION 'D' THIRD FLOOR PLAN
SCALE: 1/8" = 1'-0"