



POOL AND AMENITY

GENERAL NOTES

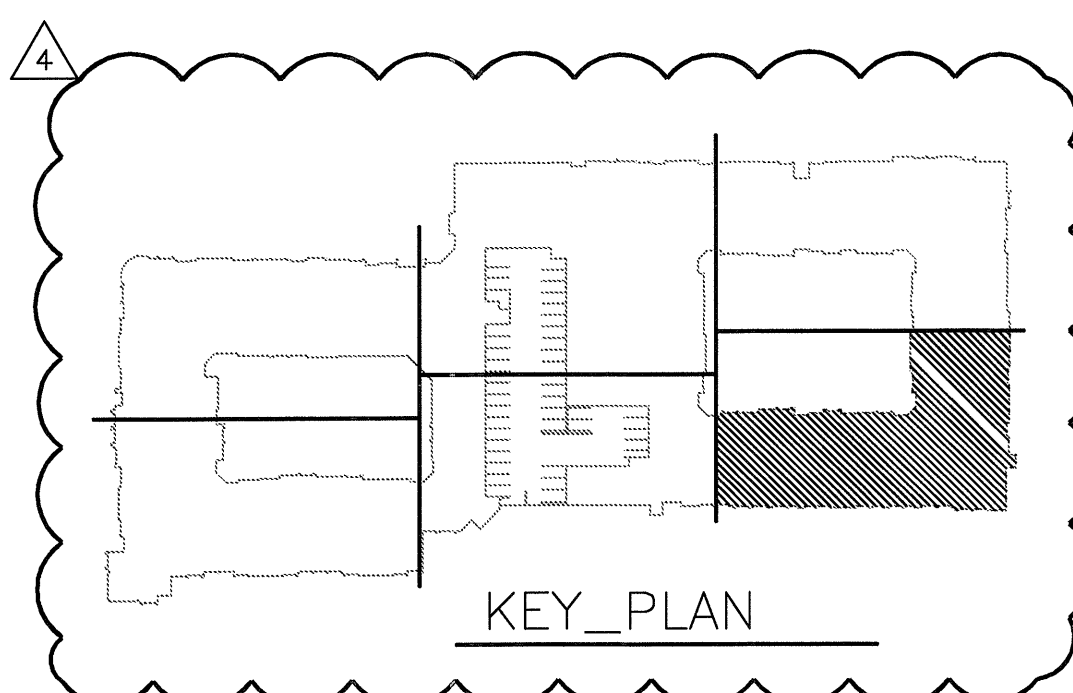

1 DIVISION 'F' THIRD FLOOR PLAN
SCALE: 1/8" = 1'-0"

JSE Jordan & Skala Engineers
14200 Midway Blvd., Suite 310
Dallas, TX 75244-5138
Project Number - 113-0355 Texas Firm Registration # F-4990
Drawn By: MJ Checked By: RAD

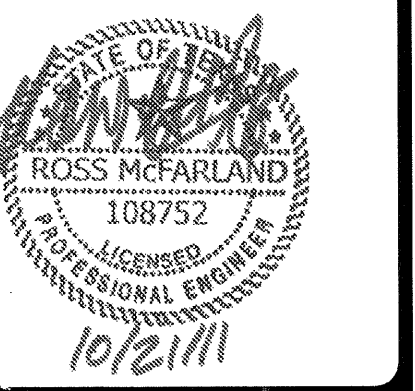

REVISIONS

1	9-2-2011	DESIGN REVISIONS
2	9-13-2011	ANSI/FHA COMMENTS
3	9-23-2011	DESIGN REVISIONS
4	10-17-2011	CONSTRUCTION ISSUE

KELLER SPRINGS LOFTS
LOFT APARTMENTS IN ADDISON, TEXAS

BGO architects
4144 N. Central Expy.
Suite 855
Dallas, TX 75204
214.520.8878
bgoarchitects.com

DATE
08-05-11

PROJECT
11129

SHEET NUMBER

E-3.3F