


**GENERAL NOTES:**


- G-1 U.N.O., ALL LIGHTING FIXTURES SHALL BE TYPE 'B'.
- G-2 ALL EMERGENCY LIGHTS (E) SHALL BE CONNECTED TO THE UNSWITCHED PHASE CONDUCTOR OF THE CIRCUIT SERVING THE RESPECTIVE AREA.
- G-3 GARAGE LIGHT FIXTURE LAYOUT SHALL BE THE SAME ON LEVEL 5. FIXTURES WITH \$ NEXT TO FIXTURE SHALL BE DELETED FROM LEVEL 6.

**KEY NOTES:**

- (1) PROVIDE J-BOX FOR FIRE SENTINEL RELEASE DEVICE TO LOWER DOOR.

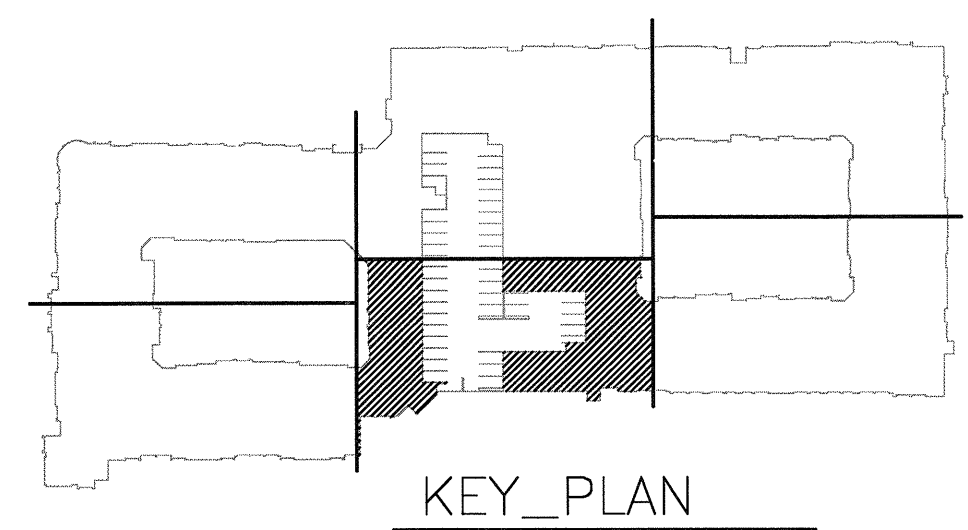

1 DIVISION 'D' FOURTH FLOOR PLAN  
SCALE: 1/8" = 1'-0"

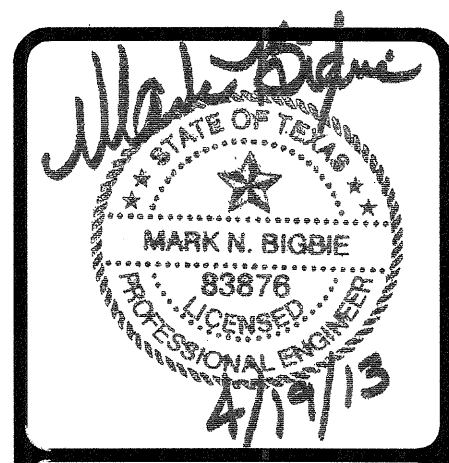

| REVISIONS |                                 |
|-----------|---------------------------------|
| 1         | 9-2-2011 DESIGN REVISIONS       |
| 2         | 9-13-2011 ANS/FHA COMMENTS      |
| 3         | 9-23-2011 DESIGN REVISIONS      |
| 4         | 10-17-2011 CONSTRUCTION ISSUE   |
| 5         | 12-21-2011 DESIGN REVISIONS     |
| 6         | 1-17-2012 DESIGN REVISIONS      |
| 7         | 2-15-2012 TRANSFORMER REVISIONS |
| 8         | 3-27-2012 CLUBHOUSE REVISIONS   |
| 9         | 4-17-2012 COORDINATION          |

**KELLER SPRINGS LOFTS**  
LOFT APARTMENTS IN ADDISON, TEXAS

|    |                             |
|----|-----------------------------|
| 10 | 5-15-2012 COORDINATION      |
| 11 | 5-30-2012 SITE COORDINATION |
| 12 | 6-01-12 LIGHTING REVISIONS  |
| 13 | 6-29-12 SITE COORDINATION   |
| 14 | 9-05-12 CLUB REVISIONS      |
| 15 | 4-19-13 EL. LOBBY REVISIONS |

**BGO architects**  
4144 N. Central Expy. Suite 855  
Dallas, TX 75204  
214.520.8878  
bgoarchitects.com

DATE  
08-05-11

PROJECT  
11129

SHEET NUMBER

**E-3.4D**

**JSE** Jordan & Skala Engineers  
17855 N. Dallas Parkway, Suite 320  
Dallas, TX 75287-6637  
V: (469) 385-1616 F: (469) 385-1615  
Project Number - 113-0355 Texas Firm Registration # F-4990  
Drawn By: MJ Checked By: RAD