



REVISIONS

1	9-2-2011	DESIGN REVISIONS
2	9-13-2011	ANSI/FHA COMMENTS
3	9-23-2011	DESIGN REVISIONS
4	10-17-2011	CONSTRUCTION ISSUE

KELLER SPRINGS LOFTS

LOFT APARTMENTS IN ADDISON, TEXAS




4144 N. Central Expy. Suite 855 Dallas, TX 75204 214.520.8878 bgoarchitects.com

DATE 08-05-11

PROJECT 11129

SHEET NUMBER M-3.5F ROOF PLAN DIVISION F MECHANICAL

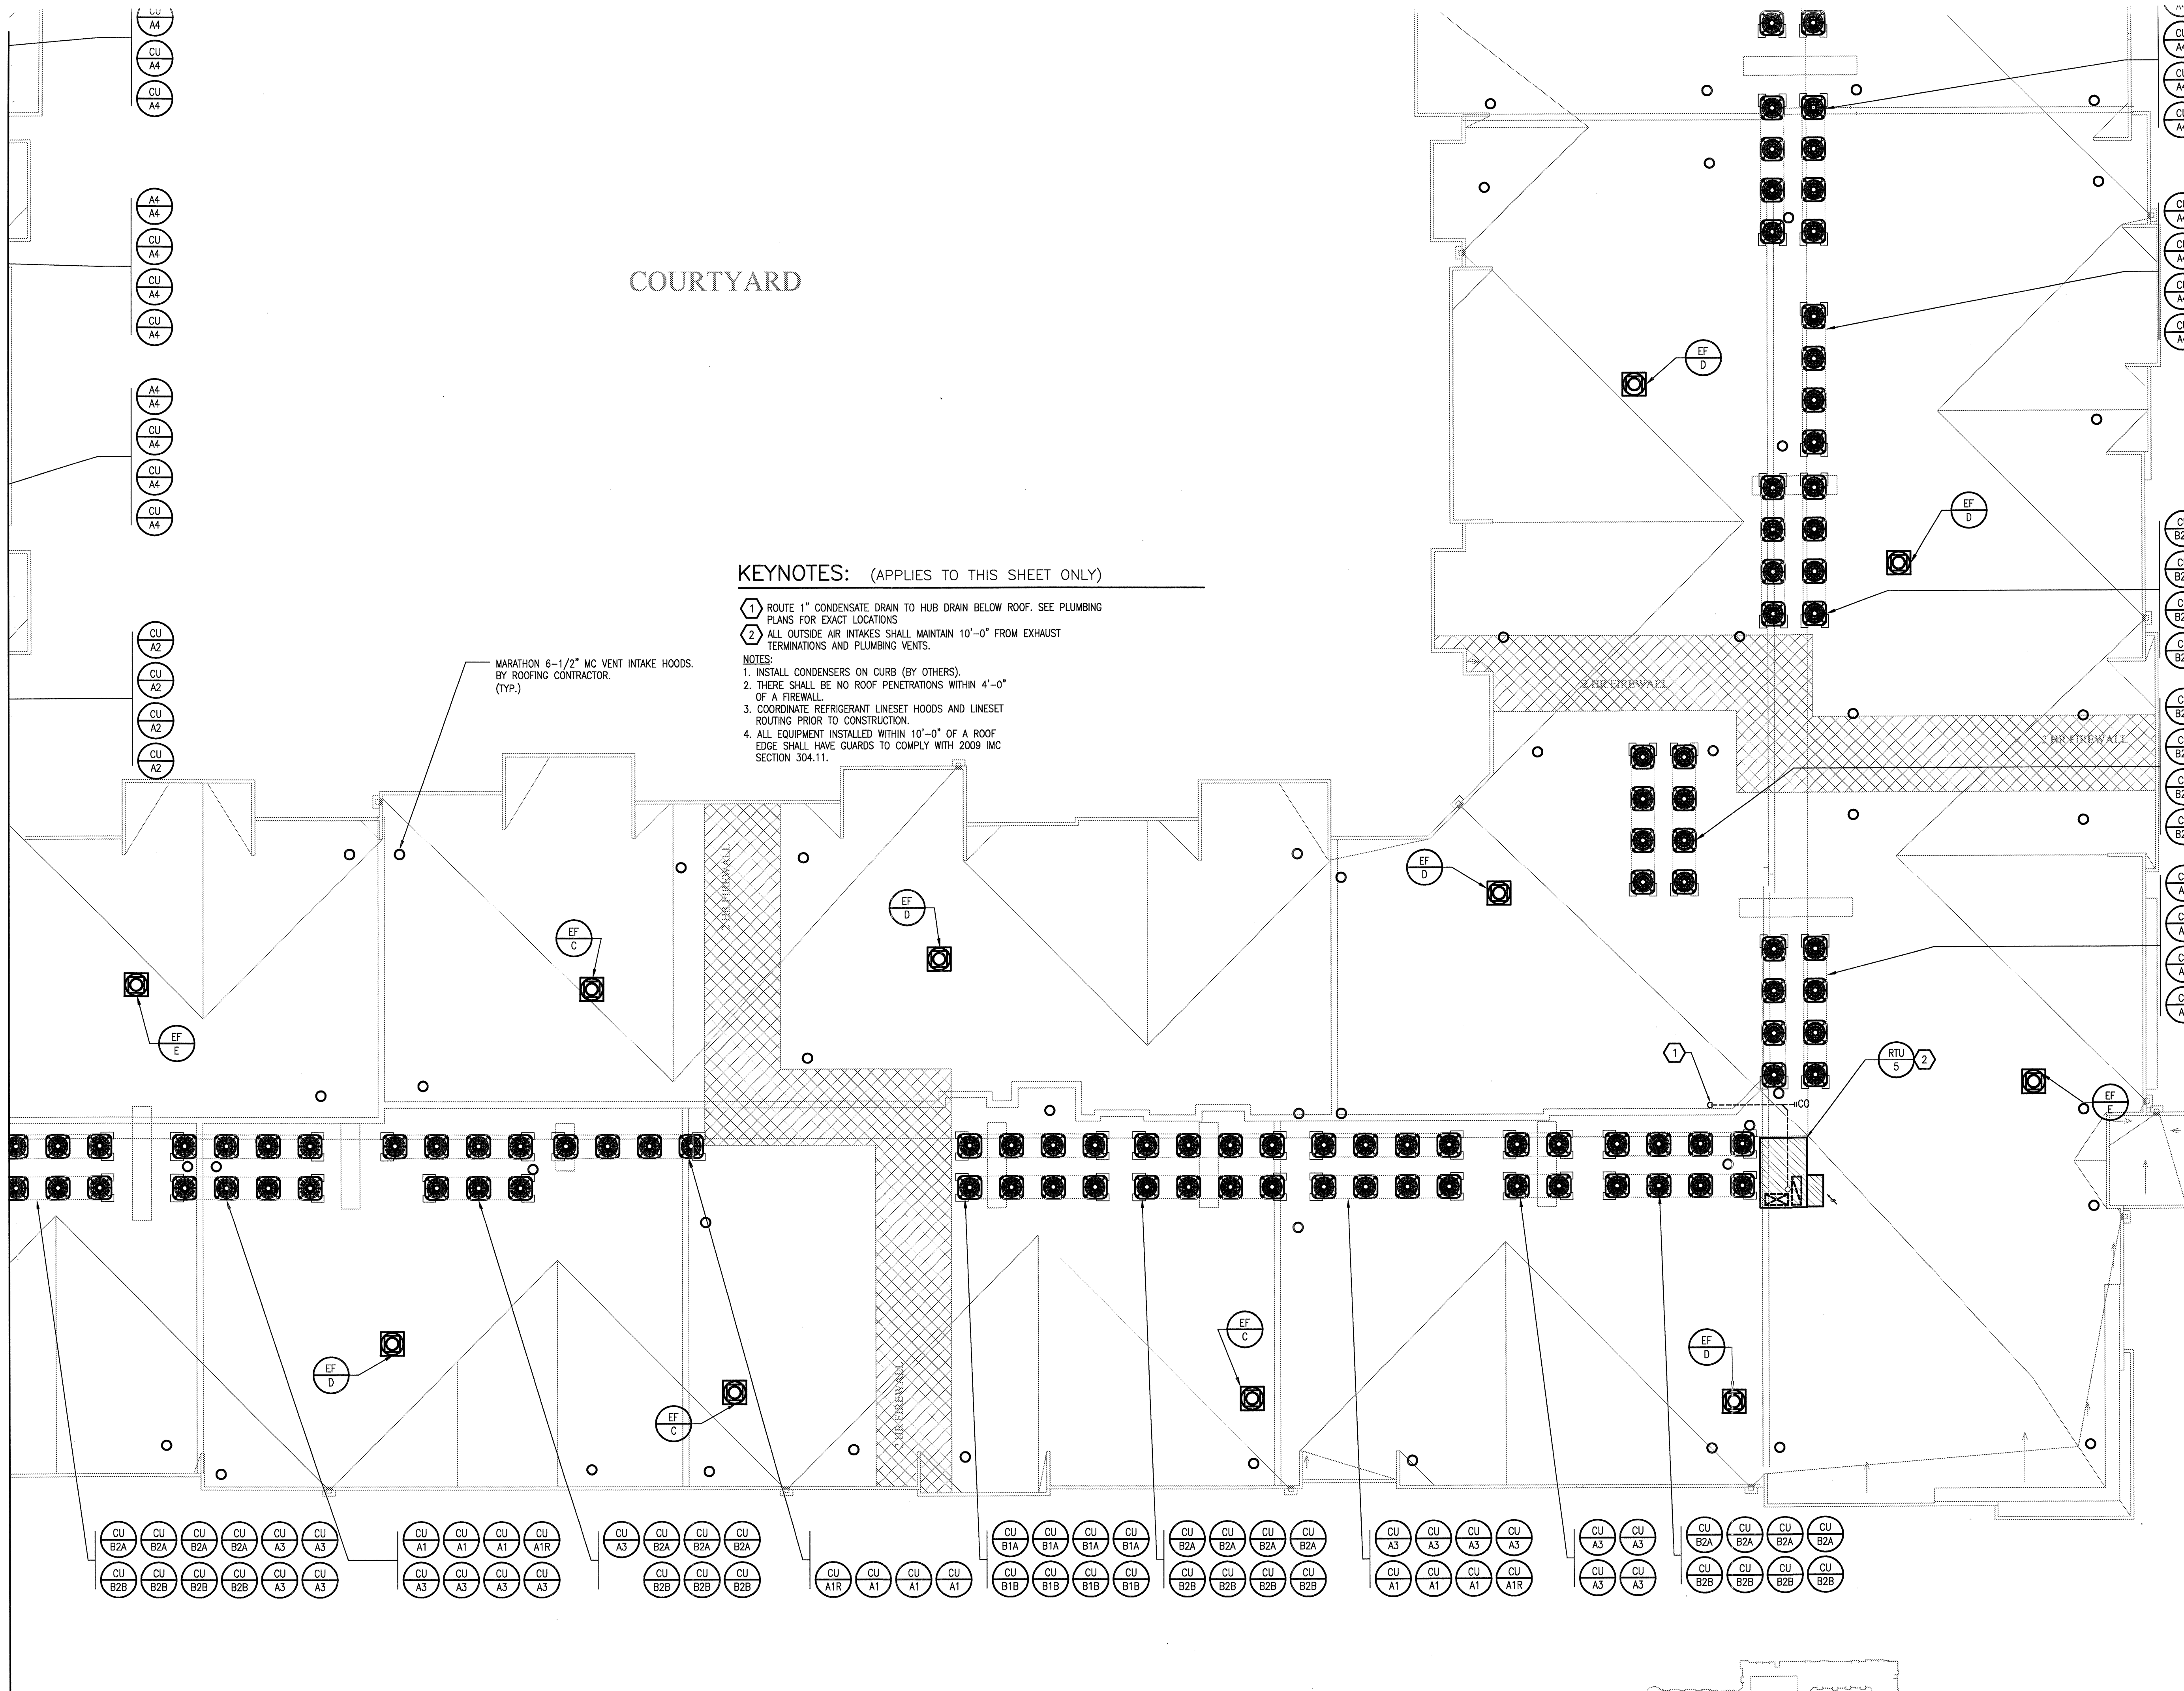

KEYNOTES: (APPLIES TO THIS SHEET ONLY)

1. ROUTE 1" CONDENSATE DRAIN TO HUB DRAIN BELOW ROOF. SEE PLUMBING PLANS FOR EXACT LOCATIONS
 2. ALL OUTSIDE AIR INTAKES SHALL MAINTAIN 10'-0" FROM EXHAUST TERMINATIONS AND PLUMBING VENTS.
- NOTES:
1. INSTALL CONDENSERS ON CURB (BY OTHERS).
 2. THERE SHALL BE NO ROOF PENETRATIONS WITHIN 4'-0" OF A FIREWALL.
 3. COORDINATE REFRIGERANT LINES/ET HOODS AND LINES/ET ROUTING PRIOR TO CONSTRUCTION.
 4. ALL EQUIPMENT INSTALLED WITHIN 10'-0" OF A ROOF EDGE SHALL HAVE GUARDS TO COMPLY WITH 2009 IMC SECTION 304.11.

1 DIVISION 'F' ROOF PLAN SCALE: 1/8" = 1'-0"

