

REVISIONS		
1	9-2-2011	DESIGN REVISIONS
2	9-13-2011	ANSI/FHA COMMENTS
3	9-23-2011	DESIGN REVISIONS
4	10-17-2011	CONSTRUCTION ISSUE
5	12-21-2011	DESIGN REVISIONS
6	1-17-2012	DESIGN REVISIONS
7	2-15-2012	TRANSFORMER REVISIONS
8	3-27-2012	CLUBHOUSE REVISIONS
9	4-17-2012	COORDINATION

KELLER SPRINGS LOFTS
 LOFT APARTMENTS IN ADDISON, TEXAS

10	5-15-2012	COORDINATION
11	5-30-2012	SITE COORDINATION


BGO
architects
 4144 N. Central Expy.
 Suite 855
 Dallas, TX 75204
 214.520.8878
 bgoarchitects.com

DATE
 08-05-11

PROJECT
 11129


SHEET NUMBER

P-3.0C

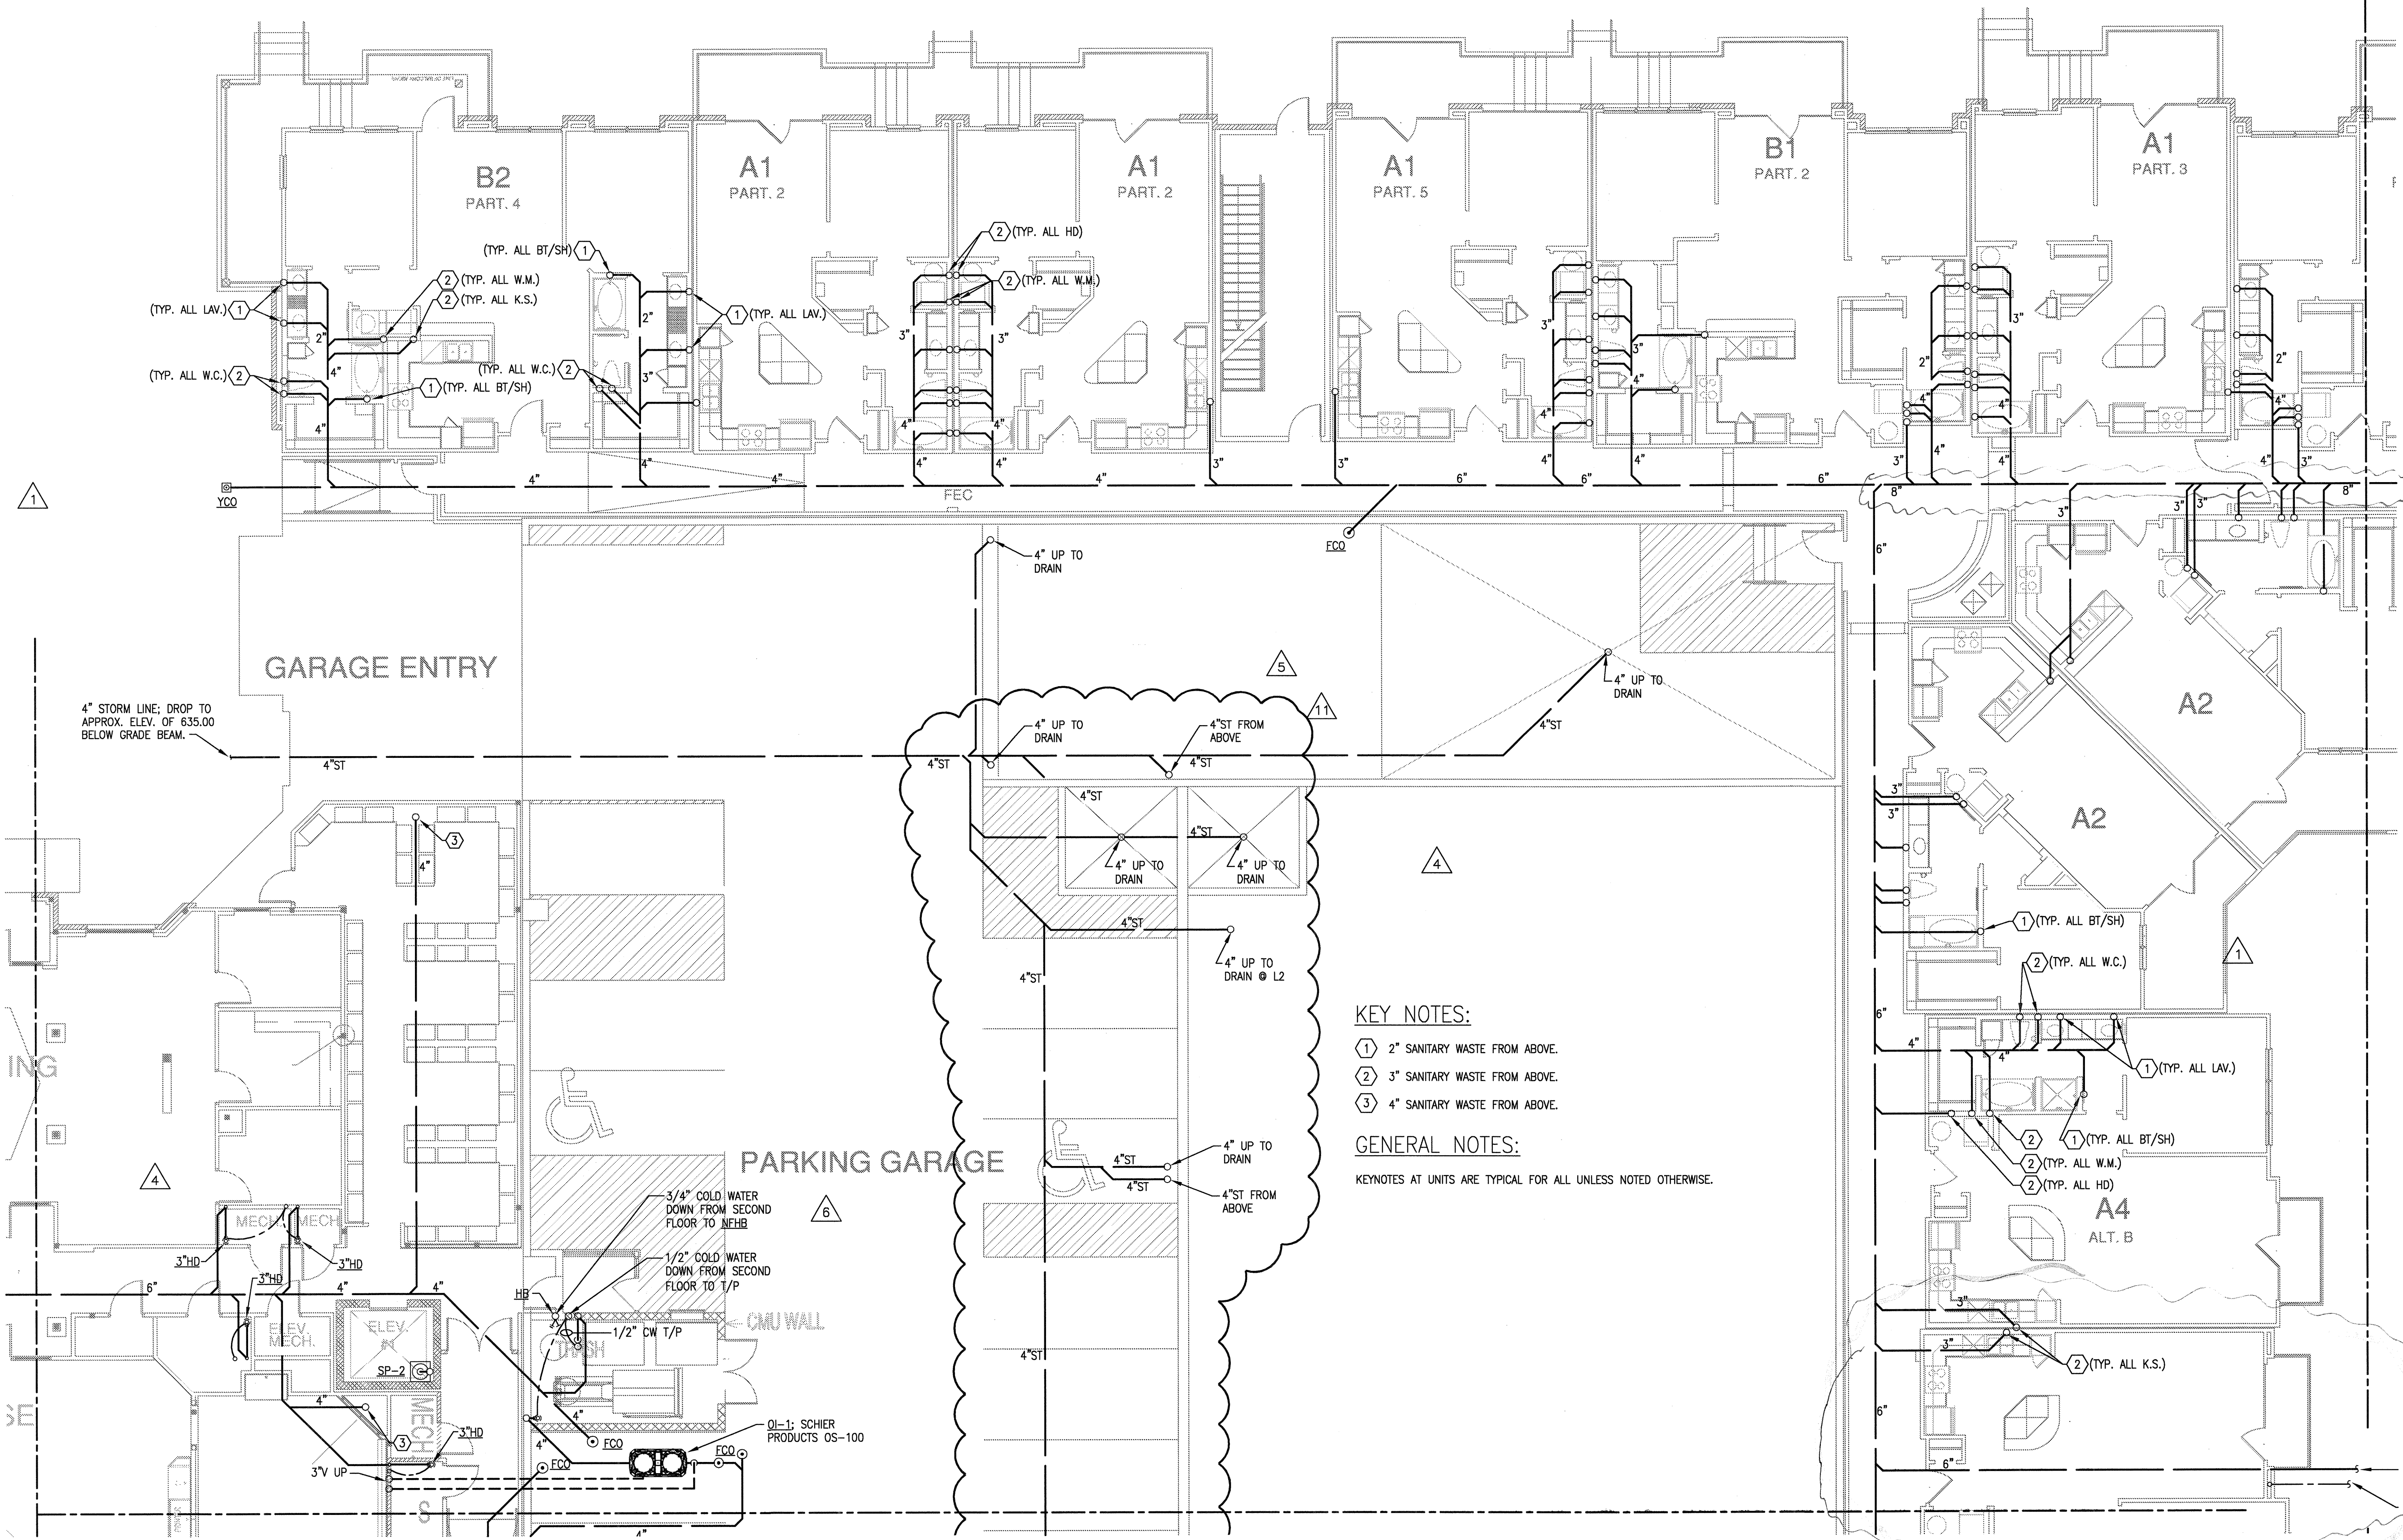

KEY NOTES:
 ① 2" SANITARY WASTE FROM ABOVE.
 ② 3" SANITARY WASTE FROM ABOVE.
 ③ 4" SANITARY WASTE FROM ABOVE.

GENERAL NOTES:
 KEYNOTES AT UNITS ARE TYPICAL FOR ALL UNLESS NOTED OTHERWISE.

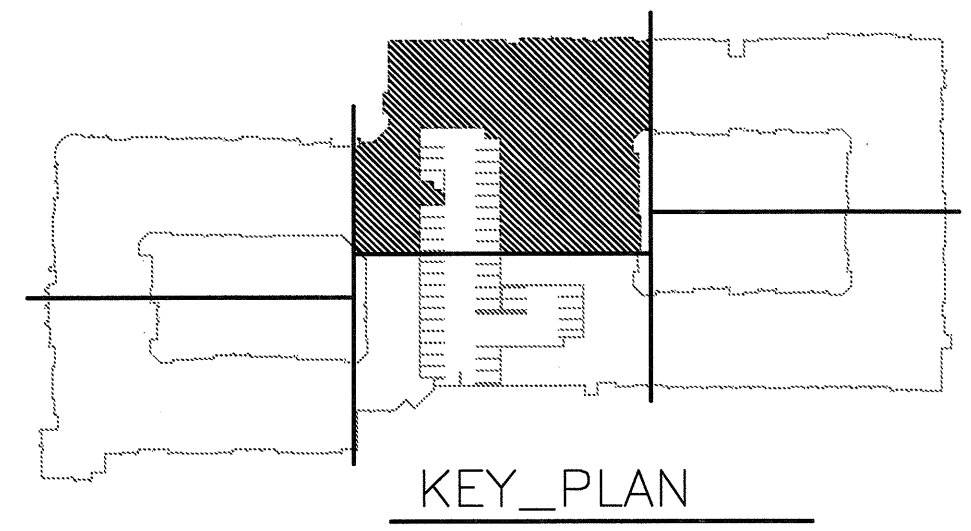

1 DIVISION 'C' UNDERFLOOR PLAN
 SCALE: 1/8" = 1'-0"

USE Jordan & Skala Engineers
 17835 N. Dallas Parkway, Suite 320
 Dallas, TX 75287-4857
 P: 469.385.1616 Web: www.jordanaska.com
 Project Number - 113-0555 Texas Firm Registration # F-4990
 Drawn By: CV Checked By: RC