

REVISIONS		
1	9-2-2011	DESIGN REVISIONS
2	9-13-2011	ANSI/FHA COMMENTS
3	9-23-2011	DESIGN REVISIONS
4	10-17-2011	CONSTRUCTION ISSUE

# KELLER SPRINGS LOFTS

LOFT APARTMENTS IN ADDISON, TEXAS




4144 N. Central Expy.  
Suite 855  
Dallas, TX 75204  
214.520.8878  
bgoarchitects.com

DATE  
08-05-11

PROJECT  
11129

SHEET NUMBER

**P-3.1B**

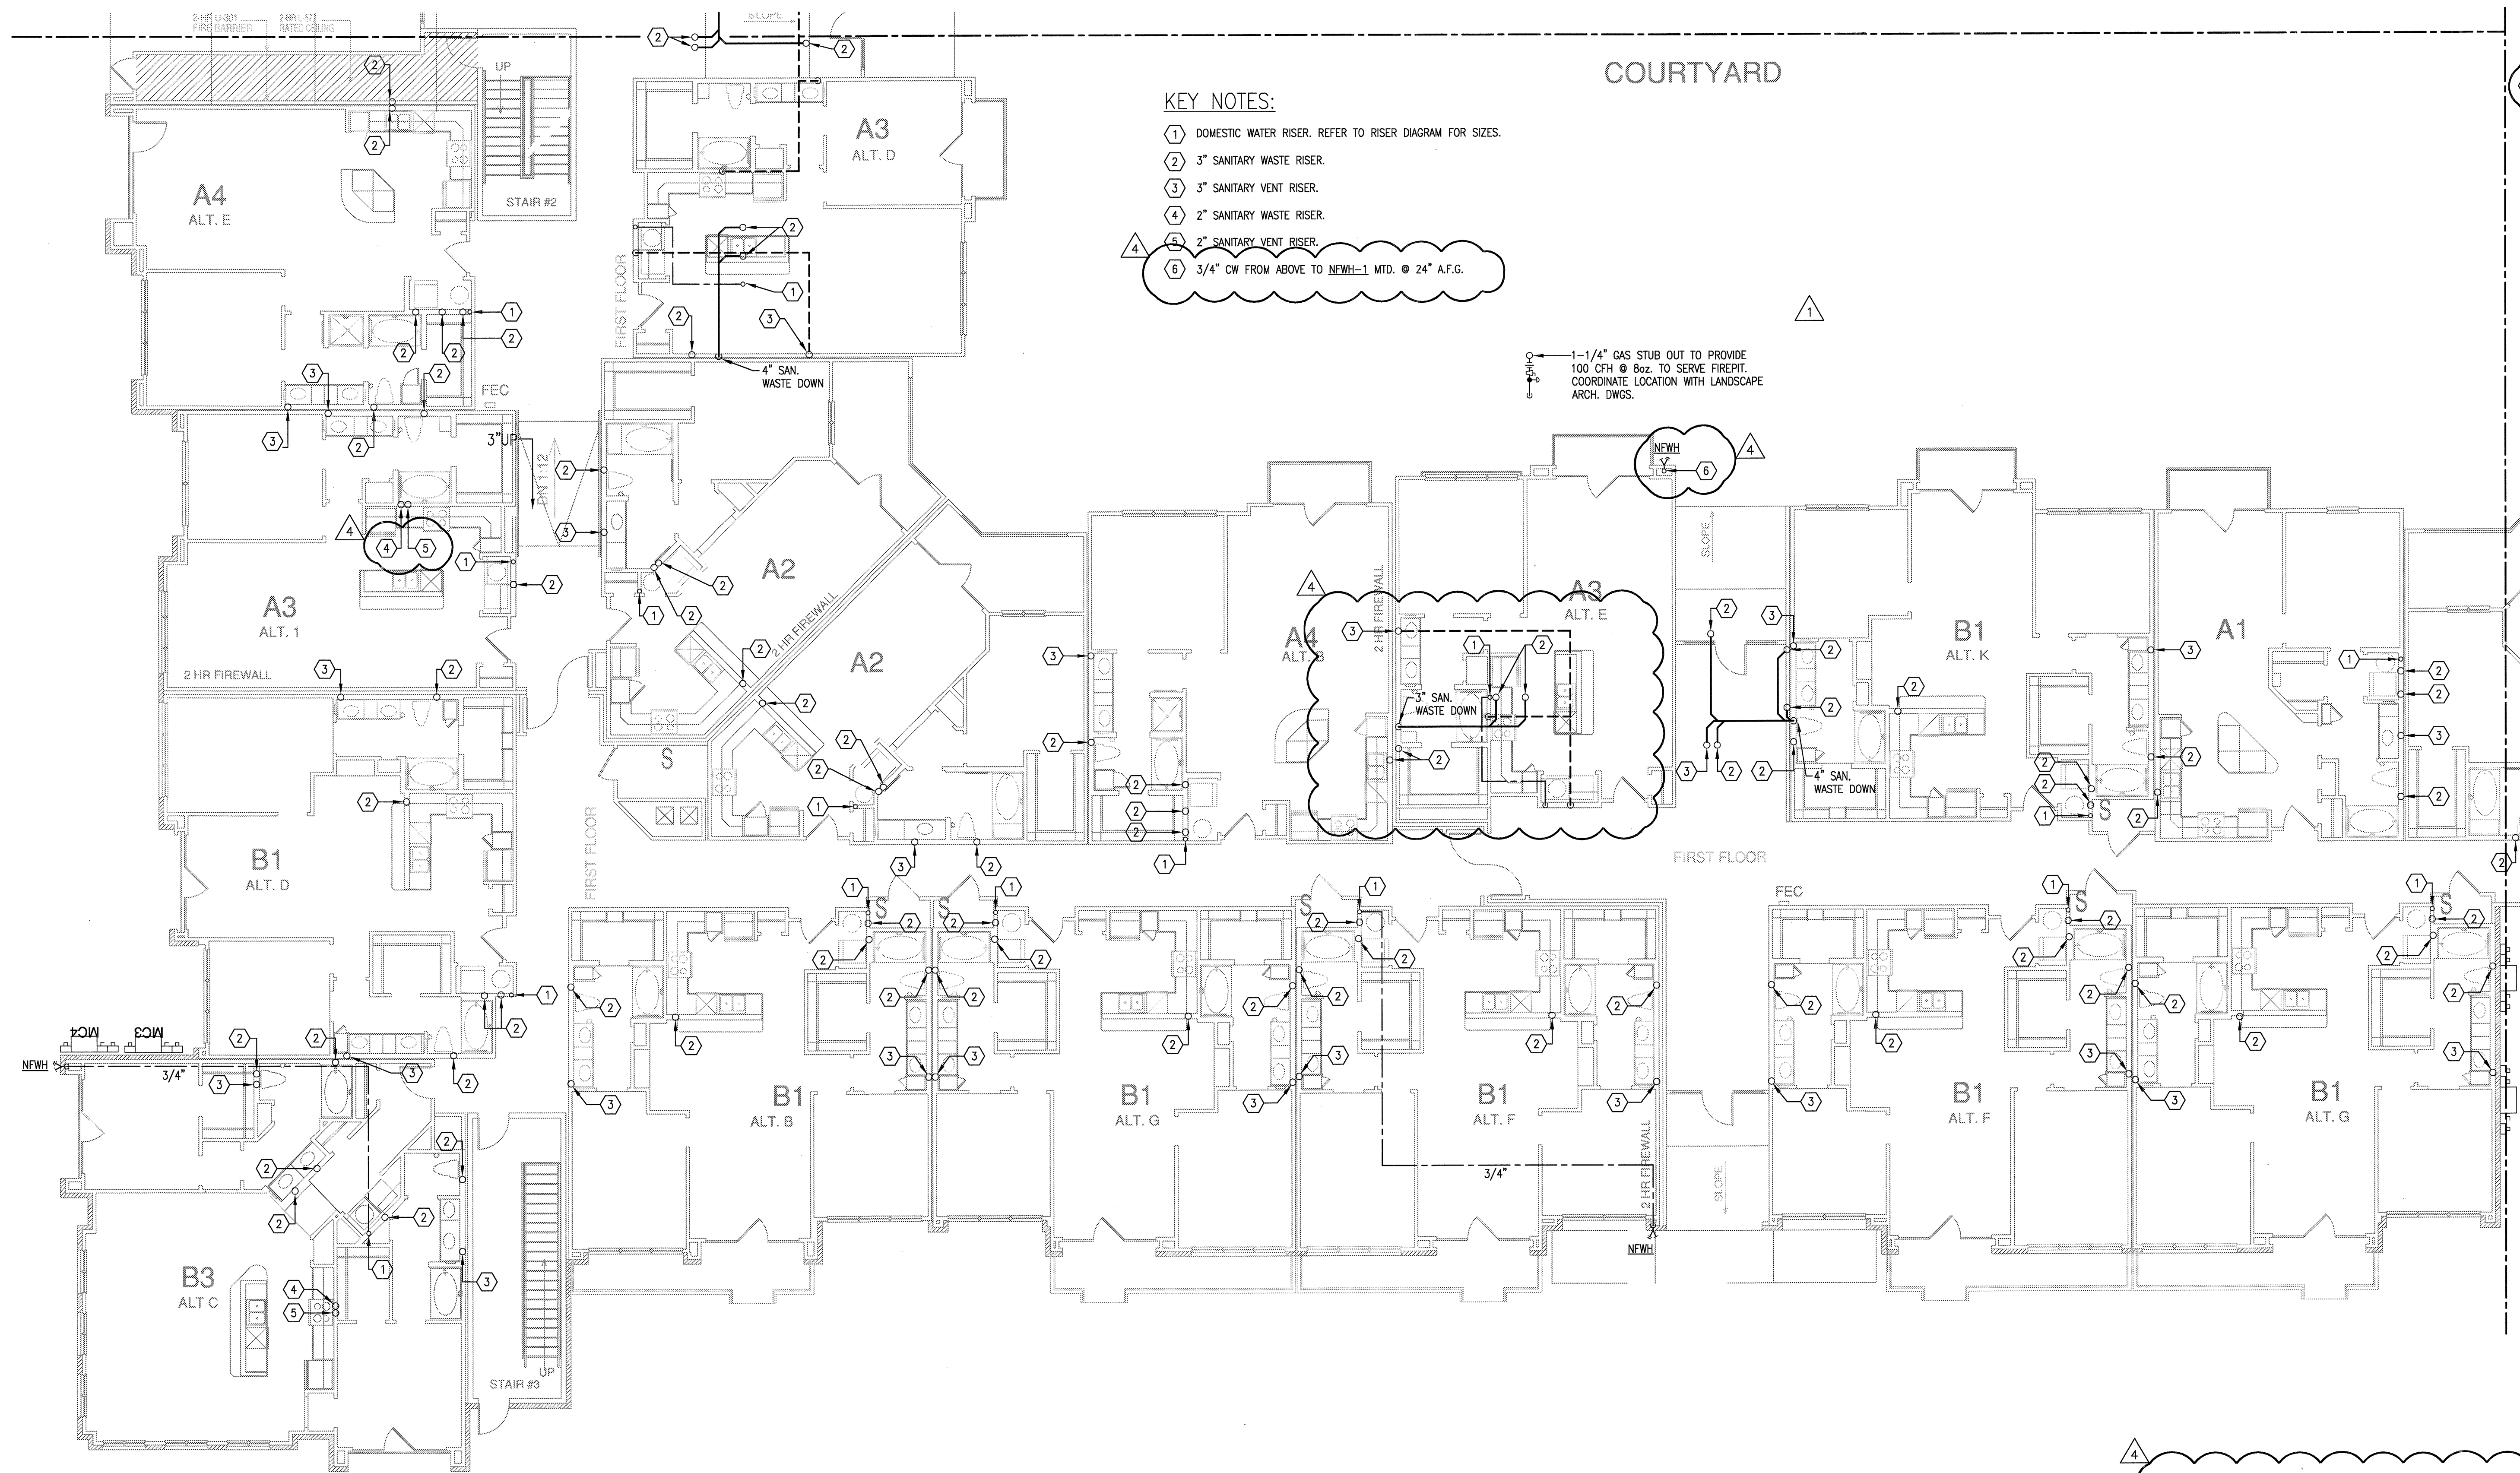

- KEY NOTES:**
- 1 DOMESTIC WATER RISER. REFER TO RISER DIAGRAM FOR SIZES.
  - 2 3" SANITARY WASTE RISER.
  - 3 3" SANITARY VENT RISER.
  - 4 2" SANITARY WASTE RISER.
  - 5 2" SANITARY VENT RISER.
  - 6 3/4" CW FROM ABOVE TO NEWH-1 MTD. @ 24" A.F.G.

1-1/4" GAS STUB OUT TO PROVIDE 100 CFH @ 8oz. TO SERVE FIREPIT. COORDINATE LOCATION WITH LANDSCAPE ARCH. DWGS.

1 DIVISION 'B' FIRST FLOOR PLAN  
SCALE: 1/8" = 1'-0"

**JSE** Jordan & Skala Engineers  
14240 Midway Road, Suite 330  
Dallas, TX 75244-5138  
V: (469) 385-1616 F: (469) 385-1615  
Project Number - 113-0355 Texas Firm Registration # F-4990  
Drawn By: CV Checked By: RC