

REVISIONS		
1	9-2-2011	DESIGN REVISIONS
2	9-13-2011	ANSI/FHA COMMENTS
3	9-23-2011	DESIGN REVISIONS
4	10-17-2011	CONSTRUCTION ISSUE
5	12-21-2011	DESIGN REVISIONS
6	1-17-2012	DESIGN REVISIONS

KELLER SPRINGS LOFTS
 LOFT APARTMENTS IN ADDISON, TEXAS




4144 N. Central Expy.
 Suite 855
 Dallas, TX 75204
 214.520.8878
 bgoarchitects.com

DATE
 08-05-11

PROJECT
 11129

SHEET NUMBER

P-3.1C

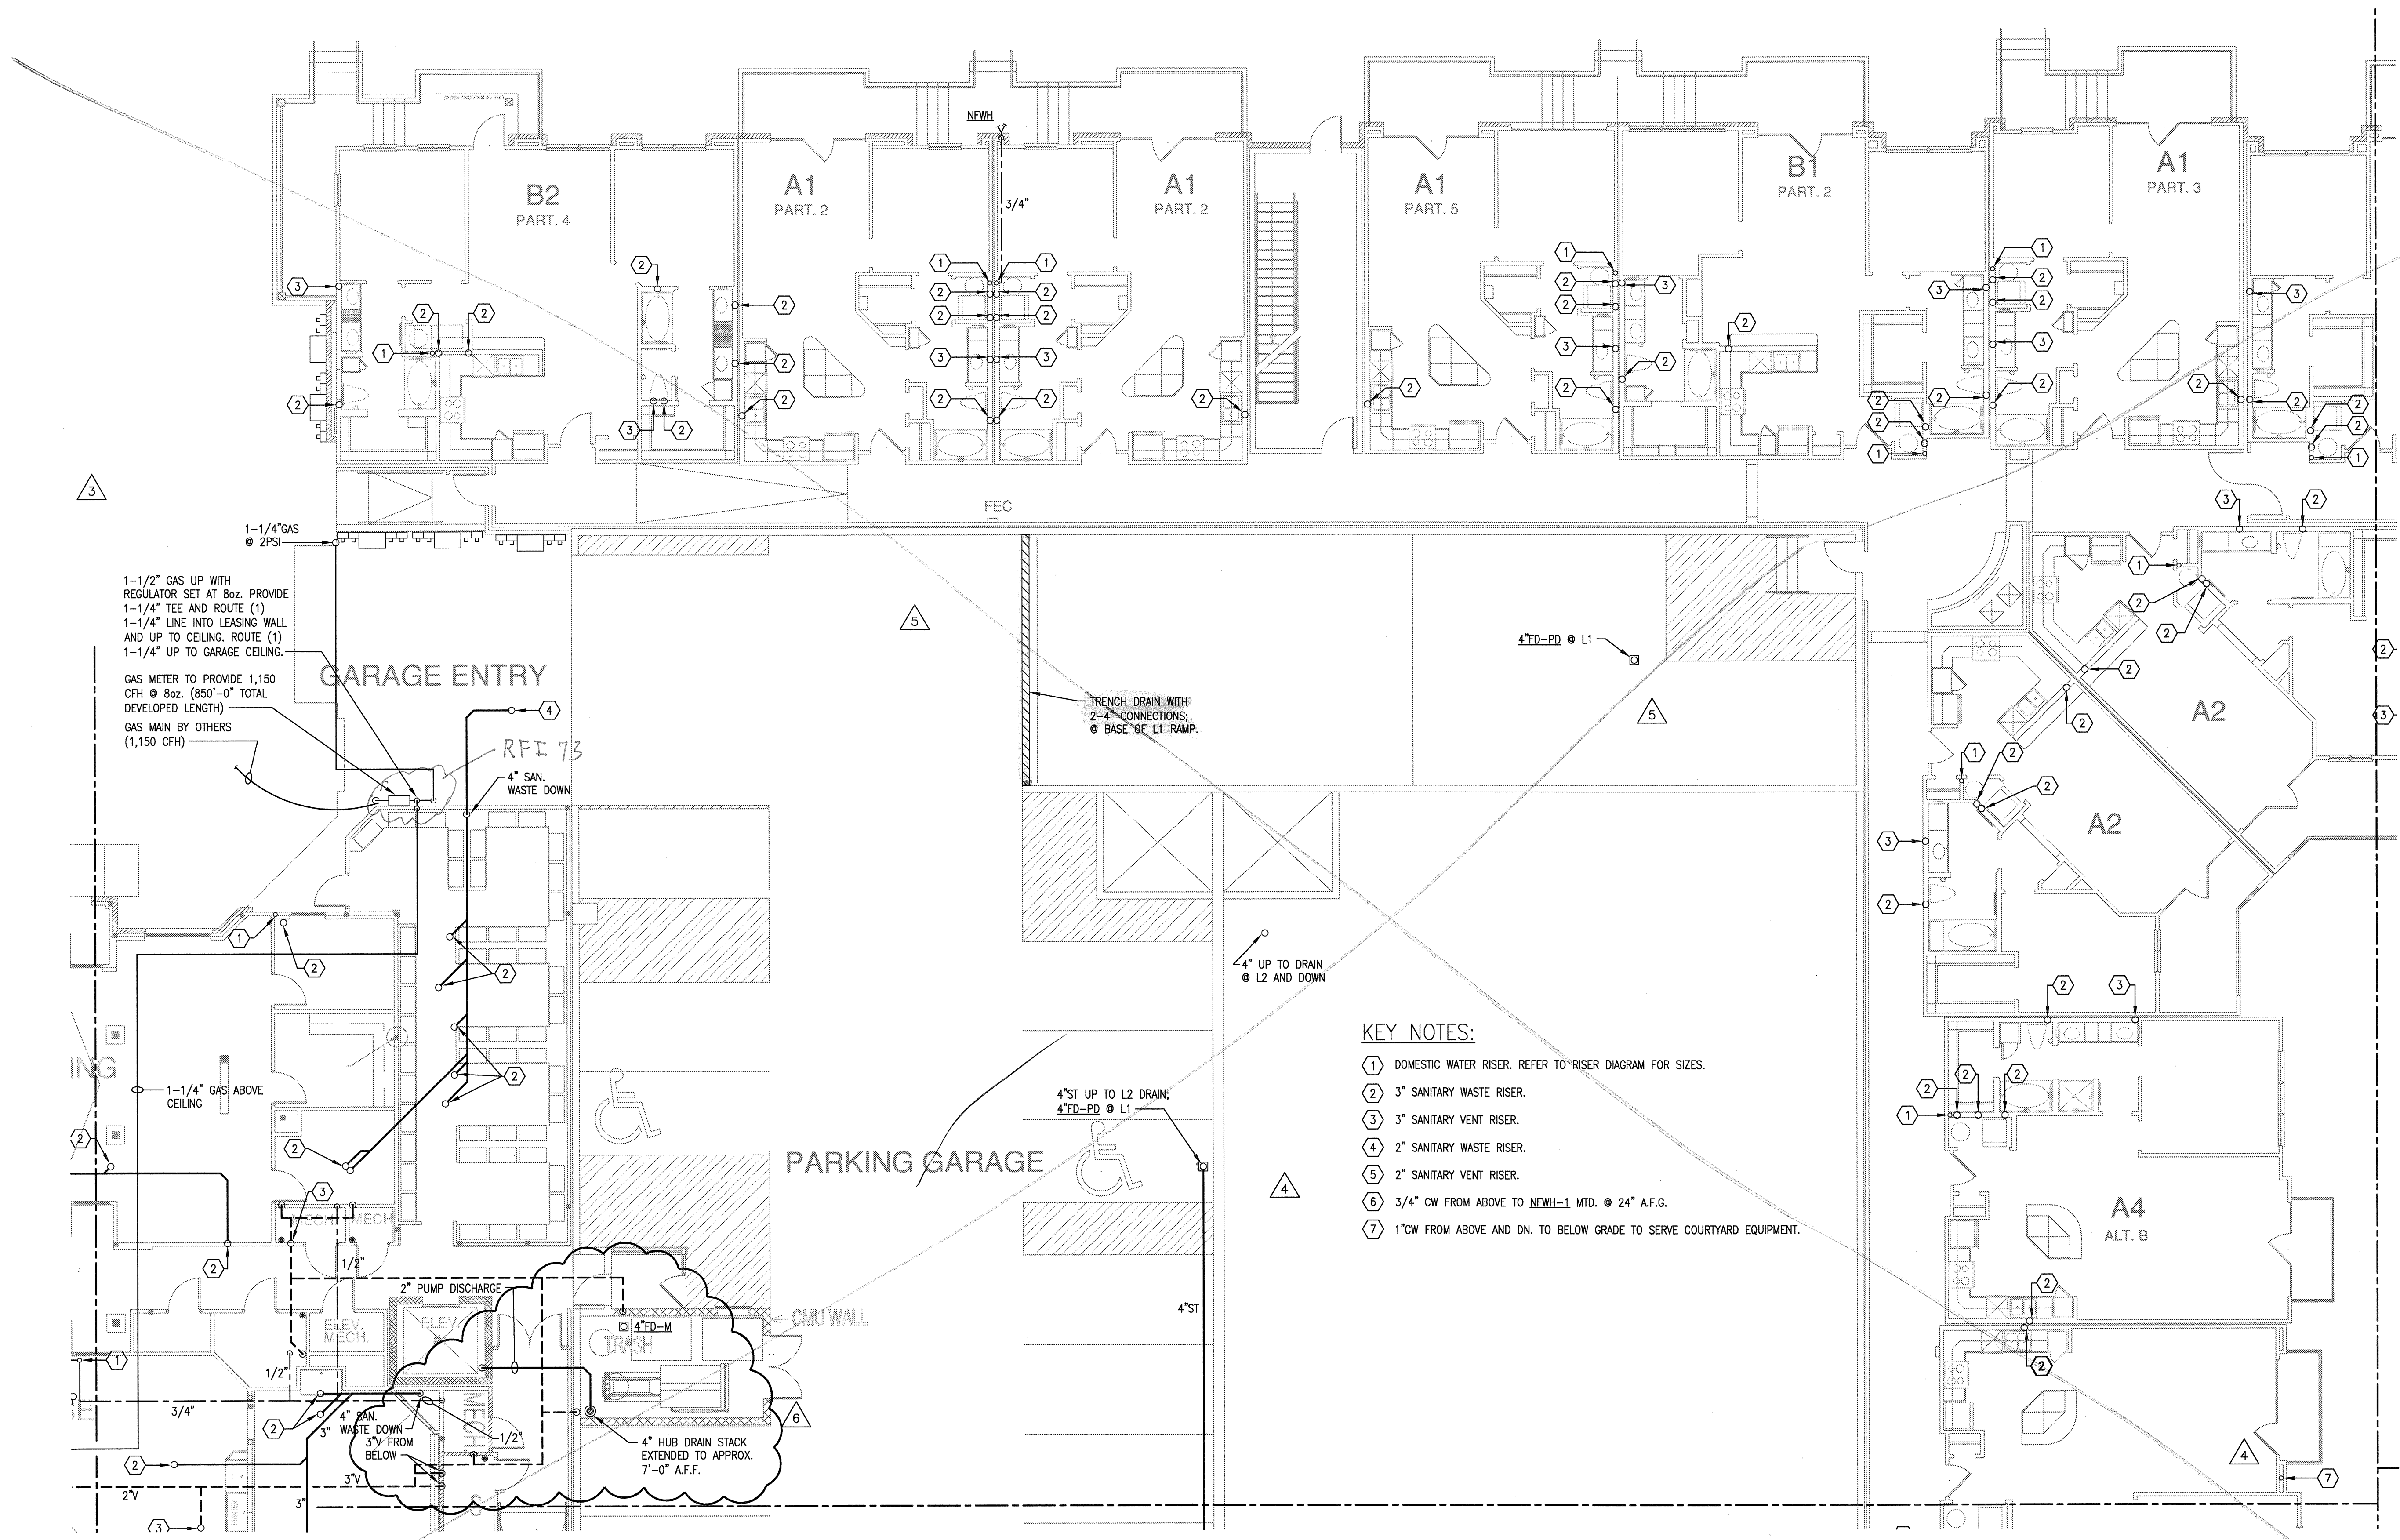

- KEY NOTES:**
- 1 DOMESTIC WATER RISER. REFER TO RISER DIAGRAM FOR SIZES.
 - 2 3" SANITARY WASTE RISER.
 - 3 3" SANITARY VENT RISER.
 - 4 2" SANITARY WASTE RISER.
 - 5 2" SANITARY VENT RISER.
 - 6 3/4" CW FROM ABOVE TO NEWH-1 MTD. @ 24" A.F.G.
 - 7 1" CW FROM ABOVE AND DN. TO BELOW GRADE TO SERVE COURTYARD EQUIPMENT.

1 DIVISION 'C' FIRST FLOOR PLAN
 SCALE: 1/8" = 1'-0"

JSE Jordan & Skala Engineers
 14240 Midway Road, Suite 330
 Dallas, TX 75244-5139
 Tel: (469) 385-1616, Fax: (469) 385-1615
 Project Number - 113-0355 Texas Firm Registration # F-4990
 Drawn By: CV Checked By: RC