



REVISIONS		
1	9-2-2011	DESIGN REVISIONS
2	9-13-2011	ANSI/FHA COMMENTS DESIGN REVISIONS
3	9-23-2011	DESIGN REVISIONS
4	10-17-2011	CONSTRUCTION ISSUE DESIGN REVISIONS
5	12-21-2011	DESIGN REVISIONS
6	1-17-2012	DESIGN REVISIONS TRANSFORMER
7	2-15-2012	REVISIONS CLUBHOUSE
8	3-27-2012	REVISIONS
9	4-17-2012	COORDINATION

KELLER SPRINGS LOFTS

LOFT APARTMENTS IN ADDISON, TEXAS

10	5-15-2012	COORDINATION
11	5-30-2012	SITE COORDINATION

BGO
architects


4144 N. Central Expy.
Suite 855
Dallas, TX 75204
214.520.8878
bgoarchitects.com

DATE
08-05-11


PROJECT
11129

SHEET NUMBER

P-3.1C

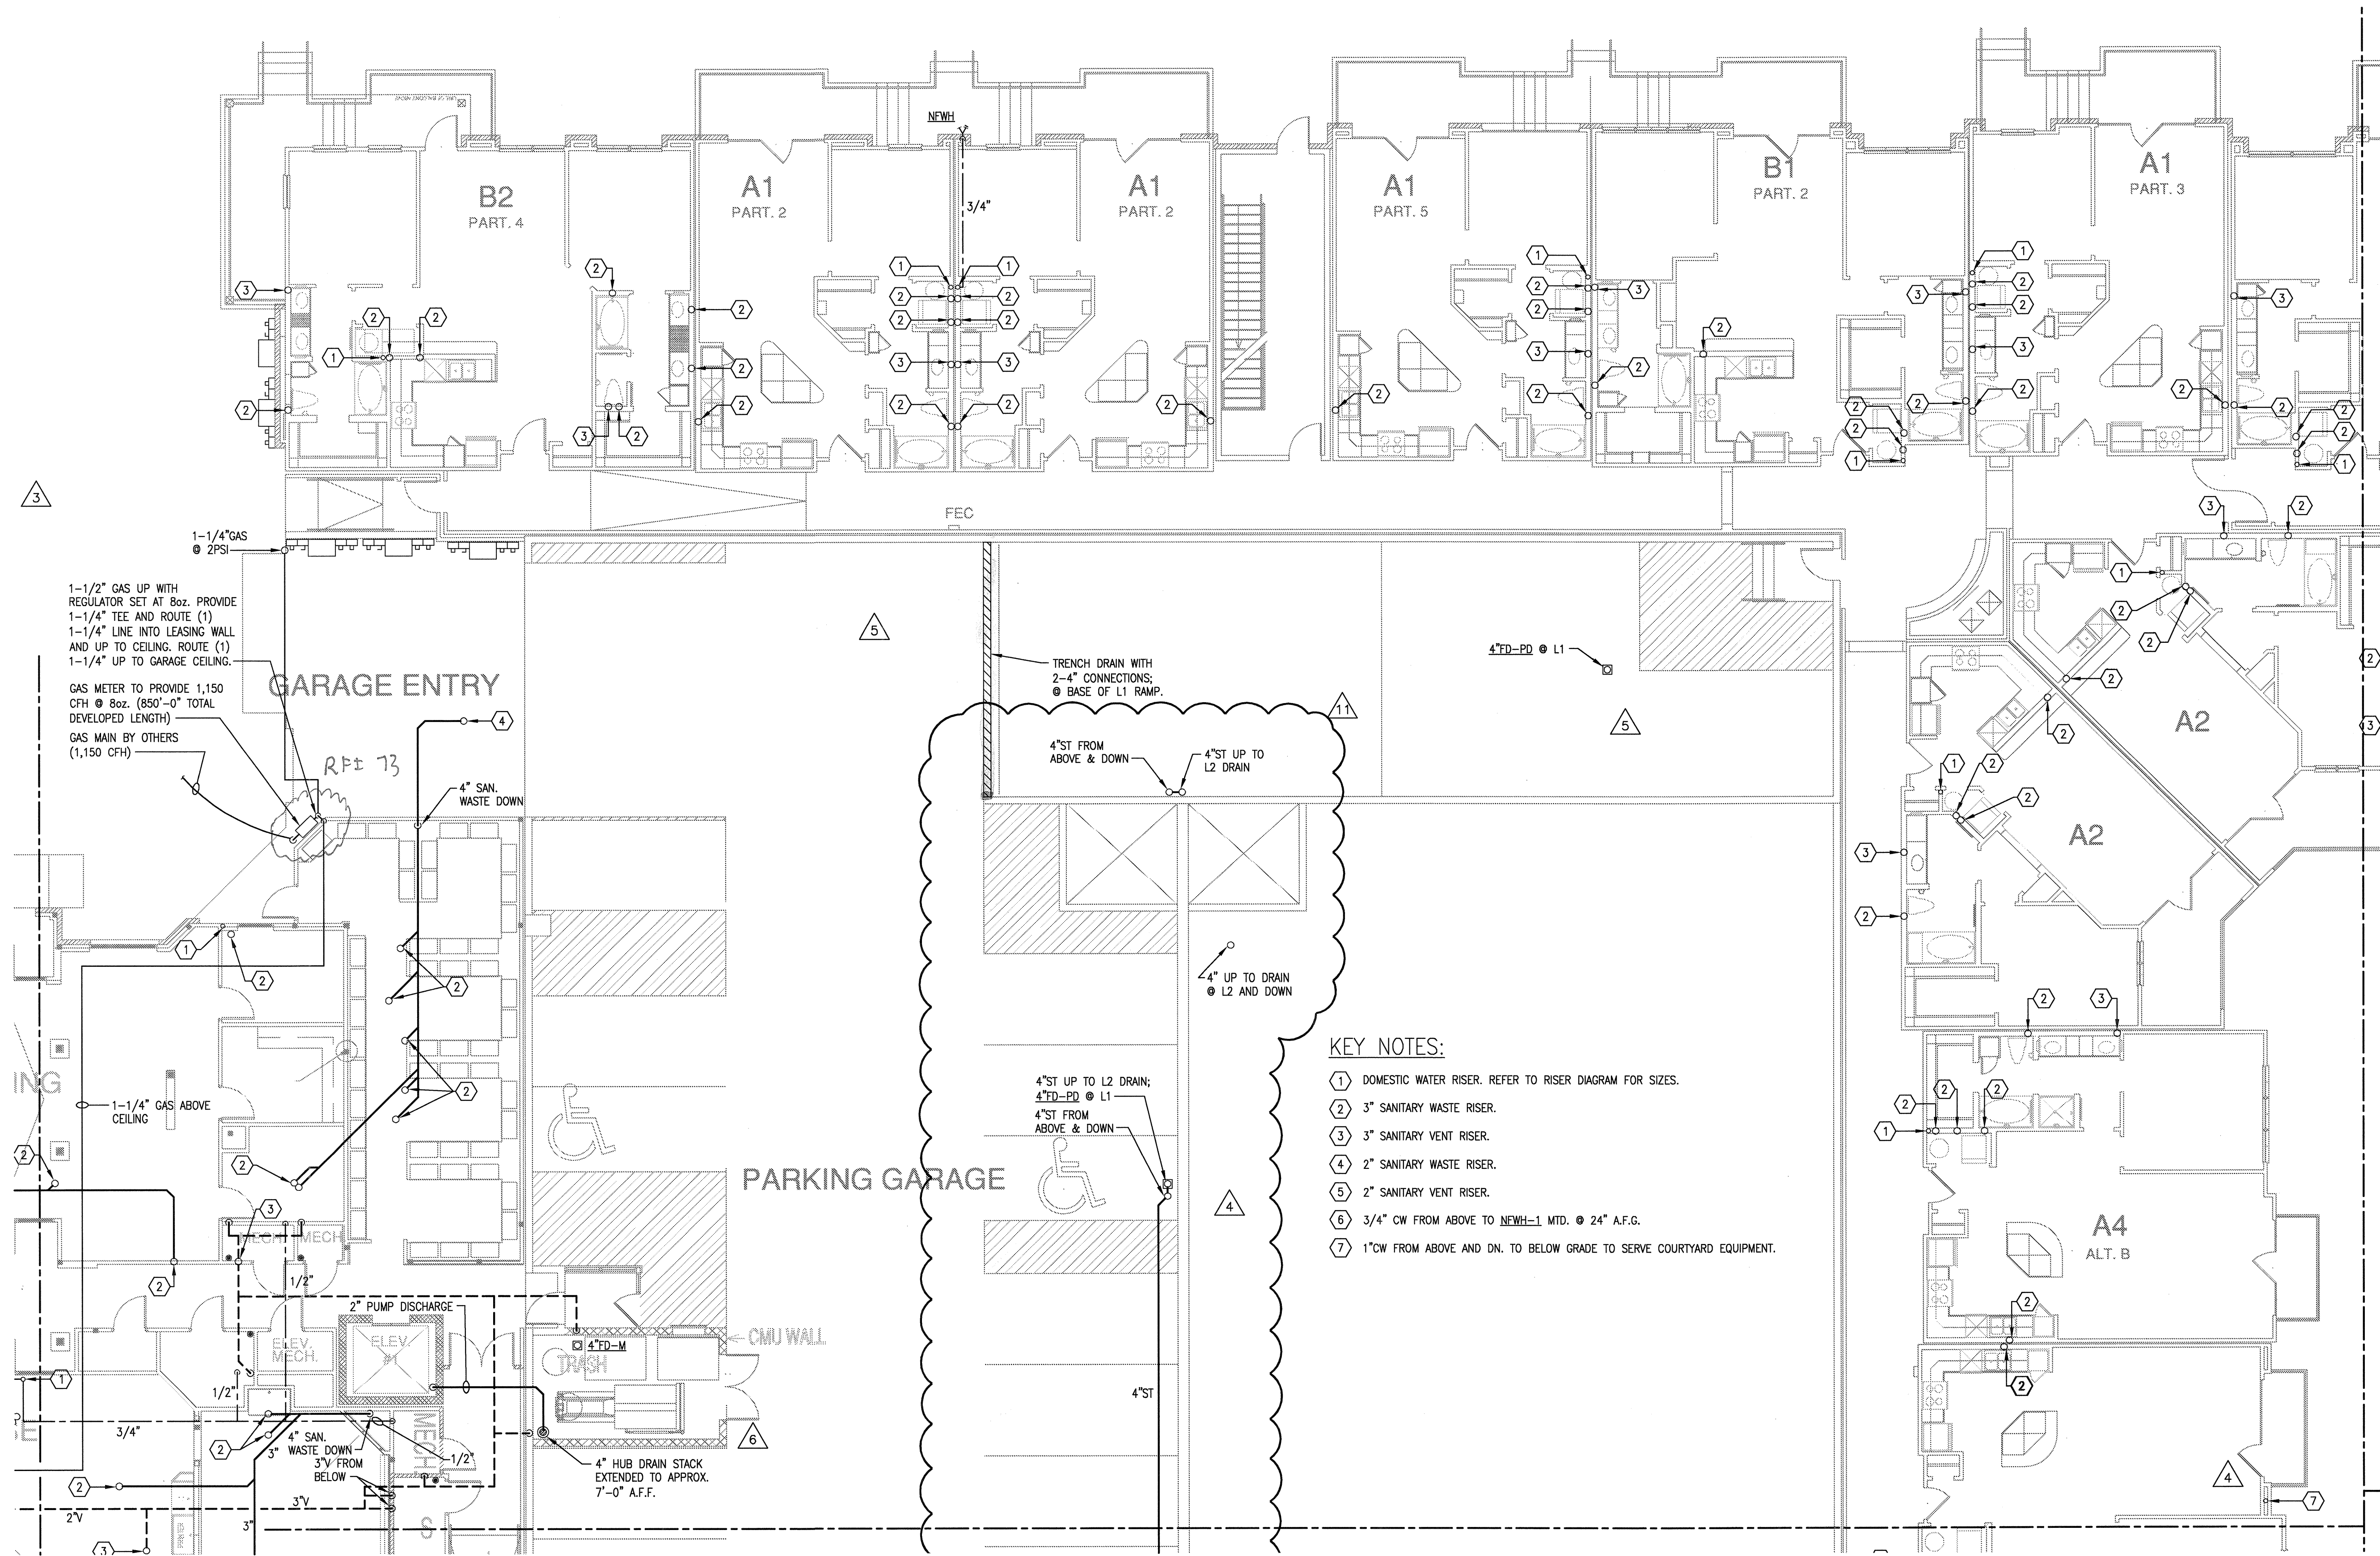

- KEY NOTES:**
- ① DOMESTIC WATER RISER. REFER TO RISER DIAGRAM FOR SIZES.
 - ② 3\"/>

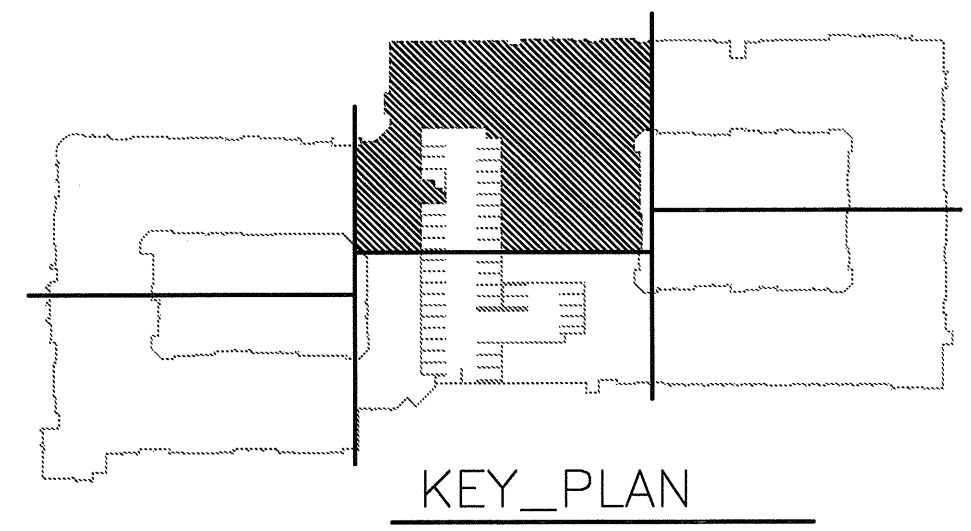

1 DIVISION 'C' FIRST FLOOR PLAN
SCALE: 1/8" = 1'-0"

JSE Jordan & Skala Engineers
17833 N. Dallas Parkway, Suite 320
Dallas, TX 75247-6837
V: 469.385.1616 Website: www.jordanaskala.com
Project Number - 113-0355 Texas Firm Registration # F-4990
Drawn By: CV Checked By: RC