



REVISIONS		
1	9-2-2011	DESIGN REVISIONS
2	9-13-2011	ANSI/FHA COMMENTS DESIGN REVISIONS
3	9-23-2011	DESIGN REVISIONS
4	10-17-2011	CONSTRUCTION ISSUE DESIGN REVISIONS
5	12-21-2011	DESIGN REVISIONS
6	1-17-2012	DESIGN REVISIONS TRANSFORMER
7	2-15-2012	REVISIONS
8	3-27-2012	CLUBHOUSE REVISIONS
9	4-17-2012	COORDINATION

KELLER SPRINGS LOFTS
LOFT APARTMENTS IN ADDISON, TEXAS


10	5-15-2012	COORDINATION
11	5-30-2012	SITE COORDINATION

BGO
architects
4144 N. Central Expy.
Suite 855
Dallas, TX 75204
214.520.8878
bgoarchitects.com

DATE
08-05-11

PROJECT
11129

SHEET NUMBER
P-3.2C

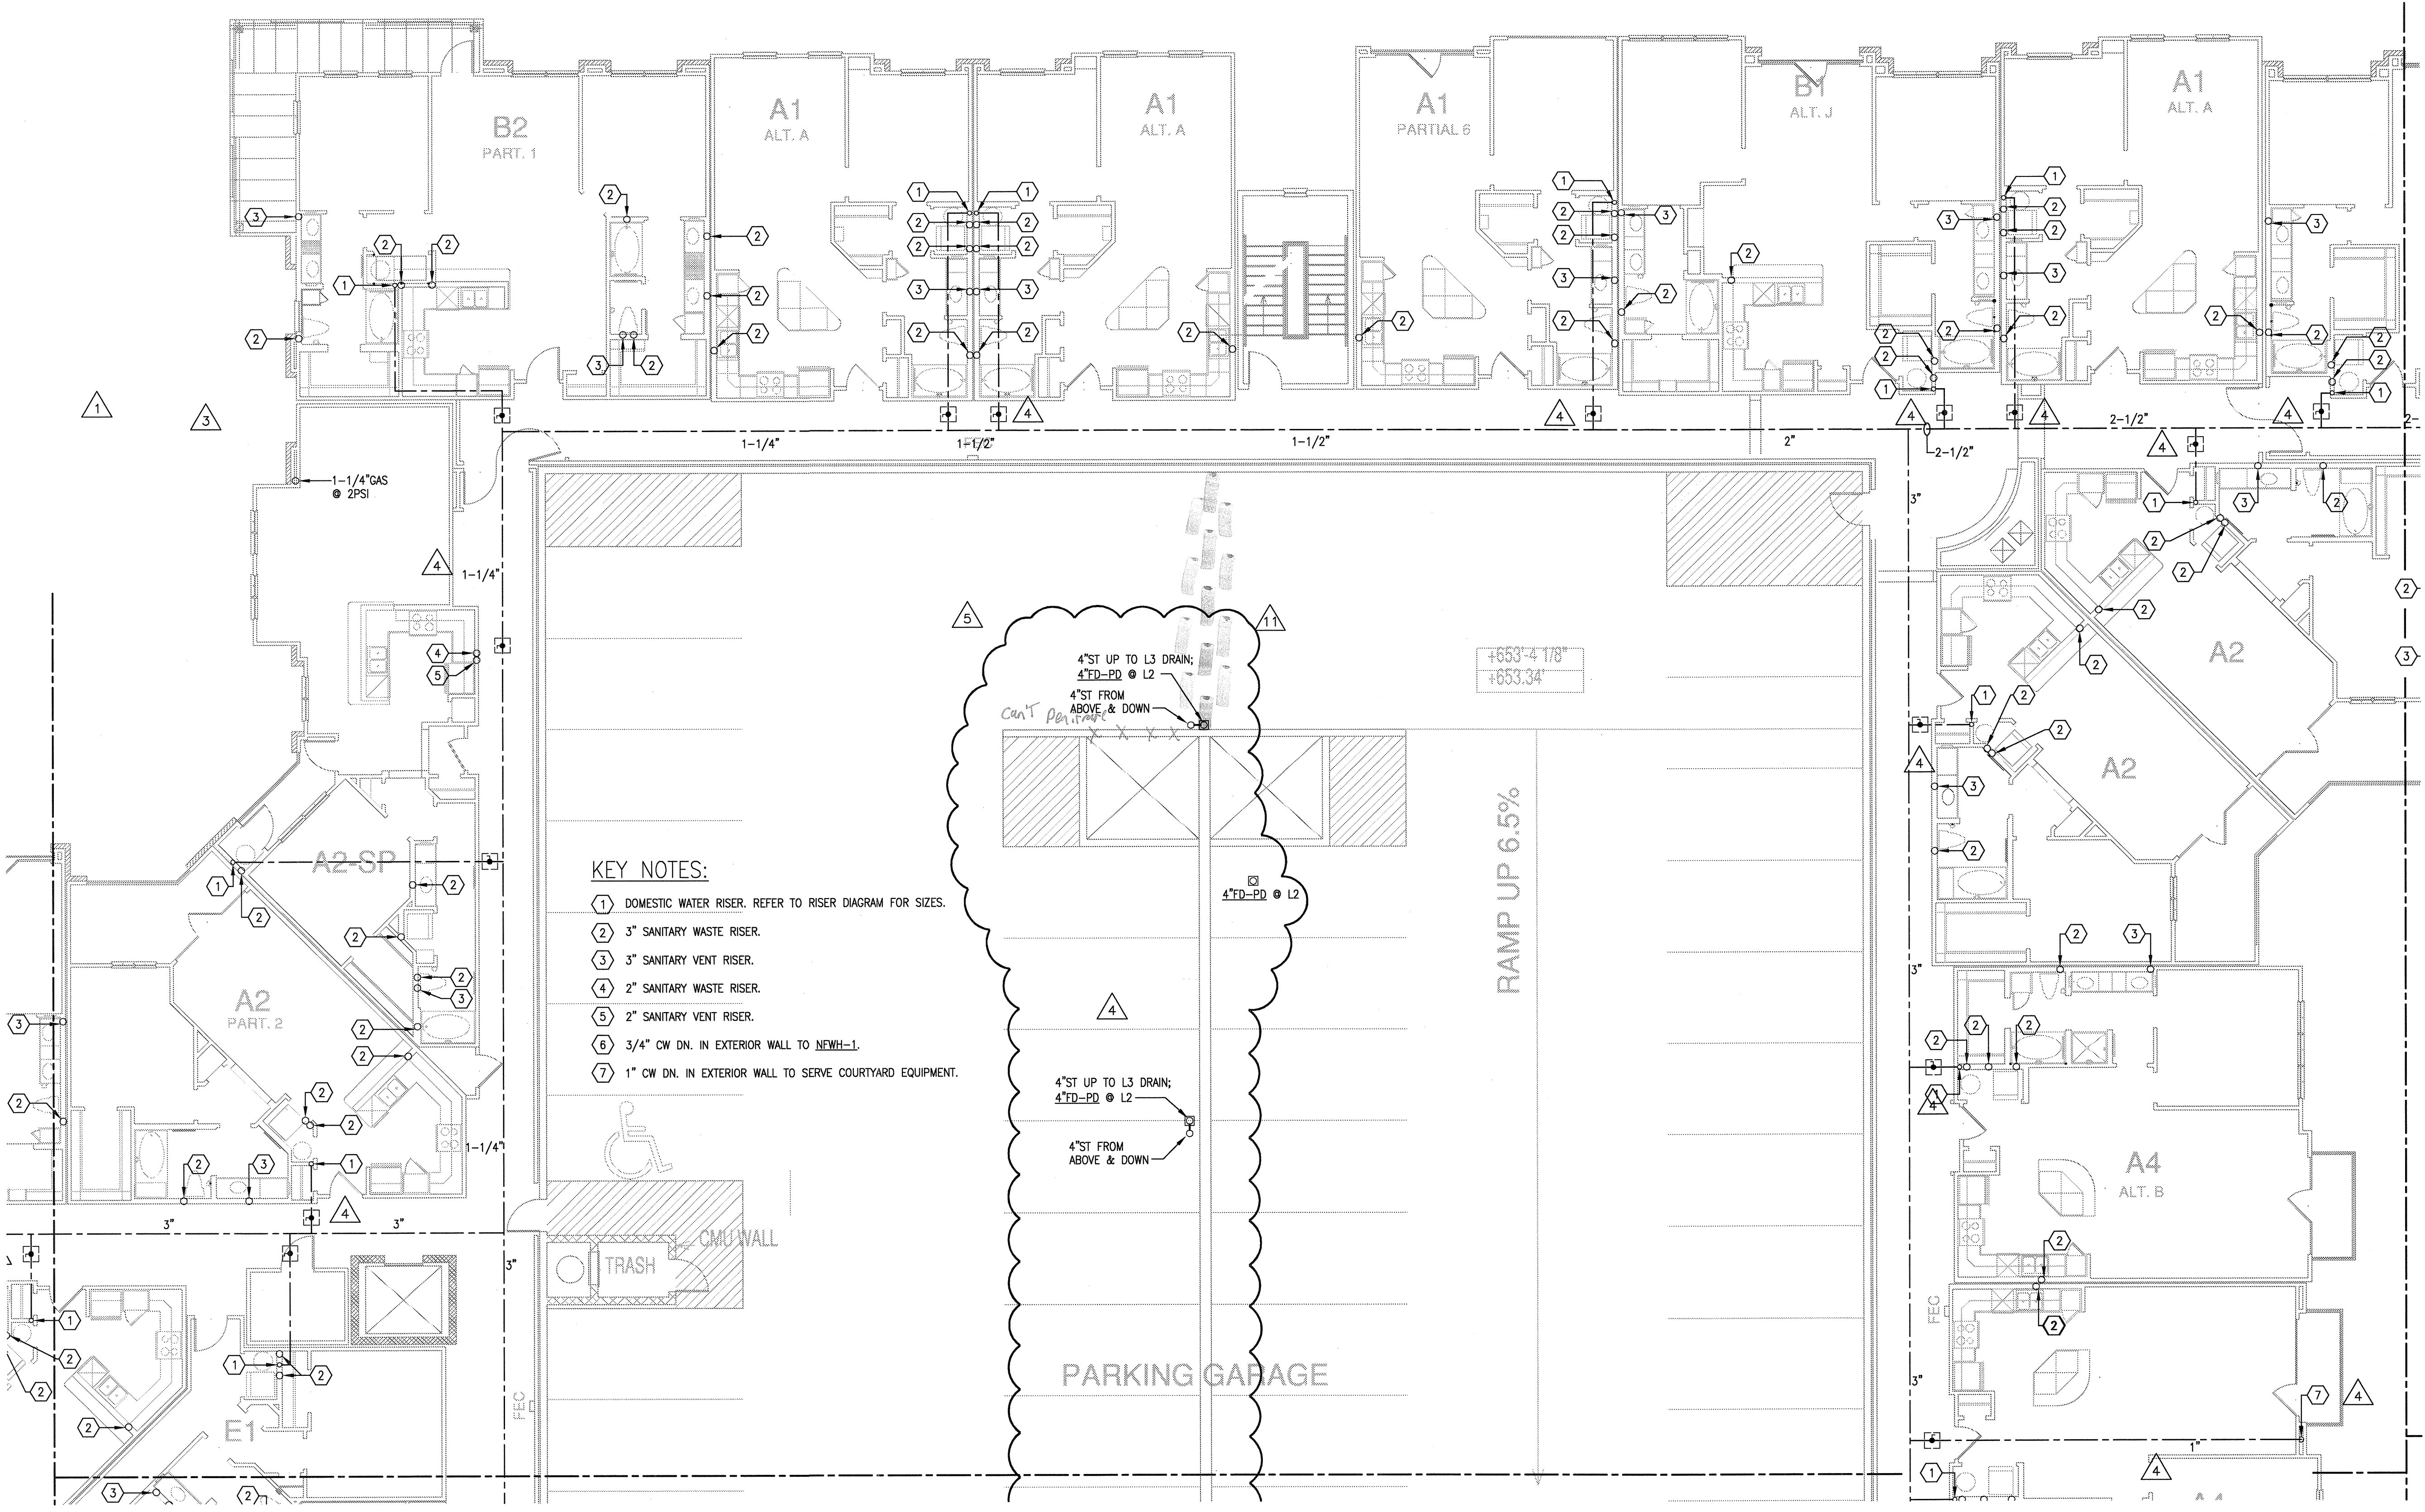

- KEY NOTES:**
- 1 DOMESTIC WATER RISER. REFER TO RISER DIAGRAM FOR SIZES.
 - 2 3" SANITARY WASTE RISER.
 - 3 3" SANITARY VENT RISER.
 - 4 2" SANITARY WASTE RISER.
 - 5 2" SANITARY VENT RISER.
 - 6 3/4" CW DN. IN EXTERIOR WALL TO NEWH-1.
 - 7 1" CW DN. IN EXTERIOR WALL TO SERVE COURTYARD EQUIPMENT.

1 DIVISION 'C' SECOND FLOOR PLAN
SCALE: 1/8" = 1'-0"

JSE Jordan & Skala Engineers
17855 N. Dallas Parkway, Suite 320
Dallas, TX 75287-6857
V: 469.385.1616 Web: www.jordanskala.com
Project Number - 113-0355 Texas Firm Registration # F-4990
Drawn By: CV Checked By: RC