



REVISIONS		
1	9-2-2011	DESIGN REVISIONS
2	9-13-2011	ANSI/FHA COMMENTS
3	9-23-2011	DESIGN REVISIONS
4	10-17-2011	CONSTRUCTION ISSUE

**KELLER SPRINGS LOFTS**  
LOFT APARTMENTS IN ADDISON, TEXAS



4144 N. Central Exp.  
Suite 855  
Dallas, TX 75204  
214.520.8878  
bgoarchitects.com



DATE  
08-05-11

PROJECT  
11129

SHEET NUMBER

**P-3.2D**

**JSE** Jordan & Skala Engineers  
14240 Midway Road, Suite 350  
Dallas, TX 75244-5338  
V: (469) 385-1616 F: (469) 385-1615  
Project Number - 113-0355 Texas Firm Registration # F-4990  
Drawn By: CV Checked By: RC

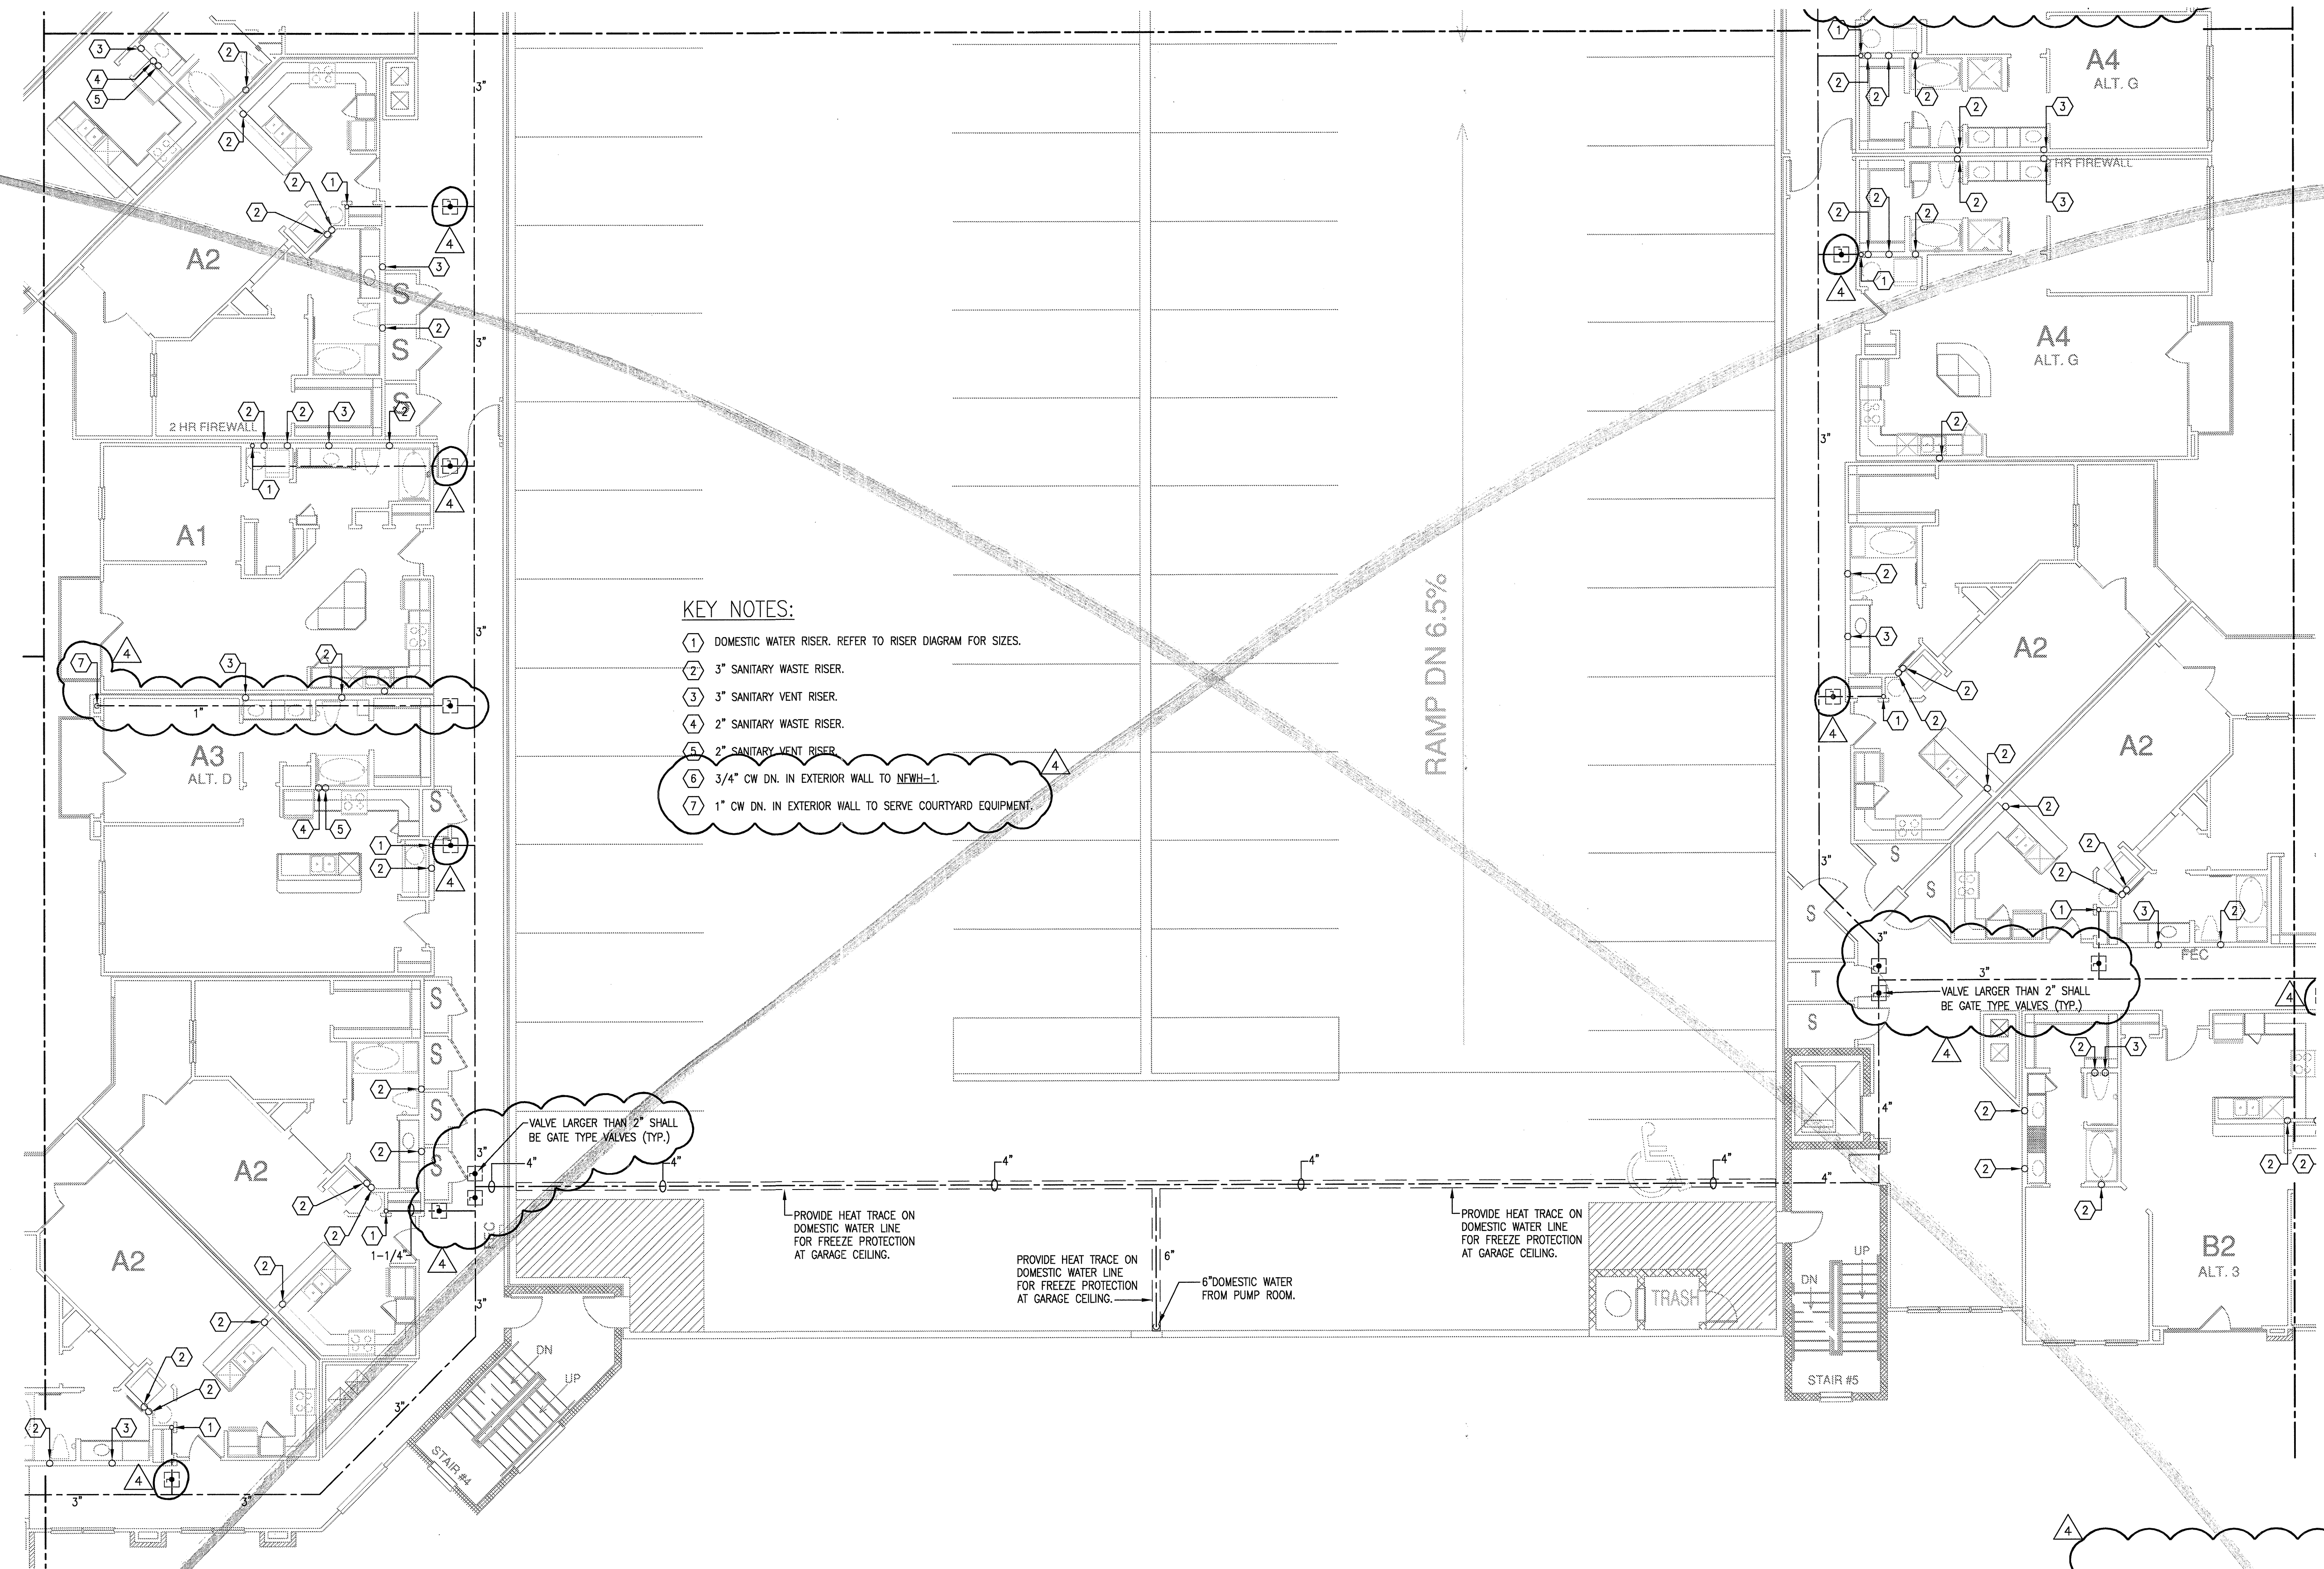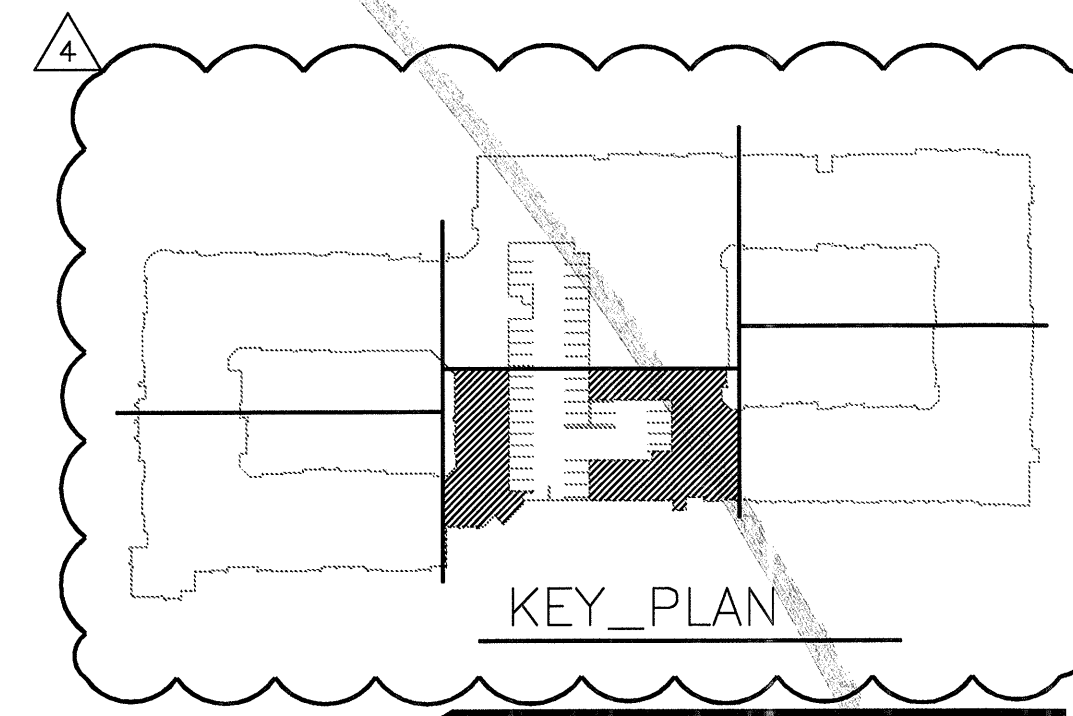

- KEY NOTES:**
- 1 DOMESTIC WATER RISER. REFER TO RISER DIAGRAM FOR SIZES.
  - 2 3" SANITARY WASTE RISER.
  - 3 3" SANITARY VENT RISER.
  - 4 2" SANITARY WASTE RISER.
  - 5 2" SANITARY VENT RISER.
  - 6 3/4" CW DN. IN EXTERIOR WALL TO NFWH-1.
  - 7 1" CW DN. IN EXTERIOR WALL TO SERVE COURTYARD EQUIPMENT.

1 DIVISION 'D' SECOND FLOOR PLAN  
SCALE: 1/8" = 1'-0"