


REVISIONS

1	9-2-2011	DESIGN REVISIONS
2	9-13-2011	ANSI/FHA COMMENTS
3	9-23-2011	DESIGN REVISIONS
4	10-17-2011	CONSTRUCTION ISSUE

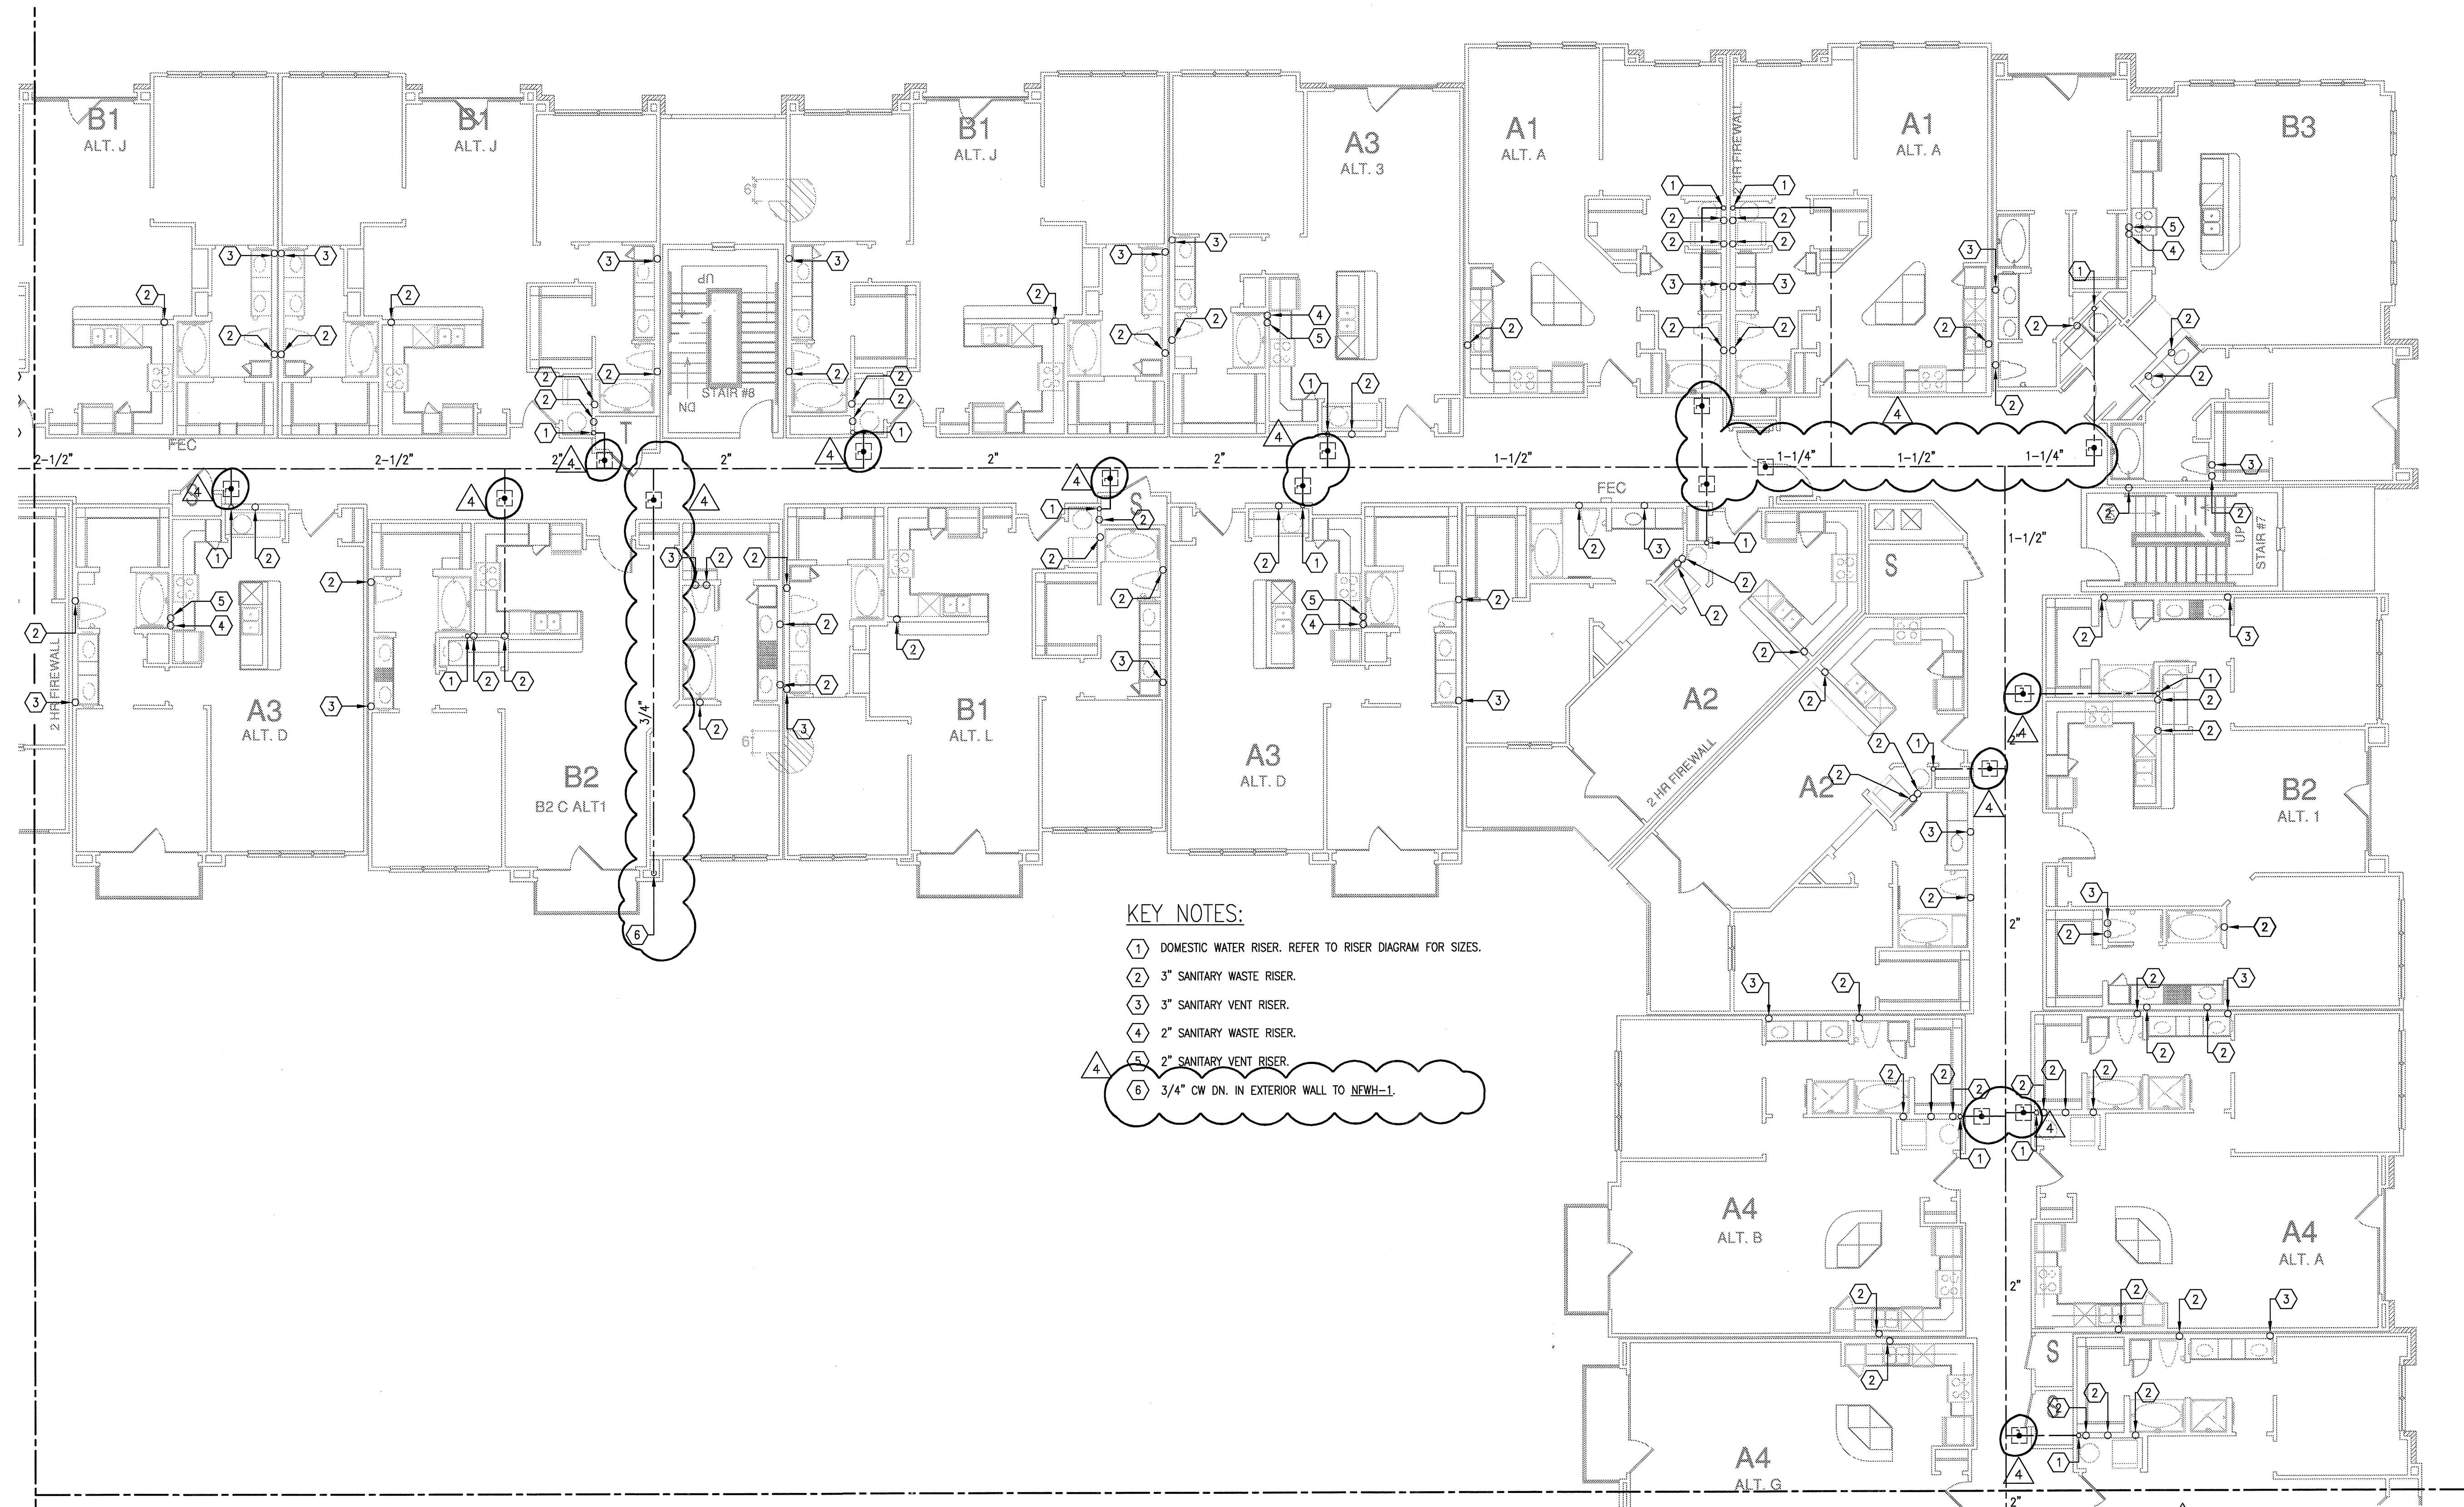

- KEY NOTES:
- 1 DOMESTIC WATER RISER. REFER TO RISER DIAGRAM FOR SIZES.
 - 2 3" SANITARY WASTE RISER.
 - 3 3" SANITARY VENT RISER.
 - 4 2" SANITARY WASTE RISER.
 - 5 2" SANITARY VENT RISER.
 - 6 3/4" CW DN. IN EXTERIOR WALL TO NEWH-1.

KELLER SPRINGS LOFTS

LOFT APARTMENTS IN ADDISON, TEXAS


BGO
architects

4144 N. Central Expy.
Suite 855
Dallas, TX 75204
214-520-8878
bgoarchitects.com

DATE
08-05-11

PROJECT
11129

SHEET NUMBER
P-3.2E

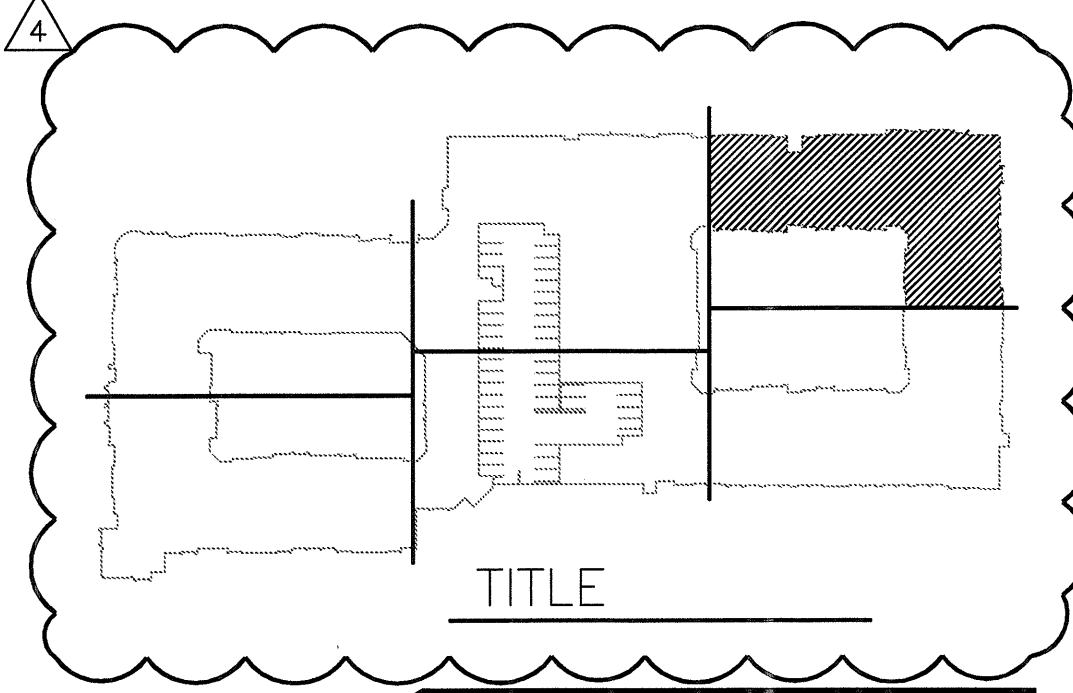

JSE Jordan & Skala Engineers

14245 Midway Road, Suite 350
Dallas, TX 75244-6238
V: (469) 383-1676 F: (469) 383-1615
Project Number - 113-0355 Texas Firm Registration # F-4990
Drawn By: CV Checked By: RC

1 DIVISION 'E' SECOND FLOOR PLAN
SCALE: 1/8" = 1'-0"