



REVISIONS		
1	9-2-2011	DESIGN REVISIONS
2	9-13-2011	ANSI/FHA COMMENTS
3	9-23-2011	DESIGN REVISIONS
4	10-17-2011	CONSTRUCTION ISSUE
5	12-21-2011	DESIGN REVISIONS
6	1-17-2012	DESIGN REVISIONS
7	2-15-2012	TRANSFORMER REVISIONS
8	3-27-2012	CLUBHOUSE REVISIONS
9	4-17-2012	COORDINATION

KELLER SPRINGS LOFTS

LOFT APARTMENTS IN ADDISON, TEXAS

10	5-15-2012	COORDINATION
11	5-30-2012	SITE COORDINATION



4144 N. Central Expy.
Suite 855
Dallas, TX 75204
214.520.8878
bgoarchitects.com



DATE
08-05-11

PROJECT
11129

SHEET NUMBER

P-3.3D

JSE Jordan & Skala Engineers
17833 N. Dallas Parkway, Suite 370
Dallas, TX 75247-4857
V: 469 385 1616 Web: www.jordanskala.com
Project Number - 113-0355 Texas Firm Registration # F-4990
Drawn By: CV Checked By: RC

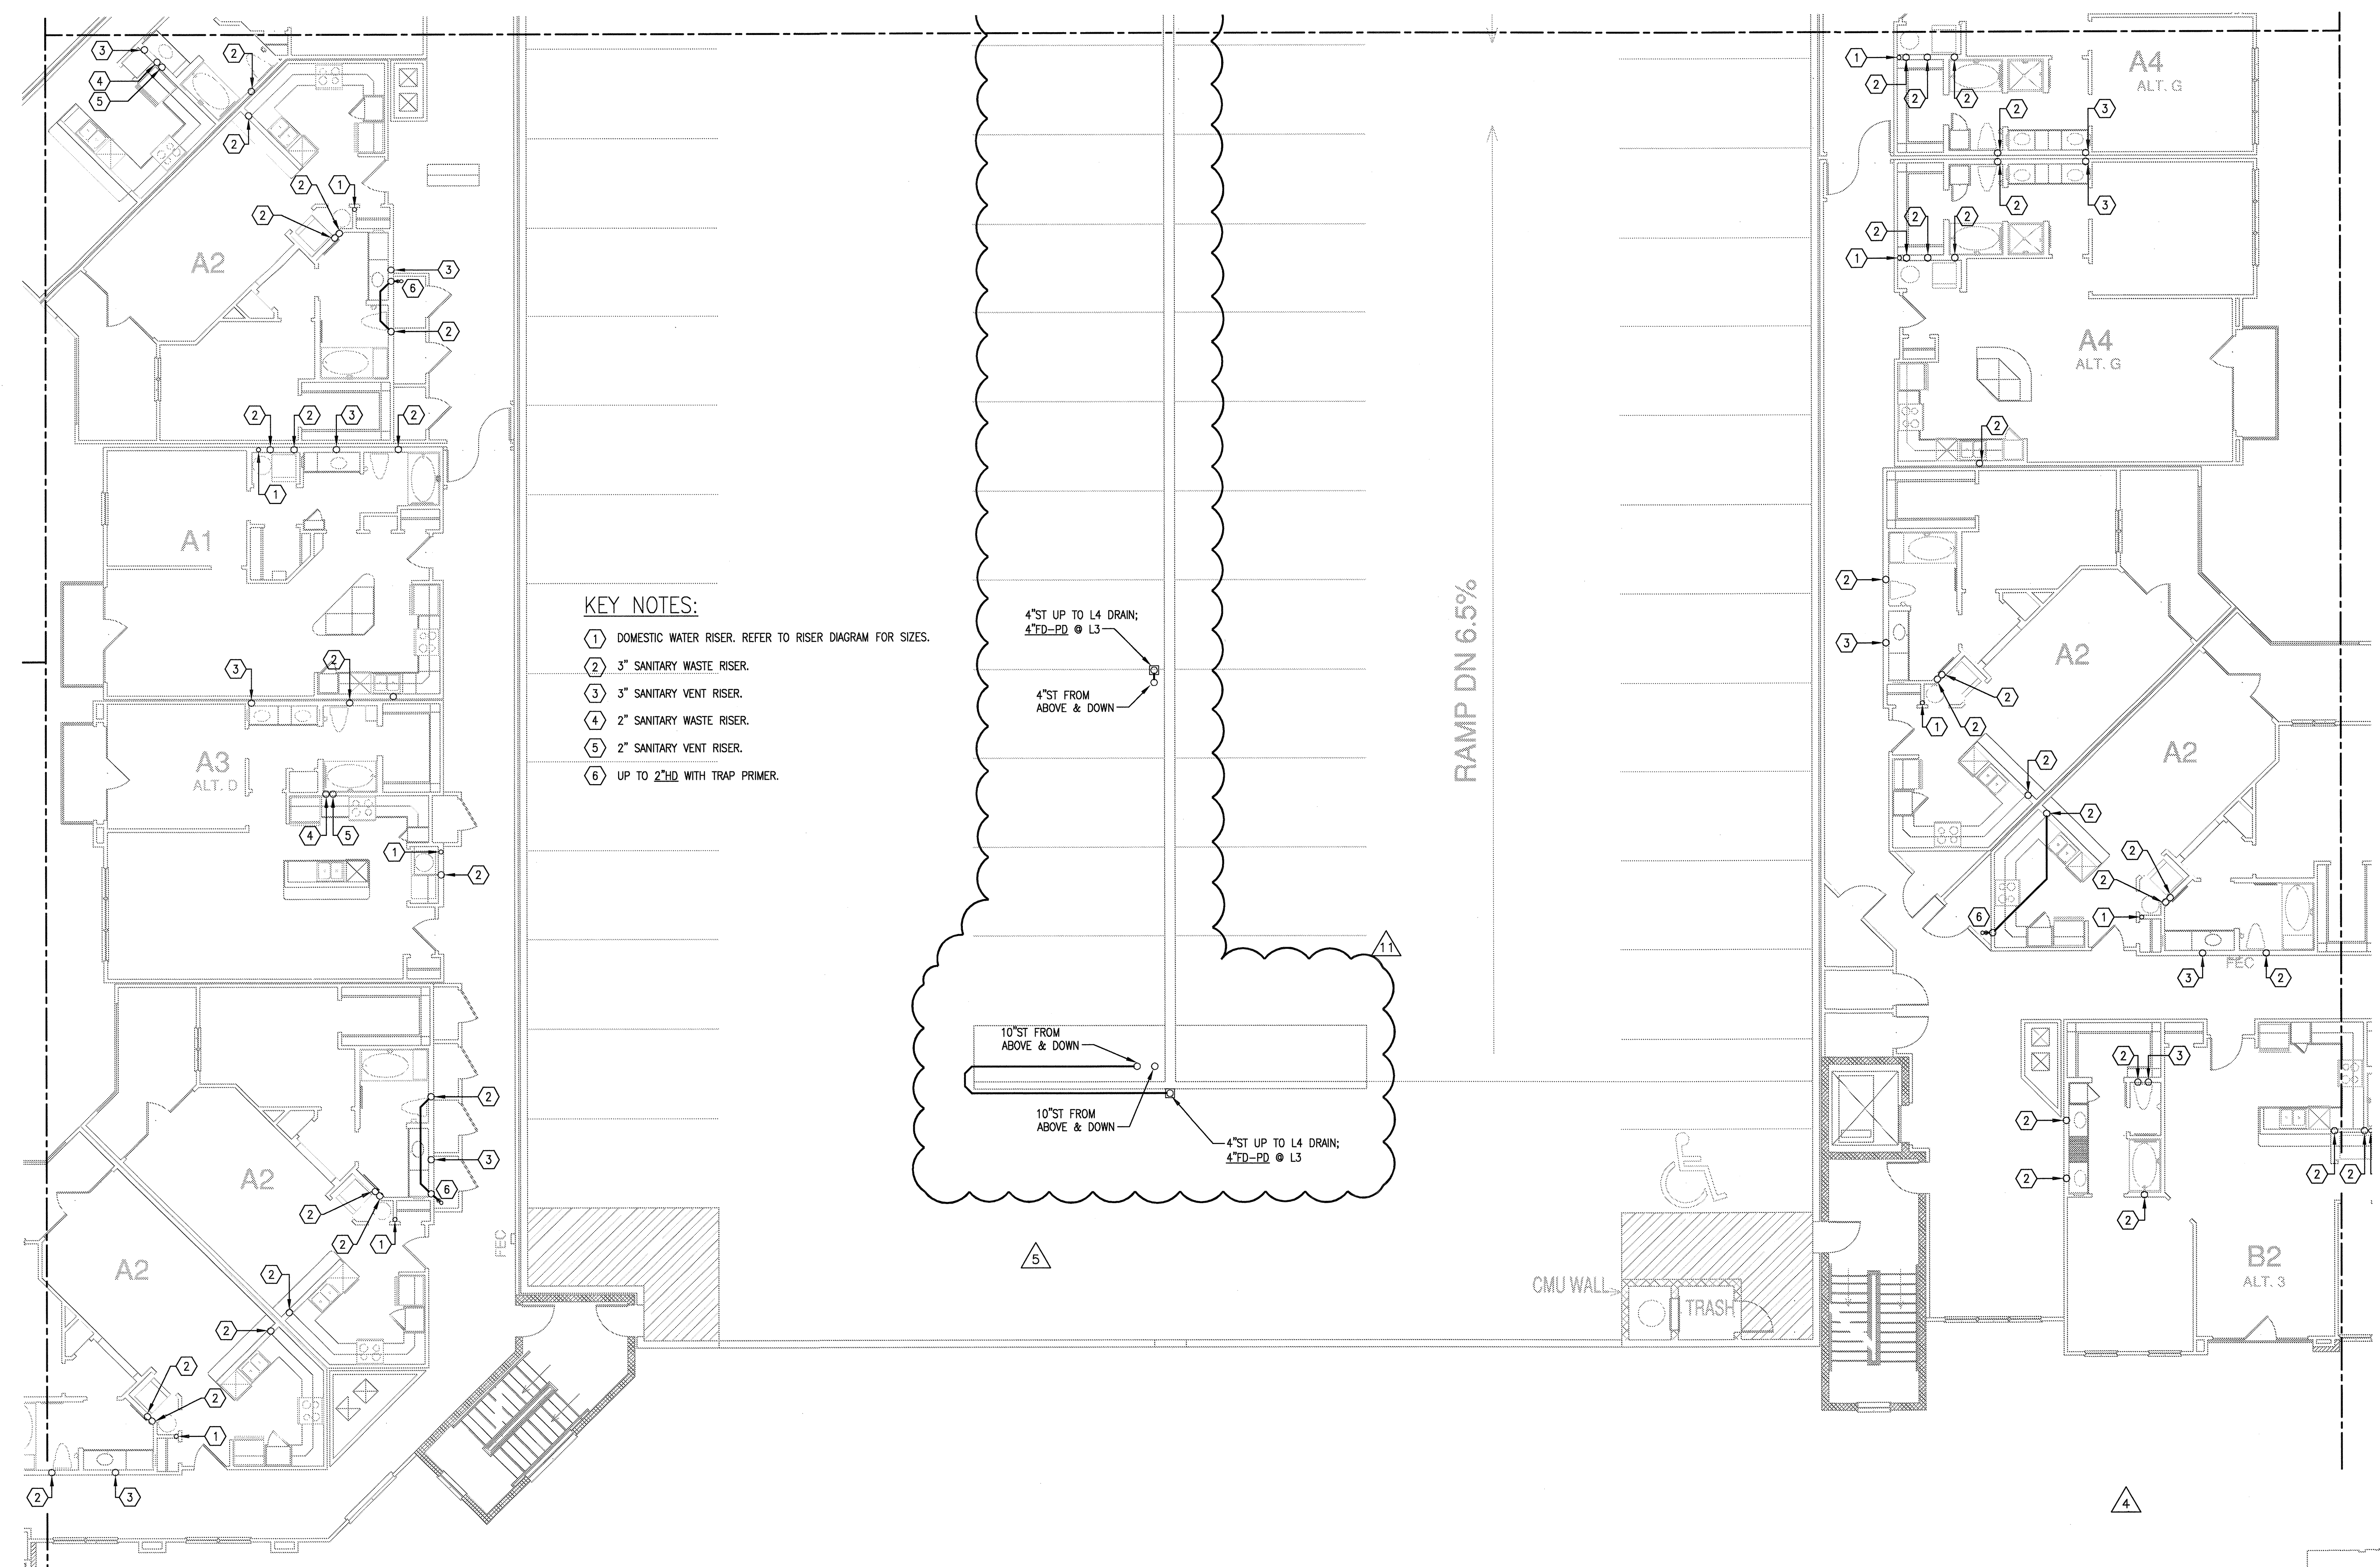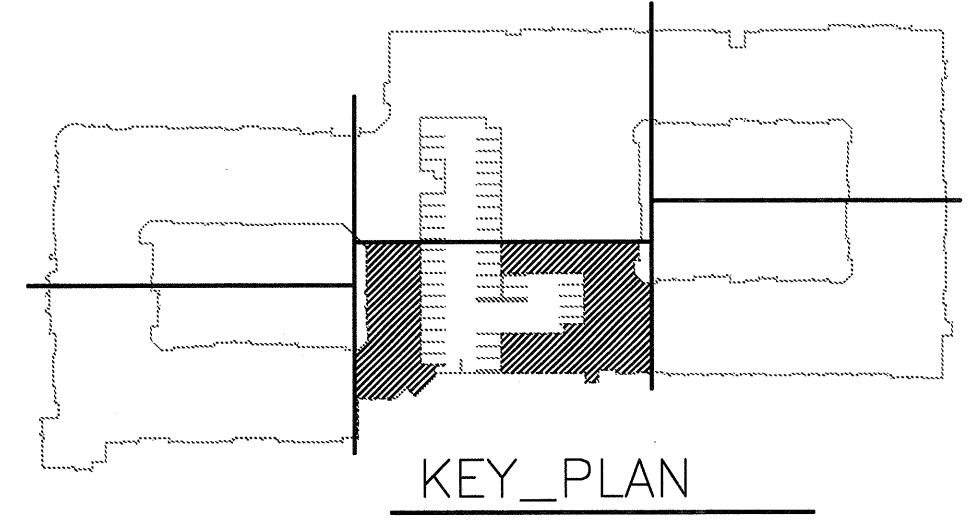

- KEY NOTES:**
- 1 DOMESTIC WATER RISER. REFER TO RISER DIAGRAM FOR SIZES.
 - 2 3" SANITARY WASTE RISER.
 - 3 3" SANITARY VENT RISER.
 - 4 2" SANITARY WASTE RISER.
 - 5 2" SANITARY VENT RISER.
 - 6 UP TO 2" HD WITH TRAP PRIMER.

1 DIVISION 'D' THIRD FLOOR PLAN
SCALE: 1/8" = 1'-0"