

REVISIONS		
1	9-2-2011	DESIGN REVISIONS
2	9-13-2011	ANSI/FHA COMMENTS
3	9-23-2011	DESIGN REVISIONS
4	10-17-2011	CONSTRUCTION ISSUE

KELLER SPRINGS LOFTS
LOFT APARTMENTS IN ADDISON, TEXAS

BGO
architects
4144 N. Central Expy.
Suite 855
Dallas, TX 75204
214.520.8878
bgoarchitects.com


DATE
08-05-11

PROJECT
11129


SHEET NUMBER

P-3.3F

JSE Jordan & Skala Engineers
14240 Midway Road, Suite 300
Dallas, TX 75244-5138
V: (469) 385-1616 F: (469) 385-1615
Project Number - 113-0355 Texas Firm Registration # F-4990
Drawn By: CV Checked By: RC

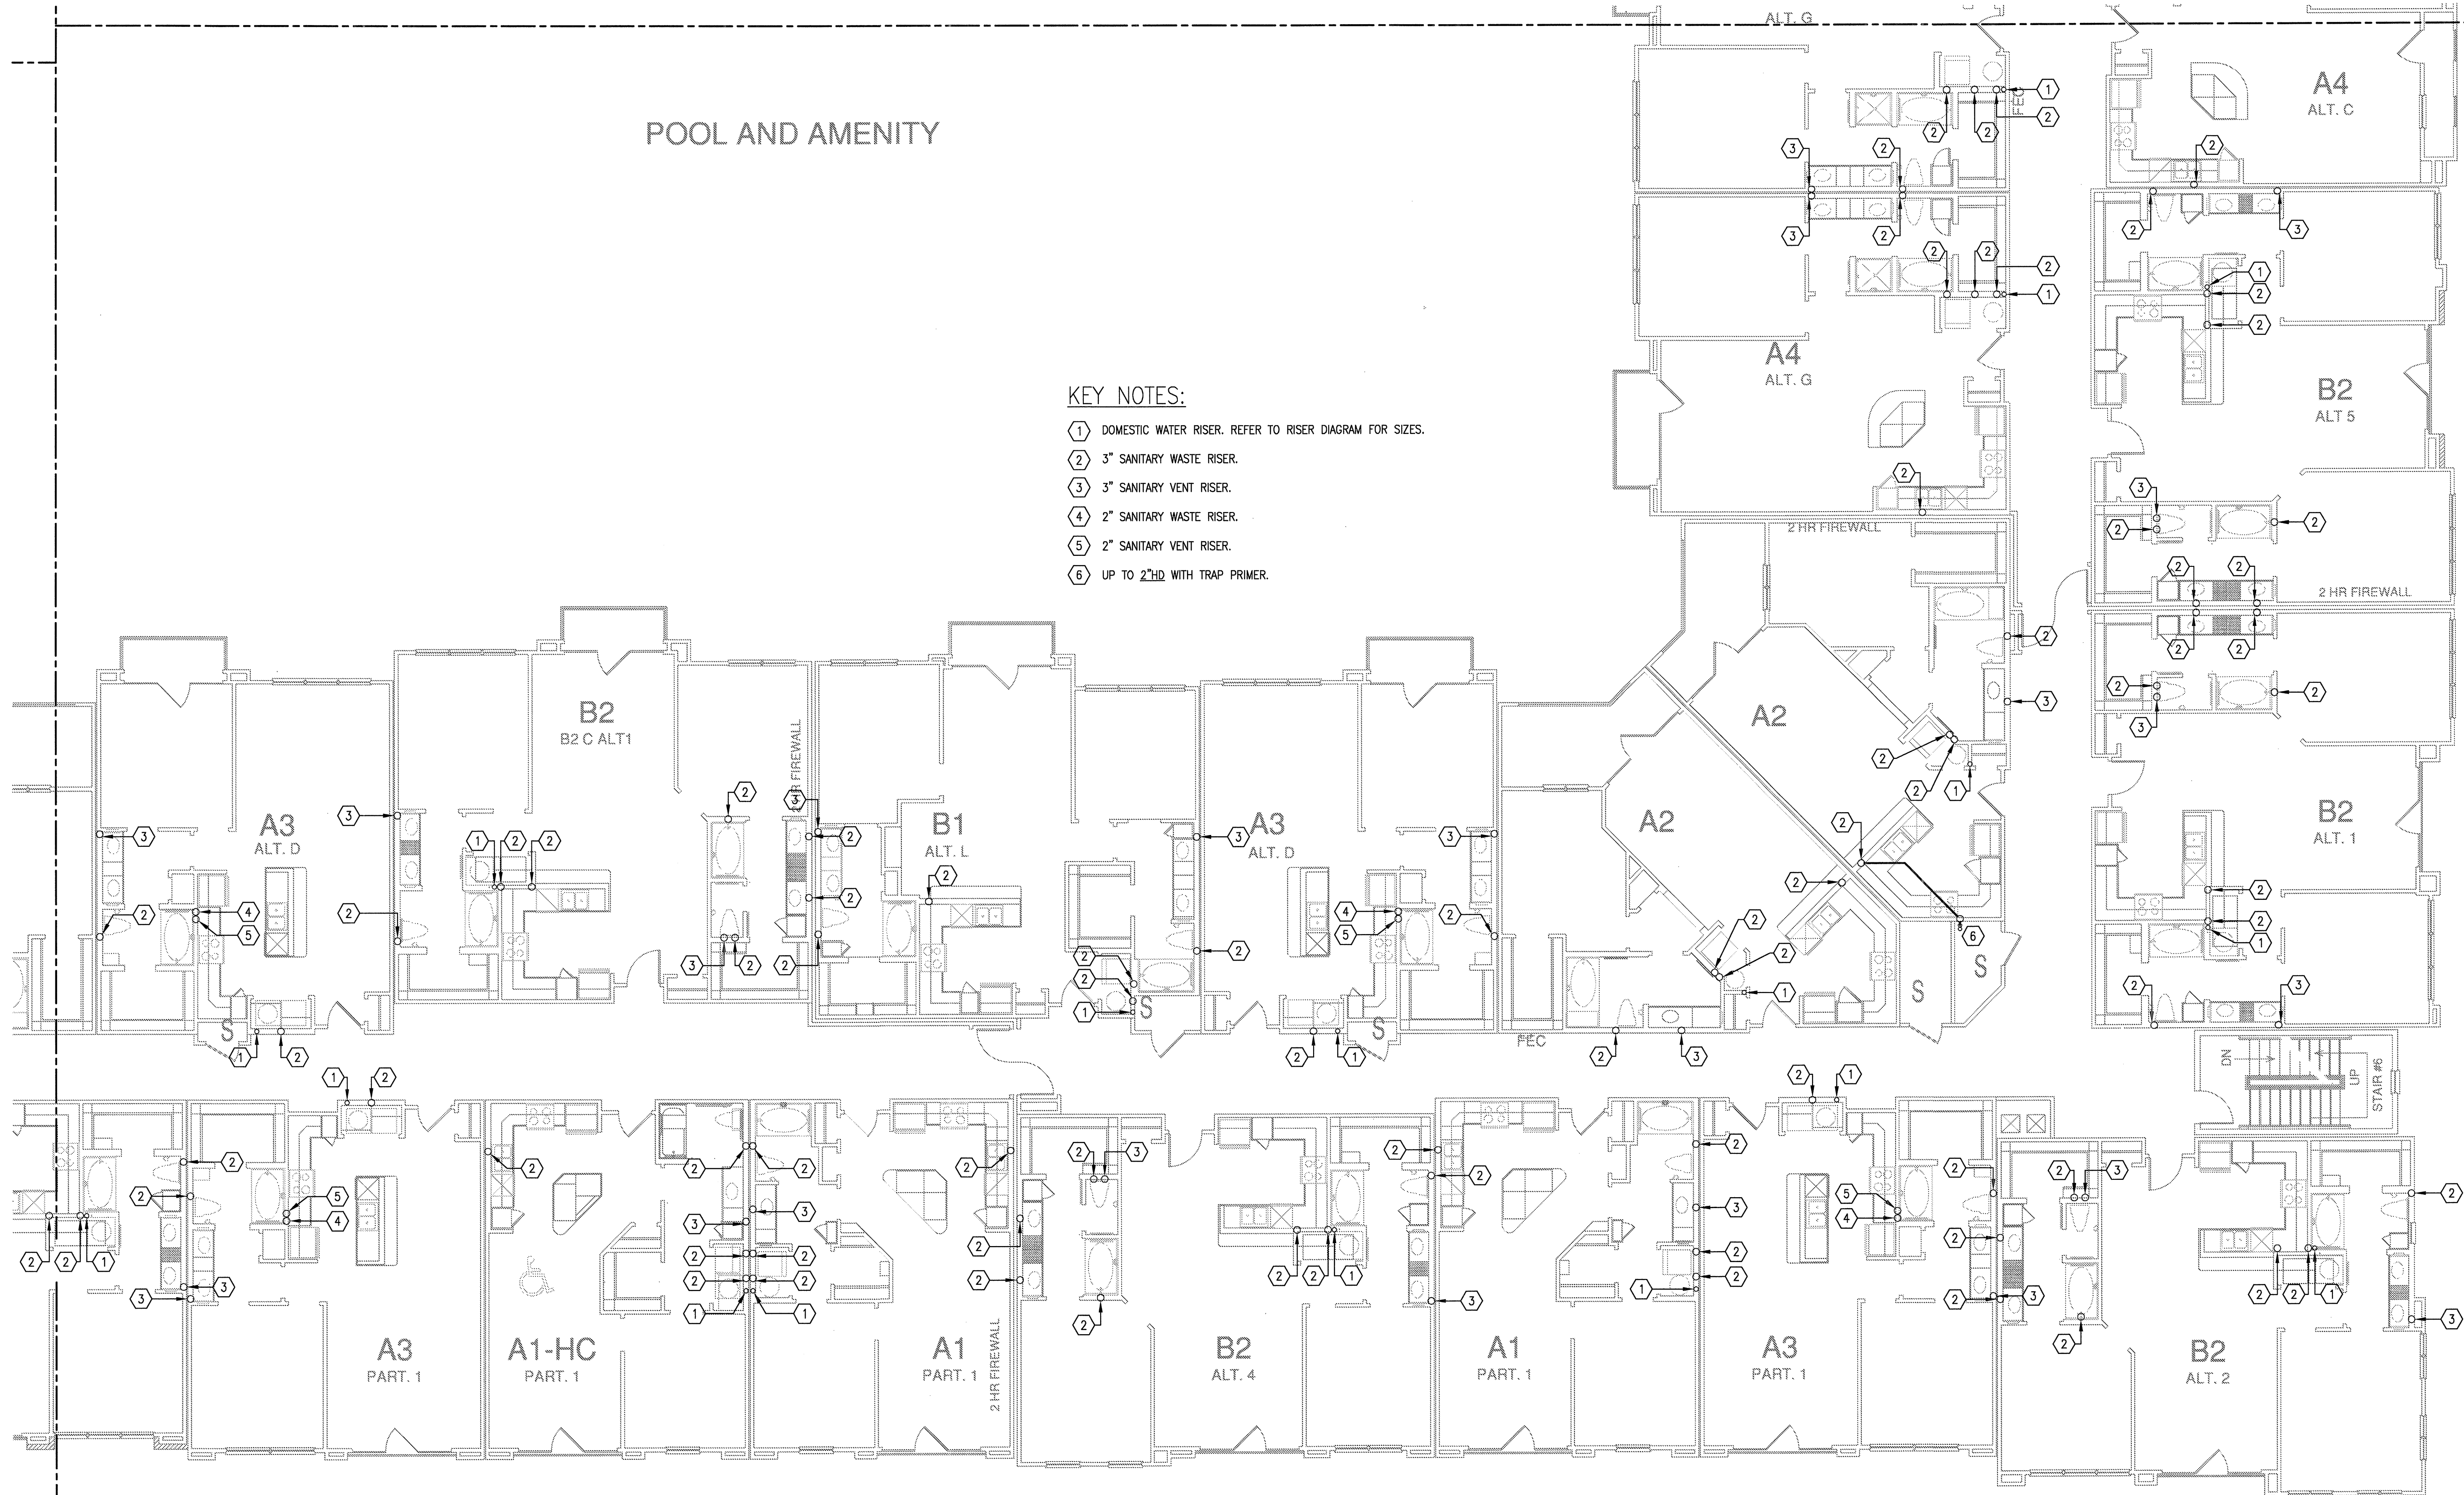

- KEY NOTES:**
- 1 DOMESTIC WATER RISER. REFER TO RISER DIAGRAM FOR SIZES.
 - 2 3" SANITARY WASTE RISER.
 - 3 3" SANITARY VENT RISER.
 - 4 2" SANITARY WASTE RISER.
 - 5 2" SANITARY VENT RISER.
 - 6 UP TO 2"HD WITH TRAP PRIMER.

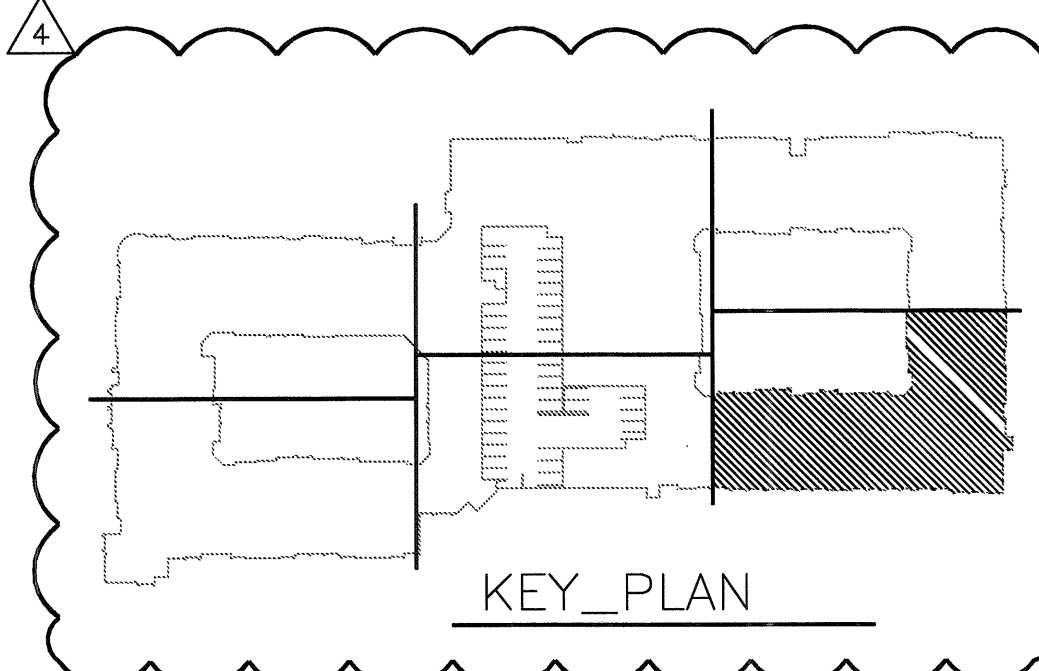

1 DIVISION 'F' THIRD FLOOR PLAN
SCALE: 1/8" = 1'-0"