



REVISIONS		
1	9-2-2011	DESIGN REVISIONS
2	9-13-2011	ANSI/FHA COMMENTS
3	9-23-2011	DESIGN REVISIONS
4	10-17-2011	CONSTRUCTION ISSUE
5	12-21-2011	DESIGN REVISIONS
6	1-17-2012	DESIGN REVISIONS
7	2-15-2012	TRANSFORMER REVISIONS
8	3-27-2012	CLUBHOUSE REVISIONS
9	4-17-2012	COORDINATION

KELLER SPRINGS LOFTS
 LOFT APARTMENTS IN ADDISON, TEXAS


10	5-15-2012	COORDINATION
11	5-30-2012	SITE COORDINATION

BGO
 architects
 4144 N. Central Expy.
 Suite 855
 Dallas, TX 75204
 214.520.8878
 bgoarchitects.com

DATE
 08-05-11

PROJECT
 11129

SHEET NUMBER
P-3.4C

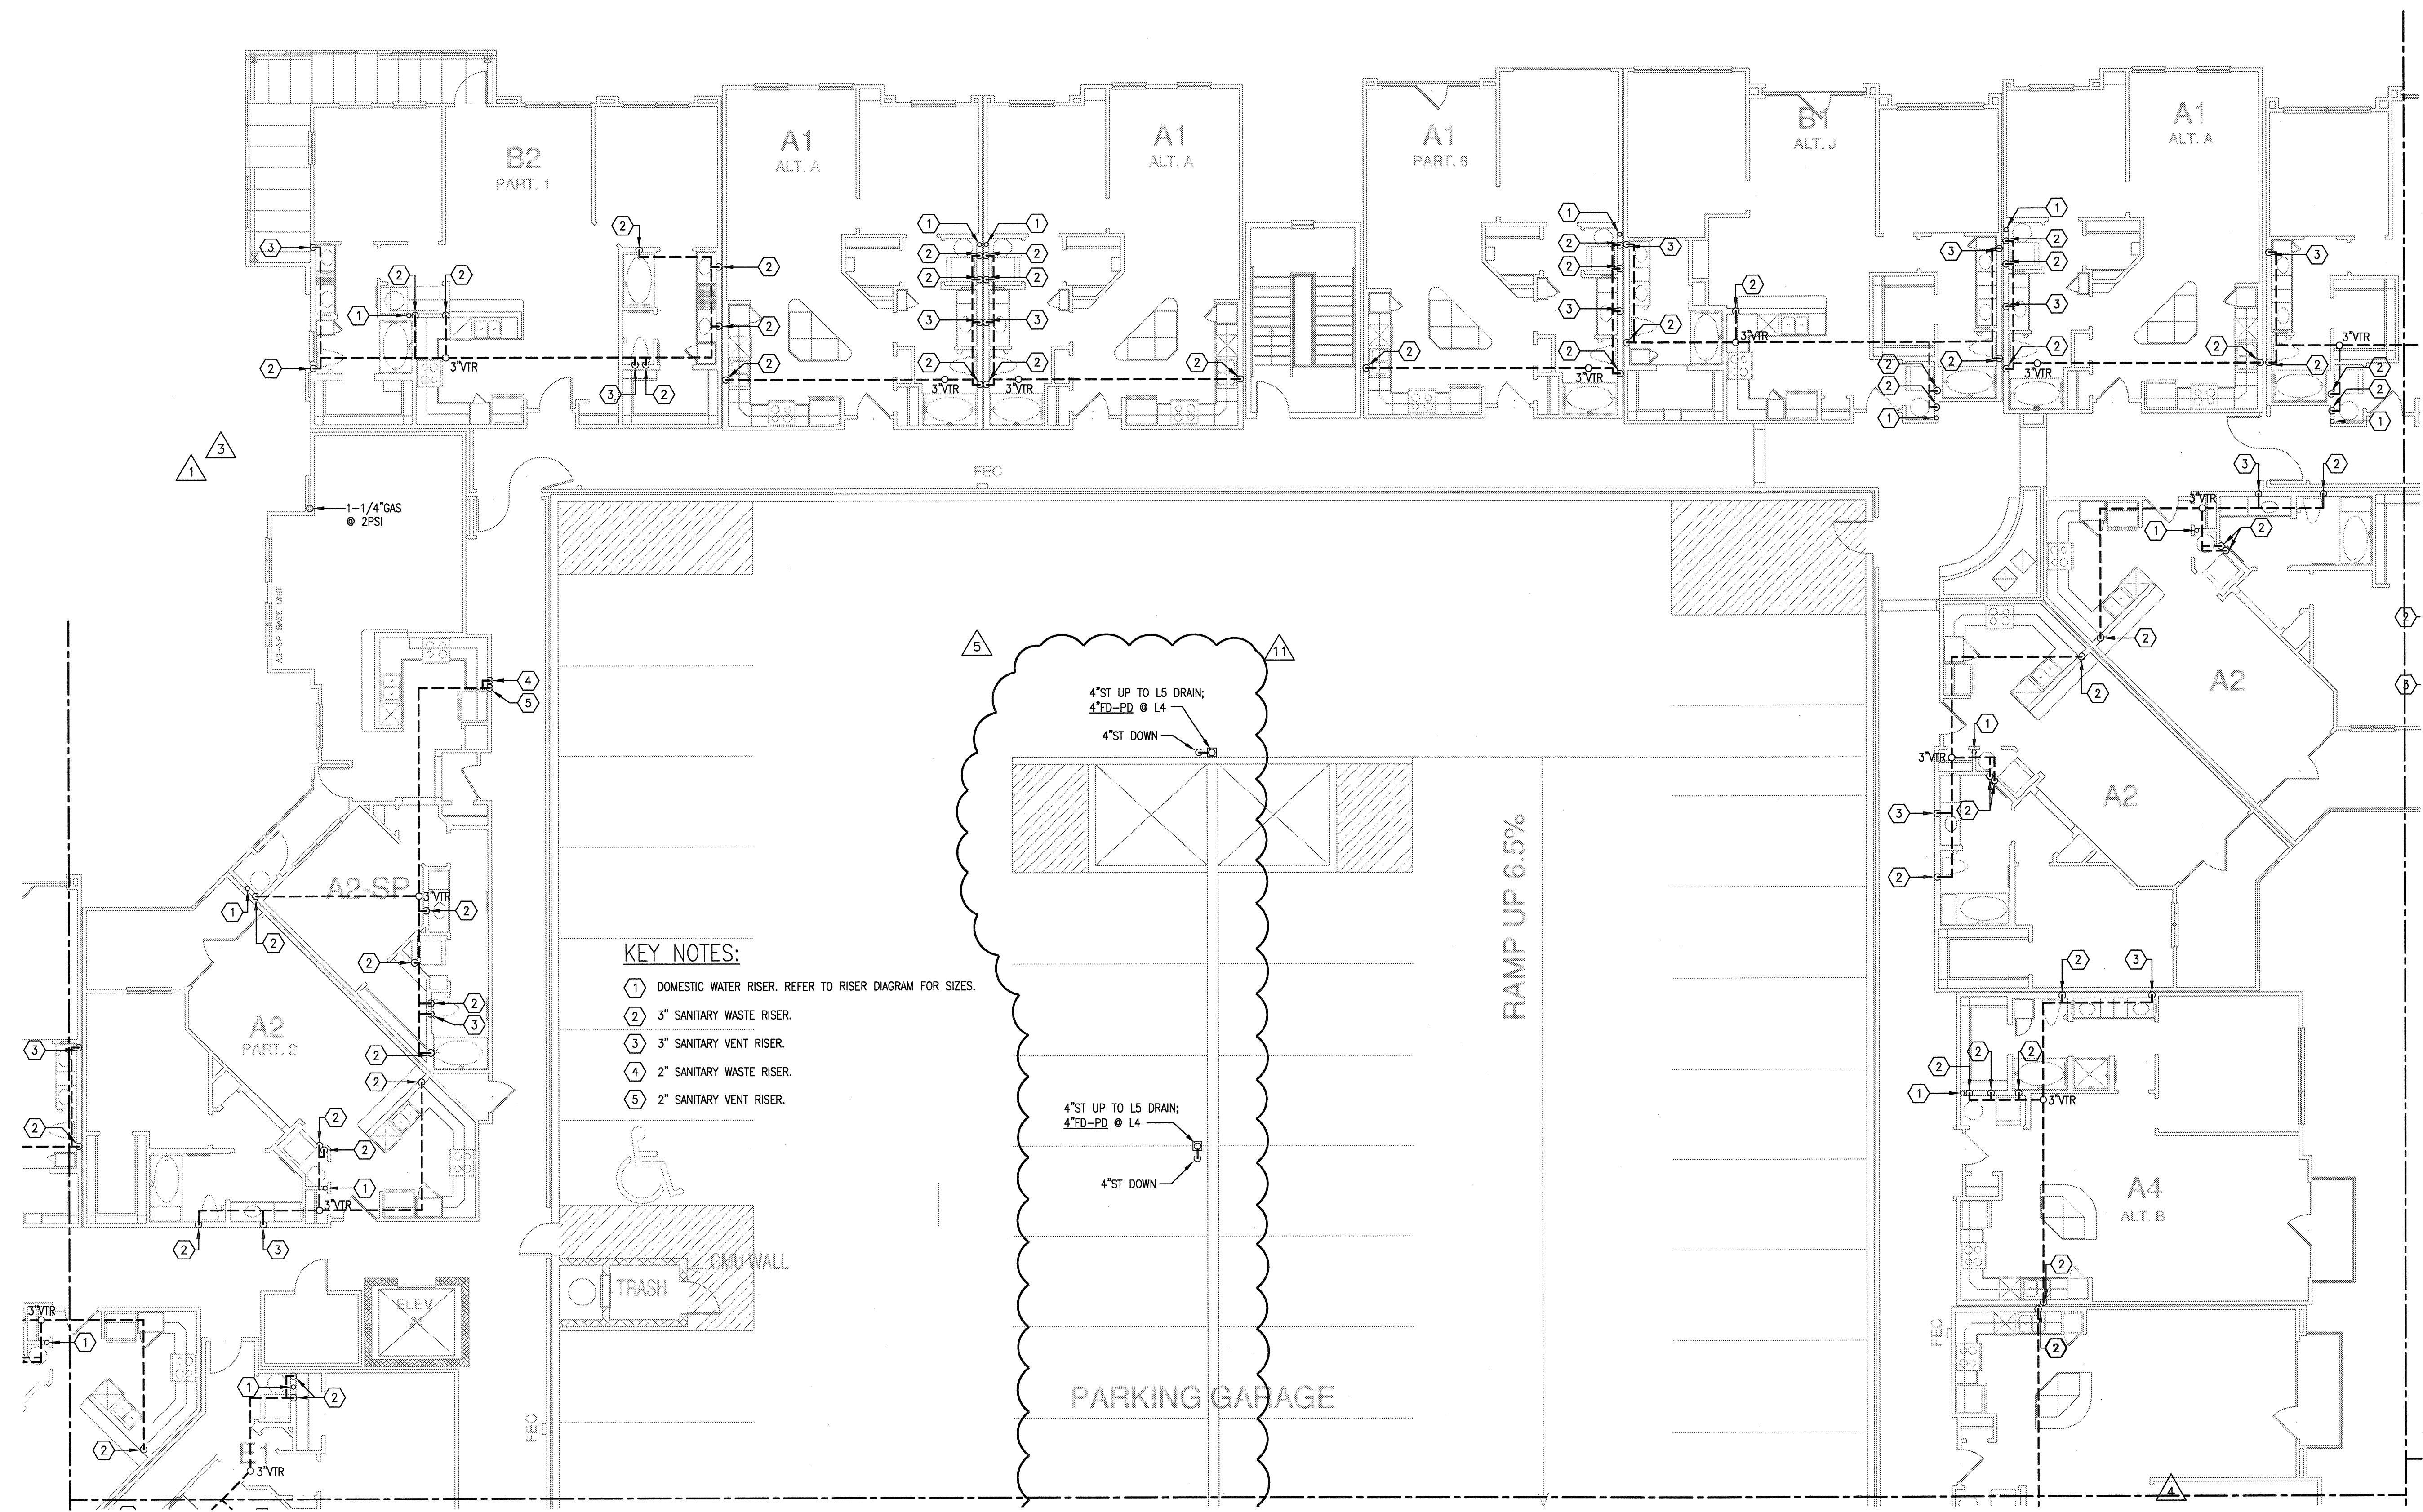

- KEY NOTES:**
- 1 DOMESTIC WATER RISER. REFER TO RISER DIAGRAM FOR SIZES.
 - 2 3" SANITARY WASTE RISER.
 - 3 3" SANITARY VENT RISER.
 - 4 2" SANITARY WASTE RISER.
 - 5 2" SANITARY VENT RISER.

1 DIVISION 'C' FOURTH FLOOR PLAN
 SCALE: 1/8" = 1'-0"

JSE Jordan & Skala Engineers
 17835 N. Dallas Parkway, Suite 330
 Dallas, TX 75287-6657
 Tel: (469) 385-1616 Web: www.jordanaskala.com
 Project Number - 113-0355 Texas Firm Registration # F-4990
 Drawn By: CV Checked By: RC