



REVISIONS		
△ 9-2-2011	DESIGN REVISIONS	
△ 9-13-2011	ANSI/FHA COMMENTS	
△ 9-23-2011	DESIGN REVISIONS	
△ 10-17-2011	CONSTRUCTION ISSUE	
△ 12-21-2011	DESIGN REVISIONS	

# KELLER SPRINGS LOFTS

LOFT APARTMENTS IN ADDISON, TEXAS



4144 N. Central Expy.  
Suite 855  
Dallas, TX 75204  
214.520.8878  
bgoarchitects.com


DATE  
08-05-11

PROJECT  
11129

SHEET NUMBER

**P-3.4D**

**JSE** Jordan & Skala Engineers  
14240 Midway Road, Suite 330  
Dallas, TX 75244-5139  
Tel: (469) 385-1616 Fax: (469) 385-1615  
Project Number - 113-0355 Texas Firm Registration # F-4990  
Drawn By: CV Checked By: RC

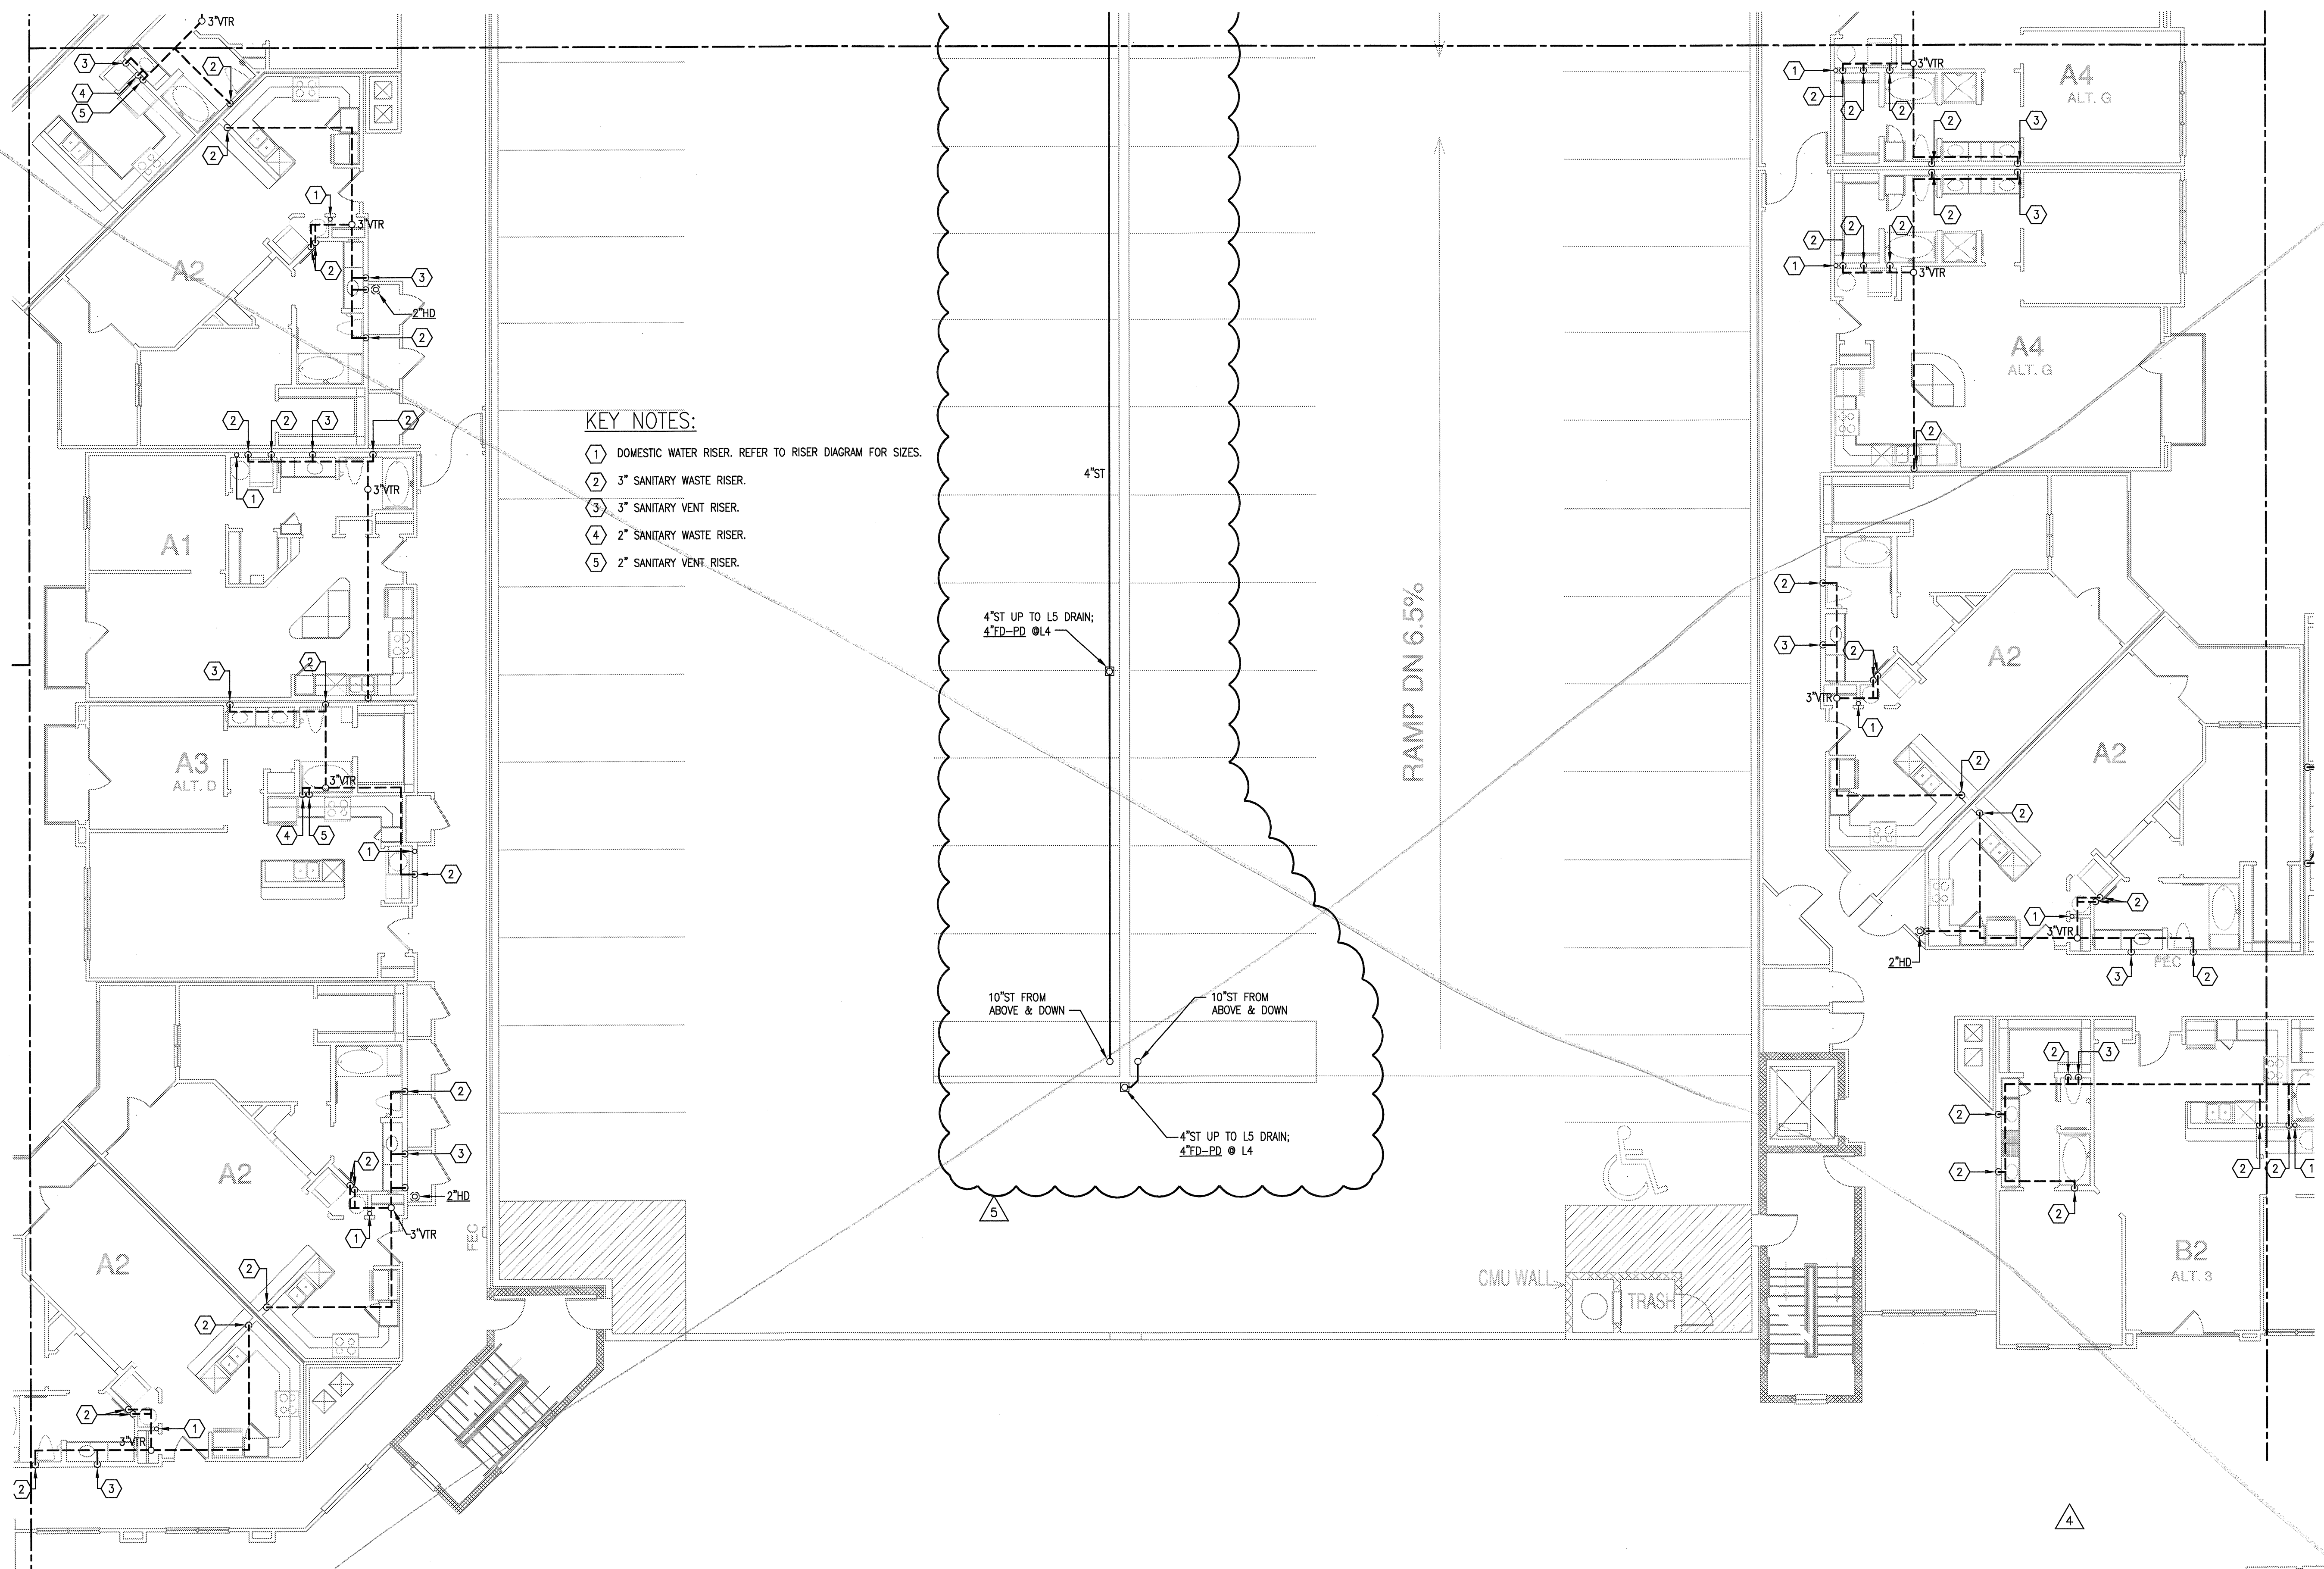

- KEY NOTES:**
- ① DOMESTIC WATER RISER. REFER TO RISER DIAGRAM FOR SIZES.
  - ② 3" SANITARY WASTE RISER.
  - ③ 3" SANITARY VENT RISER.
  - ④ 2" SANITARY WASTE RISER.
  - ⑤ 2" SANITARY VENT RISER.

1 DIVISION 'D' FOURTH FLOOR PLAN  
SCALE: 1/8" = 1'-0"