

- KEY NOTES:**
- ① DOMESTIC WATER RISER. REFER TO RISER DIAGRAM FOR SIZES.
  - ② 3" SANITARY WASTE RISER.
  - ③ 3" SANITARY VENT RISER.
  - ④ 2" SANITARY WASTE RISER.
  - ⑤ 2" SANITARY VENT RISER.



REVISIONS	
①	9-2-2011 DESIGN REVISIONS
②	9-13-2011 ANSI/FHA COMMENTS DESIGN REVISIONS
③	9-23-2011 DESIGN REVISIONS
④	10-17-2011 CONSTRUCTION ISSUE DESIGN REVISIONS
⑤	12-21-2011 DESIGN REVISIONS
⑥	1-17-2012 DESIGN REVISIONS
⑦	2-15-2012 TRANSFORMER REVISIONS
⑧	3-27-2012 CLUBHOUSE REVISIONS
⑨	4-17-2012 COORDINATION

**KELLER SPRINGS LOFTS**  
 LOFT APARTMENTS IN ADDISON, TEXAS


⑩	5-15-2012 COORDINATION
⑪	5-30-2012 SITE COORDINATION

**BGO architects**  
 4144 N. Central Expy. Suite 855  
 Dallas, TX 75204  
 214.520.8878  
 bgoarchitects.com

DATE  
 08-05-11

PROJECT  
 11129

SHEET NUMBER  
**P-3.4D**

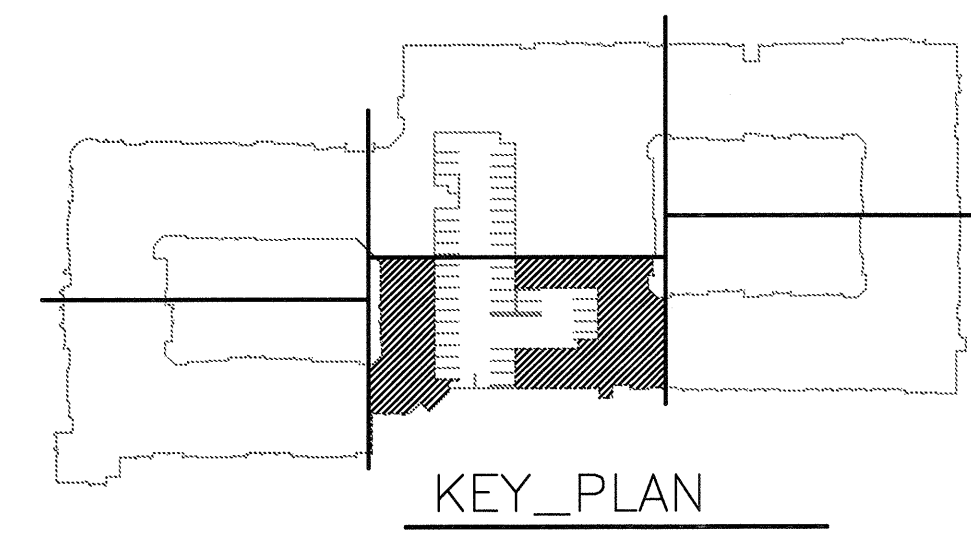

**JSE** Jordan & Skala Engineers  
 17855 N. Dallas Parkway, Suite 370  
 Dallas, TX 75287-6857  
 Project Number - 113-0355 Texas Firm Registration # F-4990  
 Drawn By: CV Checked By: RC

1 DIVISION 'D' FOURTH FLOOR PLAN  
 SCALE: 1/8" = 1'-0"