


| REVISIONS | |
|-----------|-------------------------------|
| 1 | 9-2-2011 DESIGN REVISIONS |
| 2 | 9-13-2011 ANSI/FHA COMMENTS |
| 3 | 9-23-2011 DESIGN REVISIONS |
| 4 | 10-17-2011 CONSTRUCTION ISSUE |

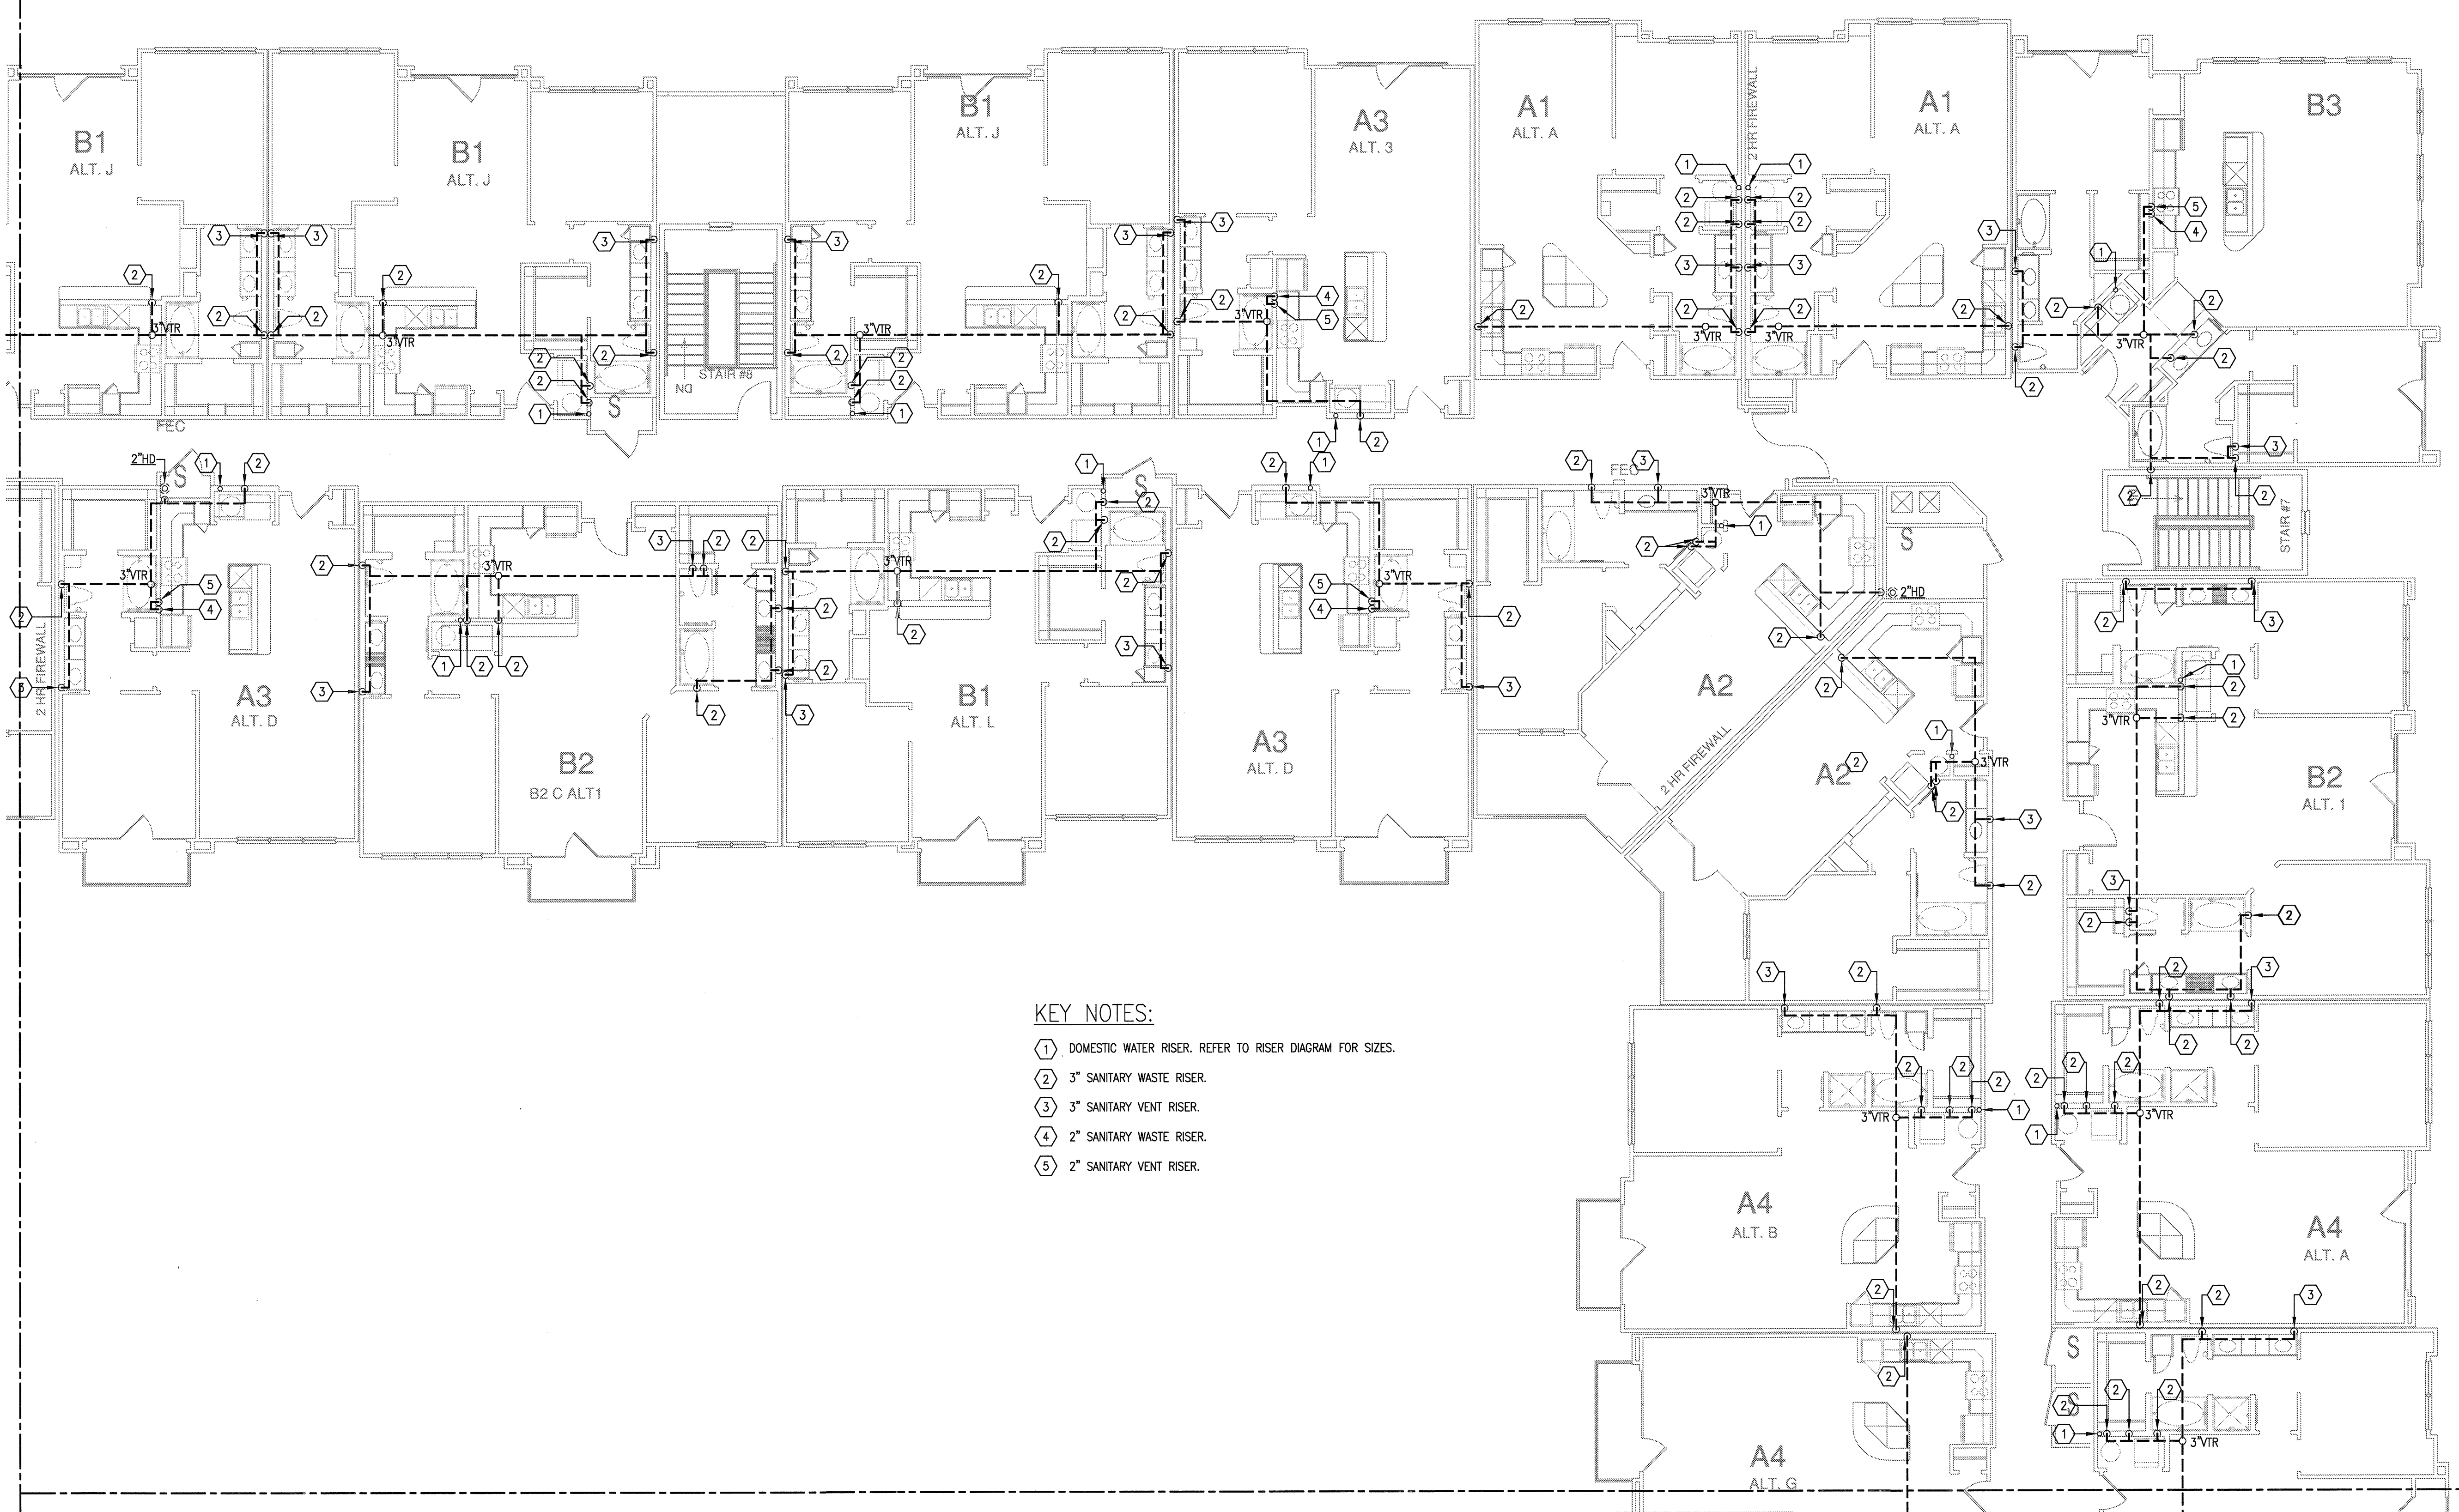

- KEY NOTES:**
- 1 DOMESTIC WATER RISER. REFER TO RISER DIAGRAM FOR SIZES.
 - 2 3" SANITARY WASTE RISER.
 - 3 3" SANITARY VENT RISER.
 - 4 2" SANITARY WASTE RISER.
 - 5 2" SANITARY VENT RISER.

KELLER SPRINGS LOFTS

LOFT APARTMENTS IN ADDISON, TEXAS

BGO
architects


4144 N. Central Exp., Suite 855
Dallas, TX 75204
214.520.8878
bgoarchitects.com

DATE
08-05-11

PROJECT
11129

SHEET NUMBER

P-3.4E

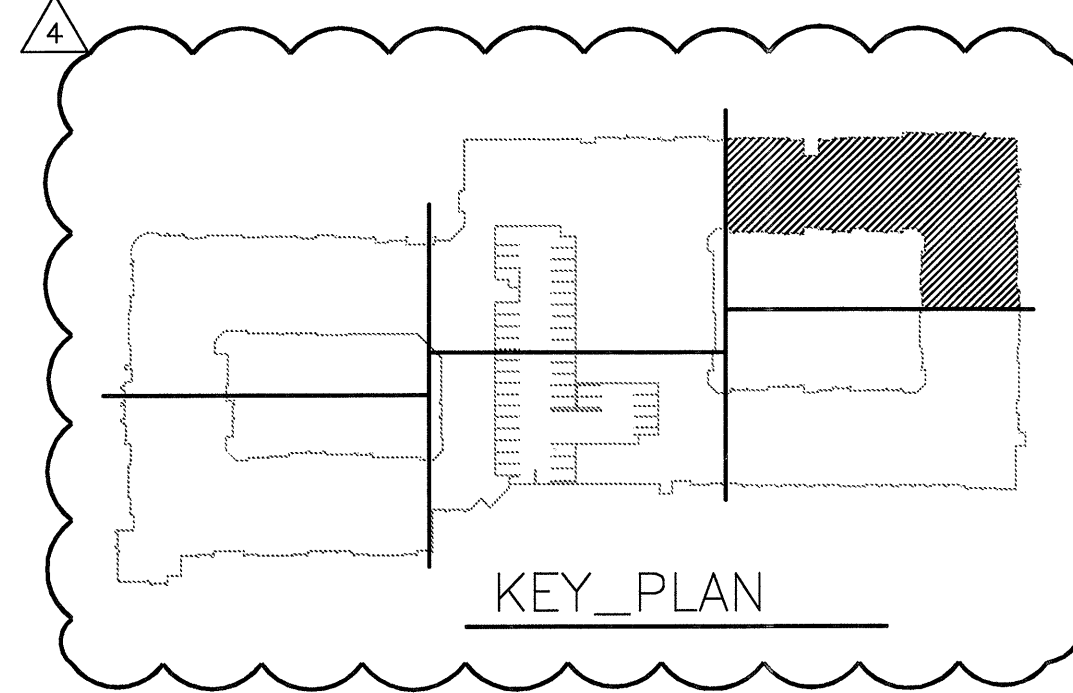

1 DIVISION 'E' FOURTH FLOOR PLAN
SCALE: 1/8" = 1'-0"

JSE Jordan & Skala Engineers
14240 Midway Road, Suite 350
Dallas, TX 75244-3138
V: (469) 385-1629 F: (469) 385-1615
Project Number - 113-0355 Texas Firm Registration # F-4990
Drawn By: CV Checked By: RC