

DOMESTIC BOOSTER PUMP SCHEDULE

PUMP	MANUFACTURER	MODEL NO.	GPM	HEAD	HP	SPEED	POWER
P-1	TIGERFLOW	--	187	92'	7.5	3500	208-60-3
P-2	TIGERFLOW	--	187	92'	7.5	3500	208-60-3
P-3	TIGERFLOW	--	187	92'	7.5	3500	208-60-3


DOMESTIC BOOSTER NOTES:

NOTE 1: SYSTEM IS SUPPLIED WITH DOUBLE ENDED HEADERS FOR FLOW IN EITHER DIRECTION.

NOTE 2: SYSTEM IS SUPPLIED WITH RUBBER IN SHEAR VIBRATION MOUNTS & SINGLE SPHERE FLEXIBLE CONNECTORS OR S/S BRAID TO SUIT THE SYSTEM WORKING PRESSURE.

FIRE PUMP SCHEDULE

PUMP	MANUFACTURER	MODEL NO.	GPM	HEAD	HP	SPEED	POWER
F/P	TIGERFLOW	--	1000	207'	100	1750 MAX	208-60-3
J/P	TIGERFLOW	--	12	207'	1.5	3500	208-60-3

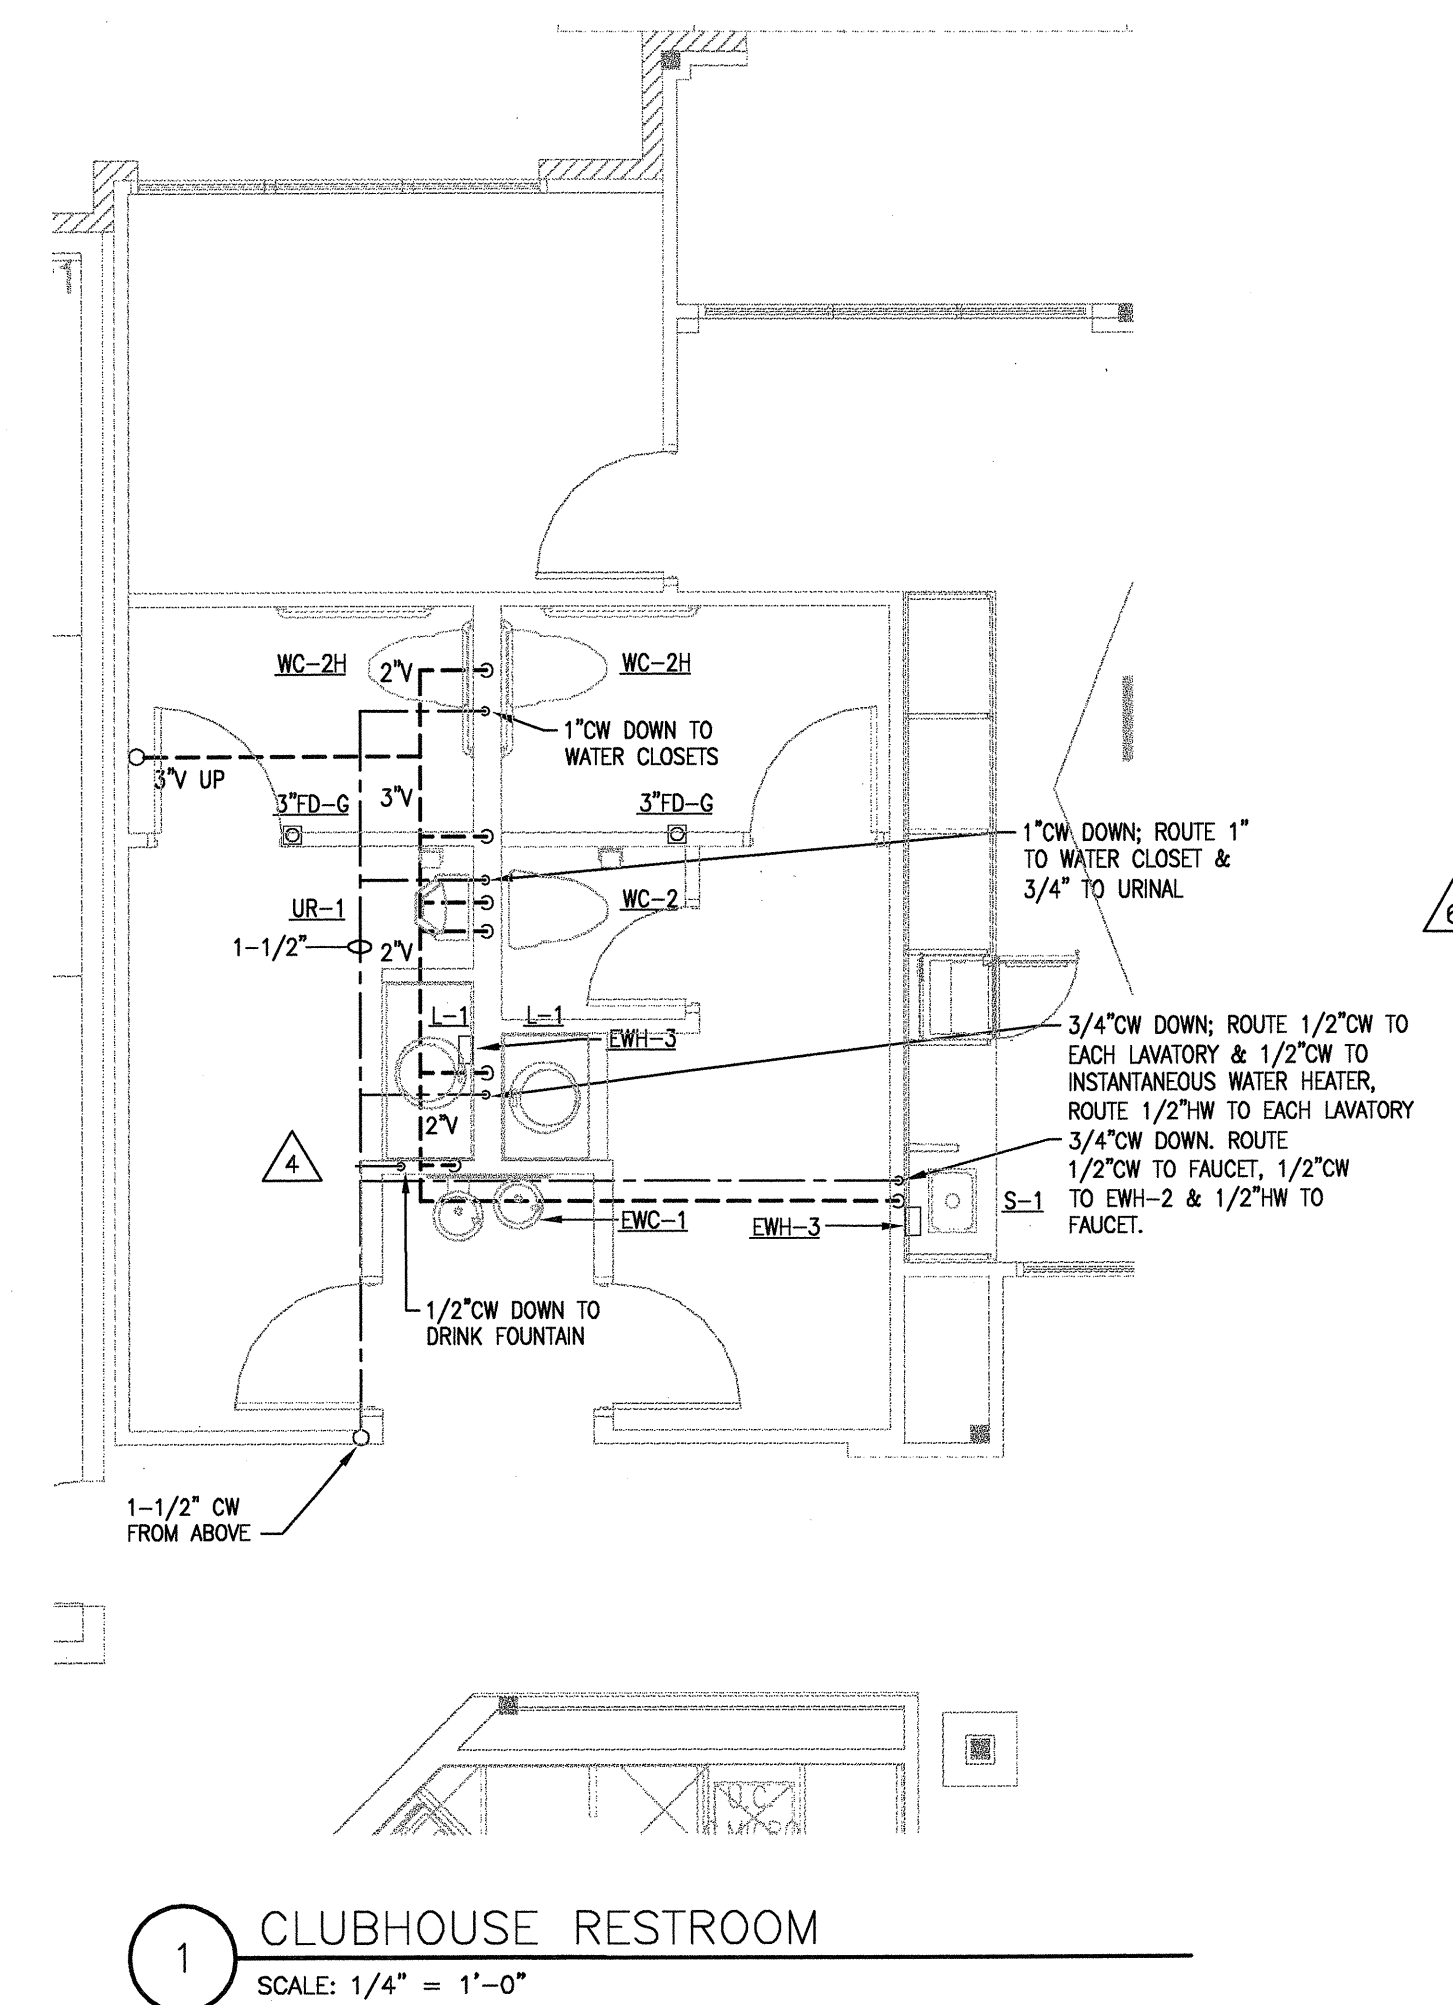

REVISIONS

NO.	DATE	DESCRIPTION
1	9-2-2011	DESIGN REVISIONS
2	9-13-2011	ANSI/FHA COMMENTS
3	9-23-2011	DESIGN REVISIONS
4	10-17-2011	CONSTRUCTION ISSUE
5	12-21-2011	DESIGN REVISIONS
6	1-17-2012	DESIGN REVISIONS
7	2-15-2012	TRANSFORMER REVISIONS

KELLER SPRINGS LOFTS

LOFT APARTMENTS IN ADDISON, TEXAS



4144 N. Central Expy.
Suite 855
Dallas, TX 75204
214.520.8878
bgoarchitects.com

DATE
08-05-11

PROJECT
11129

SHEET NUMBER
P-9.1