

FIRE ALARM PLAN FIRST FLOOR - BLDG 1
 SCALE: 1/16" = 1'-0"
 NORTH

KEYED NOTES:


- 1 All wiring in stairways shall be installed in conduit. See Electrical specifications for conduit requirements.
- 2 Install on ceiling adjacent to in-room smoke detector (SD) & connect to Aux. relay in SD base.
- 3 Connect to EIA-485 in FACP (Two 16ga Twisted, Pair Shielded Cable)
- 4 Connect to 24 VDC Aux. Pwr. in FACP

S2 PAR
 NO FIR
 REQUIR
 ARTIC

NAC TO RISER RM

NAC WIRE SIZE - 14 GAUGE
 SLC WIRE SIZE - 16 GAUGE

ISSUED FOR APPROVAL
 Philip R. Haight, P.E. #21366
 Fire Protection Engineering, LLC
 Registration No. F-2535
 Date: 7/13/2012

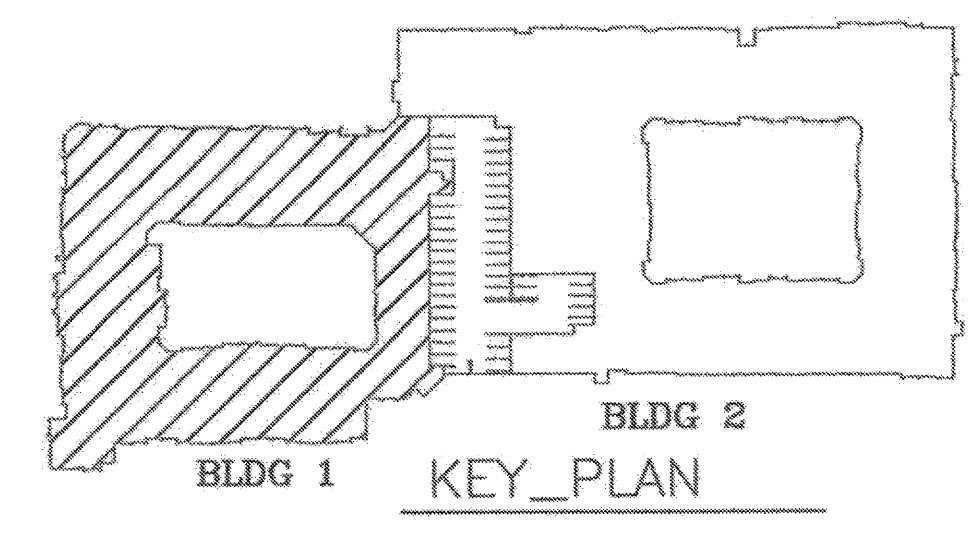

DRAWN BY: PRH
APPROVED BY: FDH
ENGINEER: Fire Protection Engineering, L.L.C. P.O. Box 160836 Austin, TX 78716 512/328-1717 TBPE Firm F-2535
<p>▲ Project: Keller Springs Lofts 4800 Keller Springs Road Addison, Texas 75001</p>
<p>Installer: Christian Cable Group, Inc. 1150 Blue Mound Road W. ste 301 Haslet, TX 76062 817-439-5107</p> <p style="text-align: right;">ACR-3219</p>
<p>Revisions: ▲ 7/13/2012 Revised project address.</p>
<p>SCALE: Noted</p>
<p>DATE: 6/29/2012</p>
<p>DRAWING NO. FA 2</p>
<p>SHEET NO. 2 OF 11</p>