
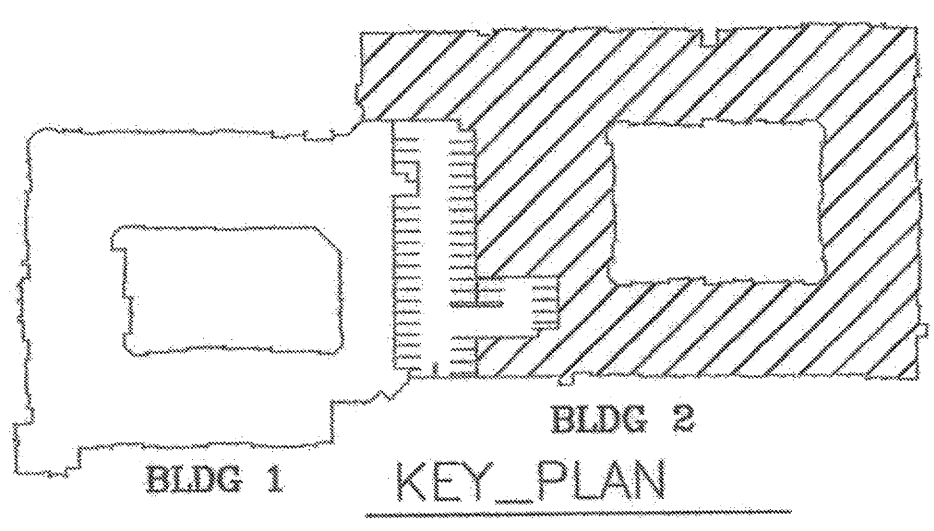


FIRE ALARM PLAN FIRST FLOOR BLDG 2
 SCALE: 1/16" = 1'-0"
 NORTH

NAC WIRE SIZE - 14 GAUGE
 SLC WIRE SIZE - 16 GAUGE

ISSUED FOR APPROVAL
 Philip R. Hought, P.E. #21366
 Fire Protection Engineering, LLC
 Registration No. F-2535
 Date: 7/13/2012

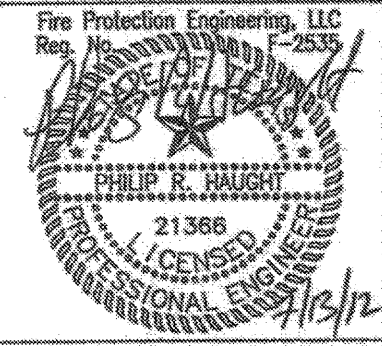

DRAWN BY: PRH
APPROVED BY: FDH
ENGINEER: Fire Protection Engineering, L.L.C. P.O. Box 160836 Austin, TX 78716 512/328-1717 TBPE Firm F-2535

Project: Keller Springs Lofts 4800 Keller Springs Road Addison, Texas 75001
Installer: Christian Cable Group, Inc. 1150 Blue Mound Road W. Ste 301 Haslet, TX 76052 817-439-5107
Revisions: 7/13/2012 Revised project address.
SCALE: Noted
DATE: 6/29/2012
DRAWING NO. FA 3
SHEET NO. 3 OF 11