


FIRE ALARM PLAN SECOND FLOOR BLDG 2
 SCALE: 1/16" = 1'-0"

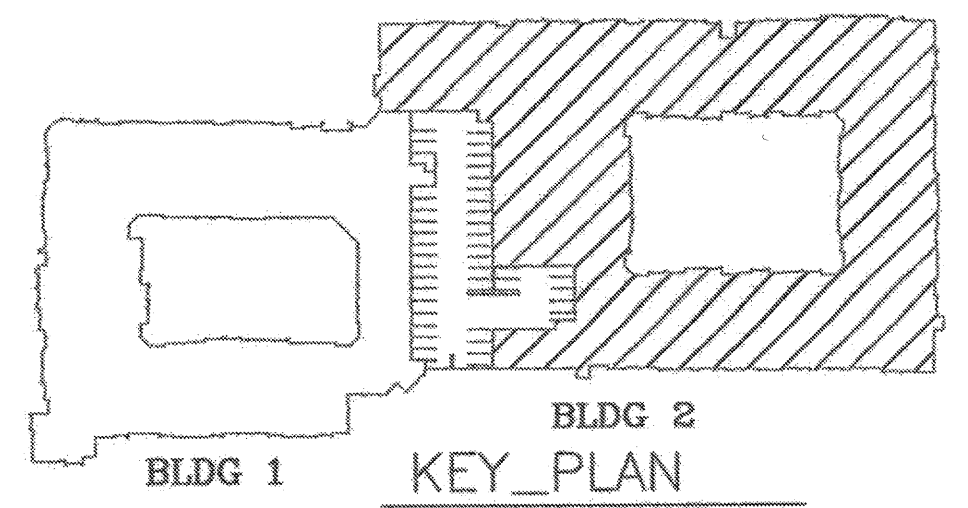

NAC WIRE SIZE - 14 GAUGE
 SLC WIRE SIZE - 16 GAUGE

ISSUED FOR APPROVAL
 Philip R. Hought, P.E. #21366
 Fire Protection Engineering, LLC
 Registration No. F-2535
 Date: 7/13/2012

DRAWN BY:	PRH
APPROVED BY:	FDH
ENGINEER:	Fire Protection Engineering, L.L.C. P.O. Box 160836 Austin, TX 78716 512/328-1717 TBPE Firm F-2535
Project:	Keller Springs Lofts 4800 Keller Springs Road Addison, Texas 75001
Installer:	Christian Cable Group, Inc. 1150 Blue Mound Road W. ste 301 Haslet, TX 78052 817-439-5107
Revisions:	7/13/2012 Revised project address.
SCALE:	Noted
DATE:	6/29/2012
DRAWING NO.	FA 5
SHEET NO.	5 OF 11