


FIRE ALARM PLAN THIRD FLOOR BLDG 2

SCALE: 1/16" = 1'-0"



NAC WIRE SIZE - 14 GAUGE
 SLC WIRE SIZE - 16 GAUGE

ISSUED FOR APPROVAL
 Philip R. Hought, P.E. #21366
 Fire Protection Engineering, LLC
 Registration No. F-2535
 Date: 7/13/2012

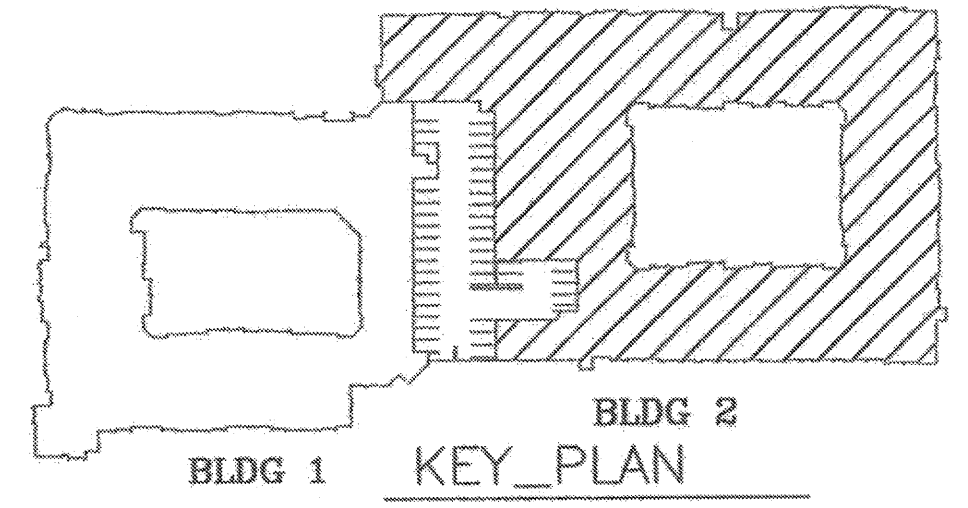

DRAWN BY:
 PRH
 APPROVED BY:
 FDH
 ENGINEER:
 Fire Protection Engineering, L.L.C.
 P.O. Box 160896
 Austin, TX 78716
 512/328-1717
 TBPE Firm F-2535

Project:
 Keller Springs Lofts
 4800 Keller Springs Road
 Addison, Texas 75001

Installer:
 Christian Cable Group, Inc.
 1150 Blue Mound Road W. ste 301
 Haslet, TX 76052
 817-439-5107

Revisions:
 7/13/2012 Revised project address.

SCALE:
 Noted

DATE:
 6/29/2012

DRAWING NO.
 FA 7

SHEET NO. 7 OF 11