


FIRE ALARM PLAN FOURTH FLOOR BLDG 1

SCALE: 1/16" = 1'-0"



NAC WIRE SIZE - 14 GAUGE
SLC WIRE SIZE - 16 GAUGE

ISSUED FOR APPROVAL
Philip R. Hought, P.E. #21366
Fire Protection Engineering, LLC
Registration No. F-2535
Date: 7/13/2012

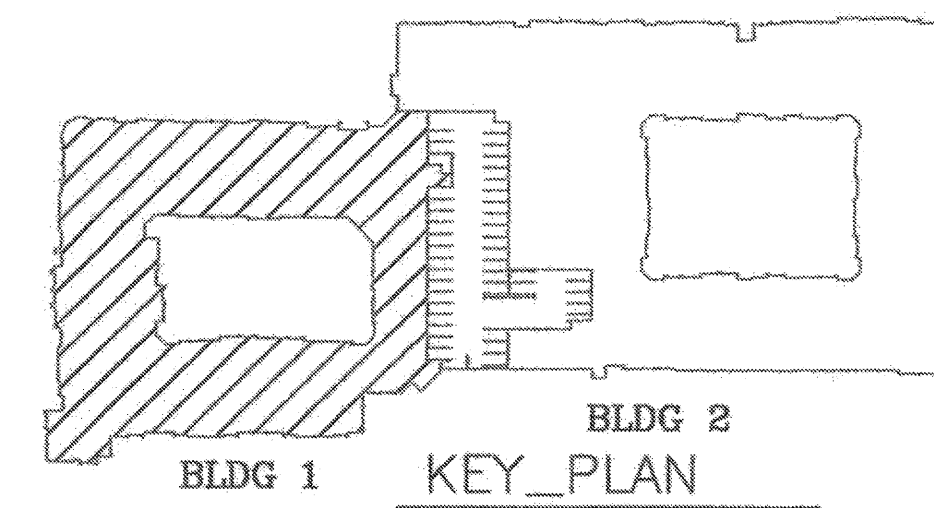

DRAWN BY:	PRH
APPROVED BY:	FDH
ENGINEER:	Fire Protection Engineering, L.L.C. P.O. Box 180836 Austin, TX 78716 512/328-1717 TBPE Firm F-2535
Project:	Keller Springs Lofts 4800 Keller Springs Road Addison, Texas 75001
Installer:	Christian Cable Group, Inc. 1150 Blue Mound Road W. ste 301 Haslet, TX 76052 817-439-5107 ACR-3219
Revisions:	7/13/2012 Revised project address.
SCALE:	Noted
DATE:	6/29/2012
DRAWING NO.	FA 8
SHEET NO.	8 OF 11