

155.42'

155'-5"

93.83'

35'-0"

1 1/2"

35'-0"

4"

27'-0"

1 1/2"

18'-4"

5'-10"


1 1/2"

5'-2"

29'-4"

1 1/2"

SECTION A
SECTION B

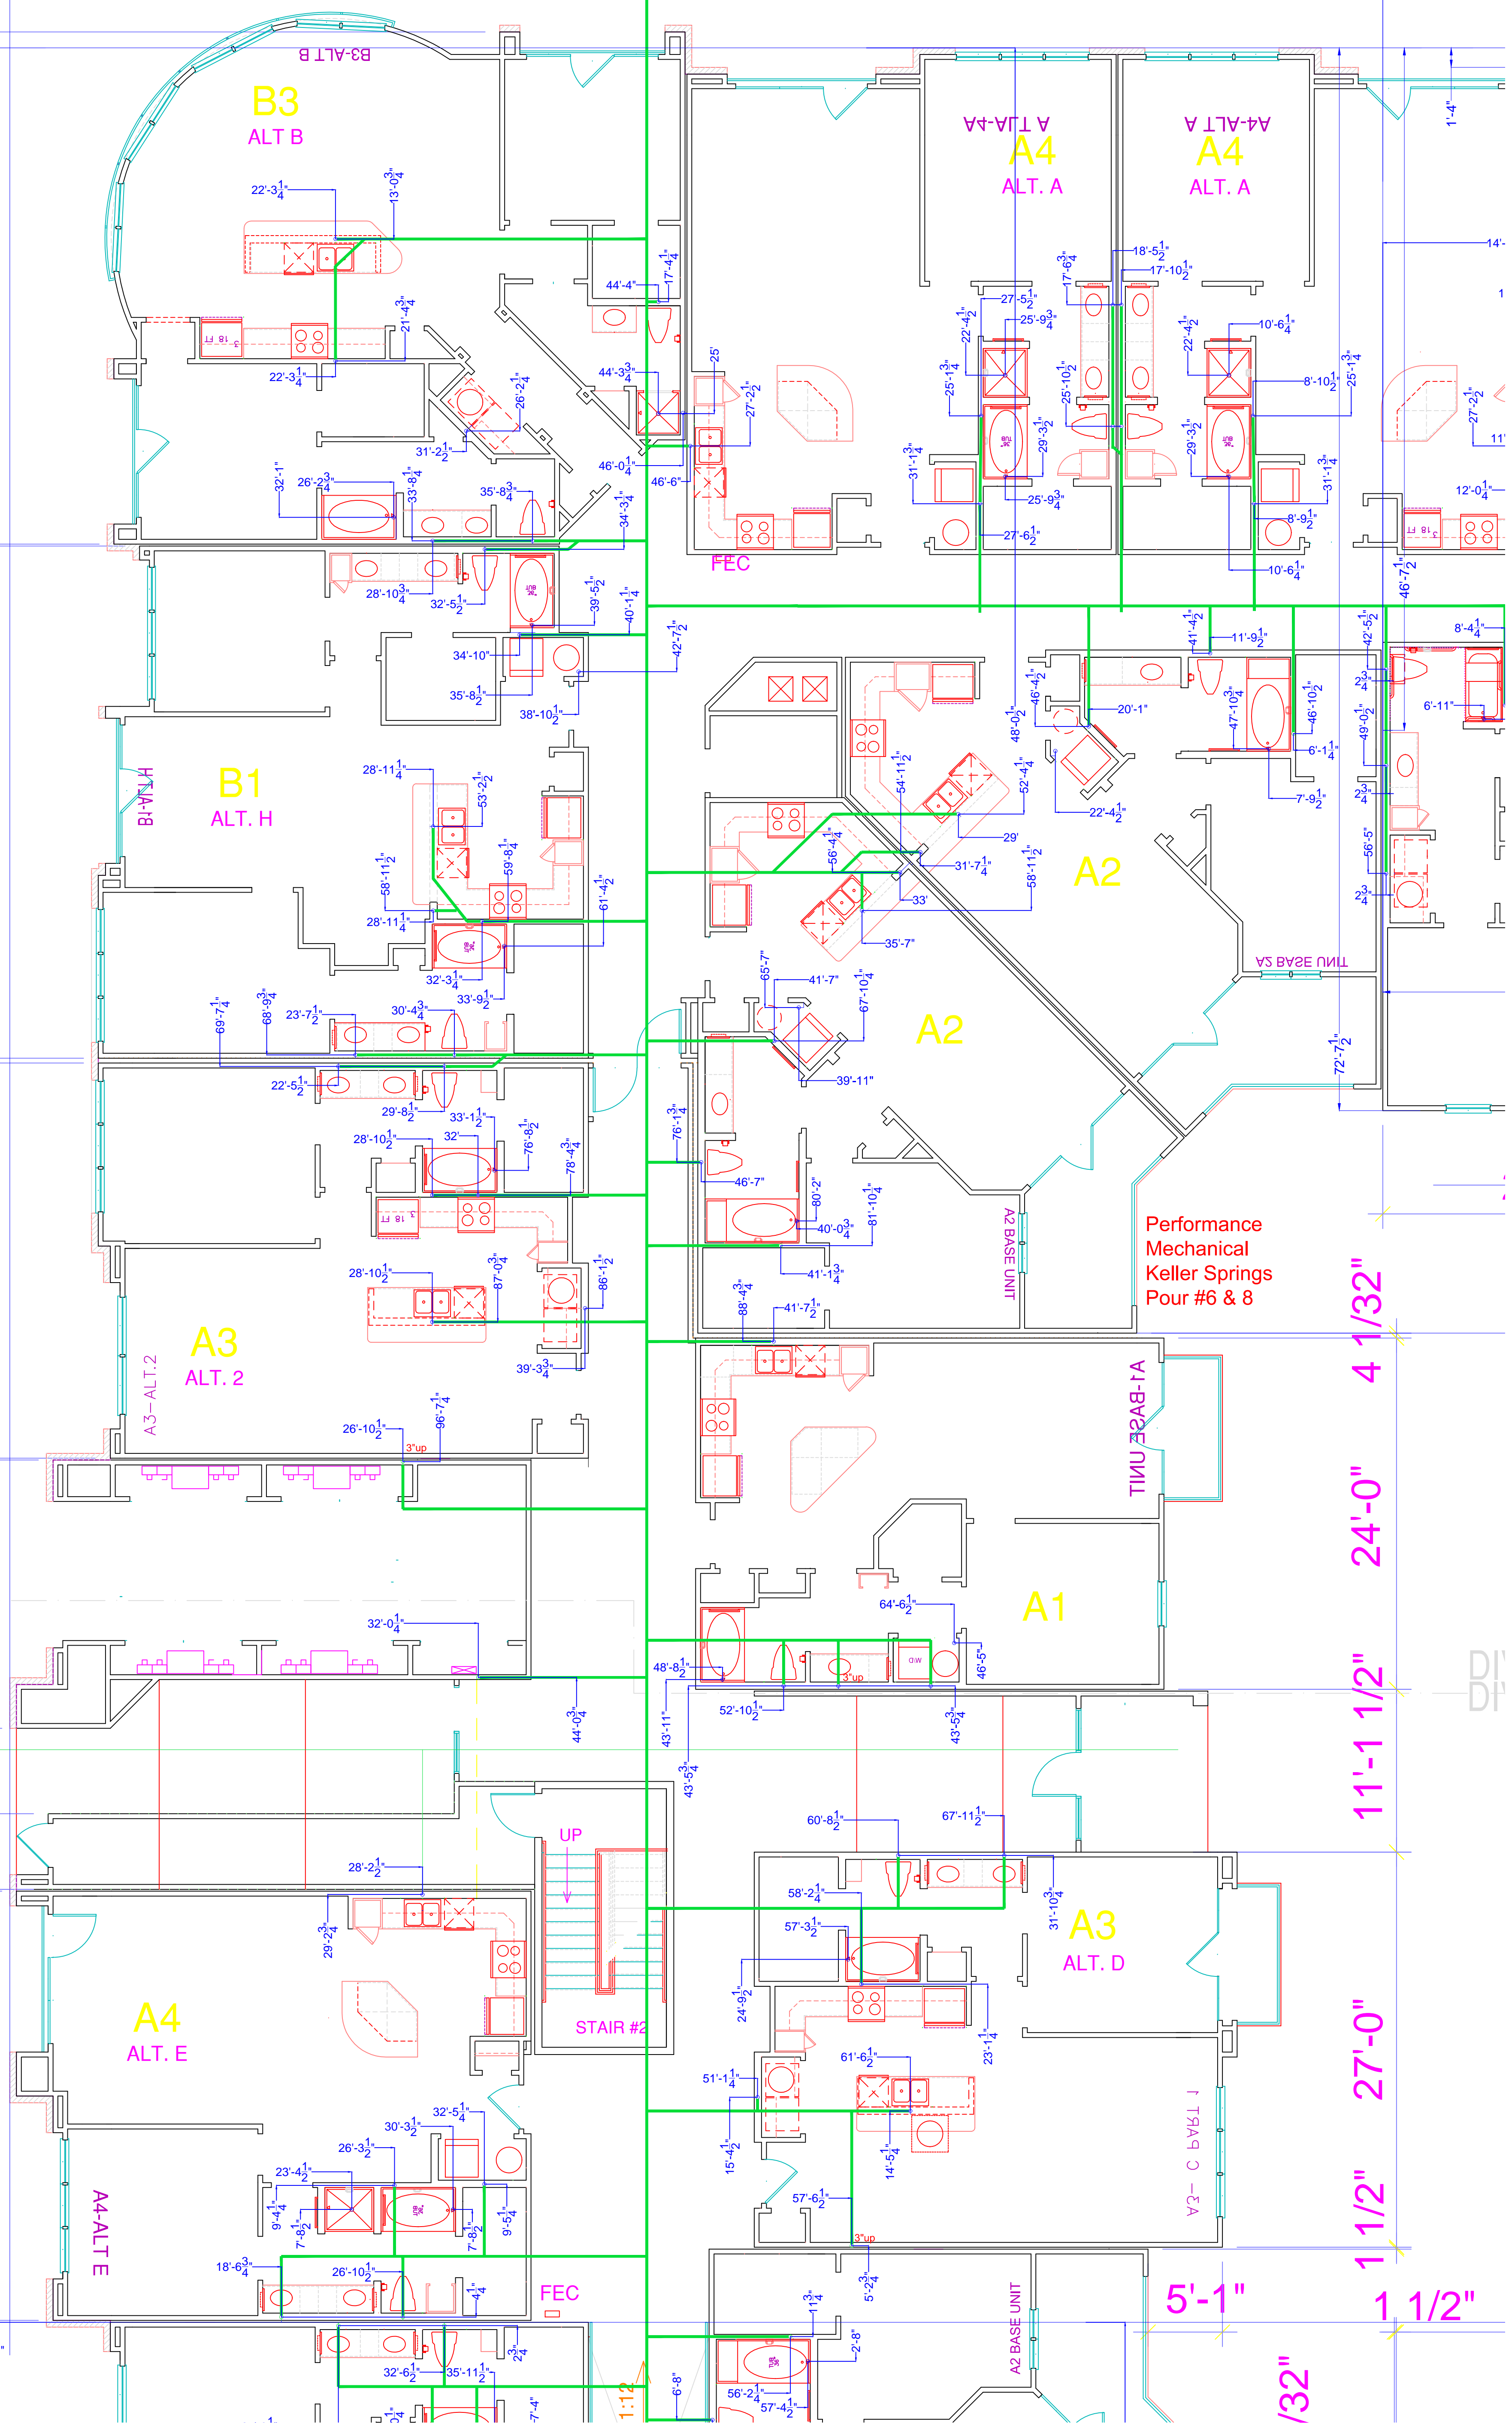

4 1/32"

24'-0"

11'-1 1/2"

27'-0"

1 1/2"

5'-1"

1/32"

Performance Mechanical Keller Springs Pour #6 & 8

A1 BASE UNIT

A2 BASE UNIT

A3 BASE UNIT

A4 BASE UNIT

A5 BASE UNIT

A6 BASE UNIT

SECTION C

SECTION D

SECTION E

SECTION F

SECTION G

SECTION H

SECTION I

SECTION J

99.83'

1 1/2"

27'-0"

4"

35'-0"

1 1/2"

39'-0 1/2"

38'-6 1/2"

3" 9'-6" 3"

35'-0"

1 1/2"

35'-0"

1 1/2"

35'-0"


4" 4" 9'-11"

35'-0"


1 1/2"


233.79'

Performance
Mechanical
Keller Springs
Pour #10, 9 & 11

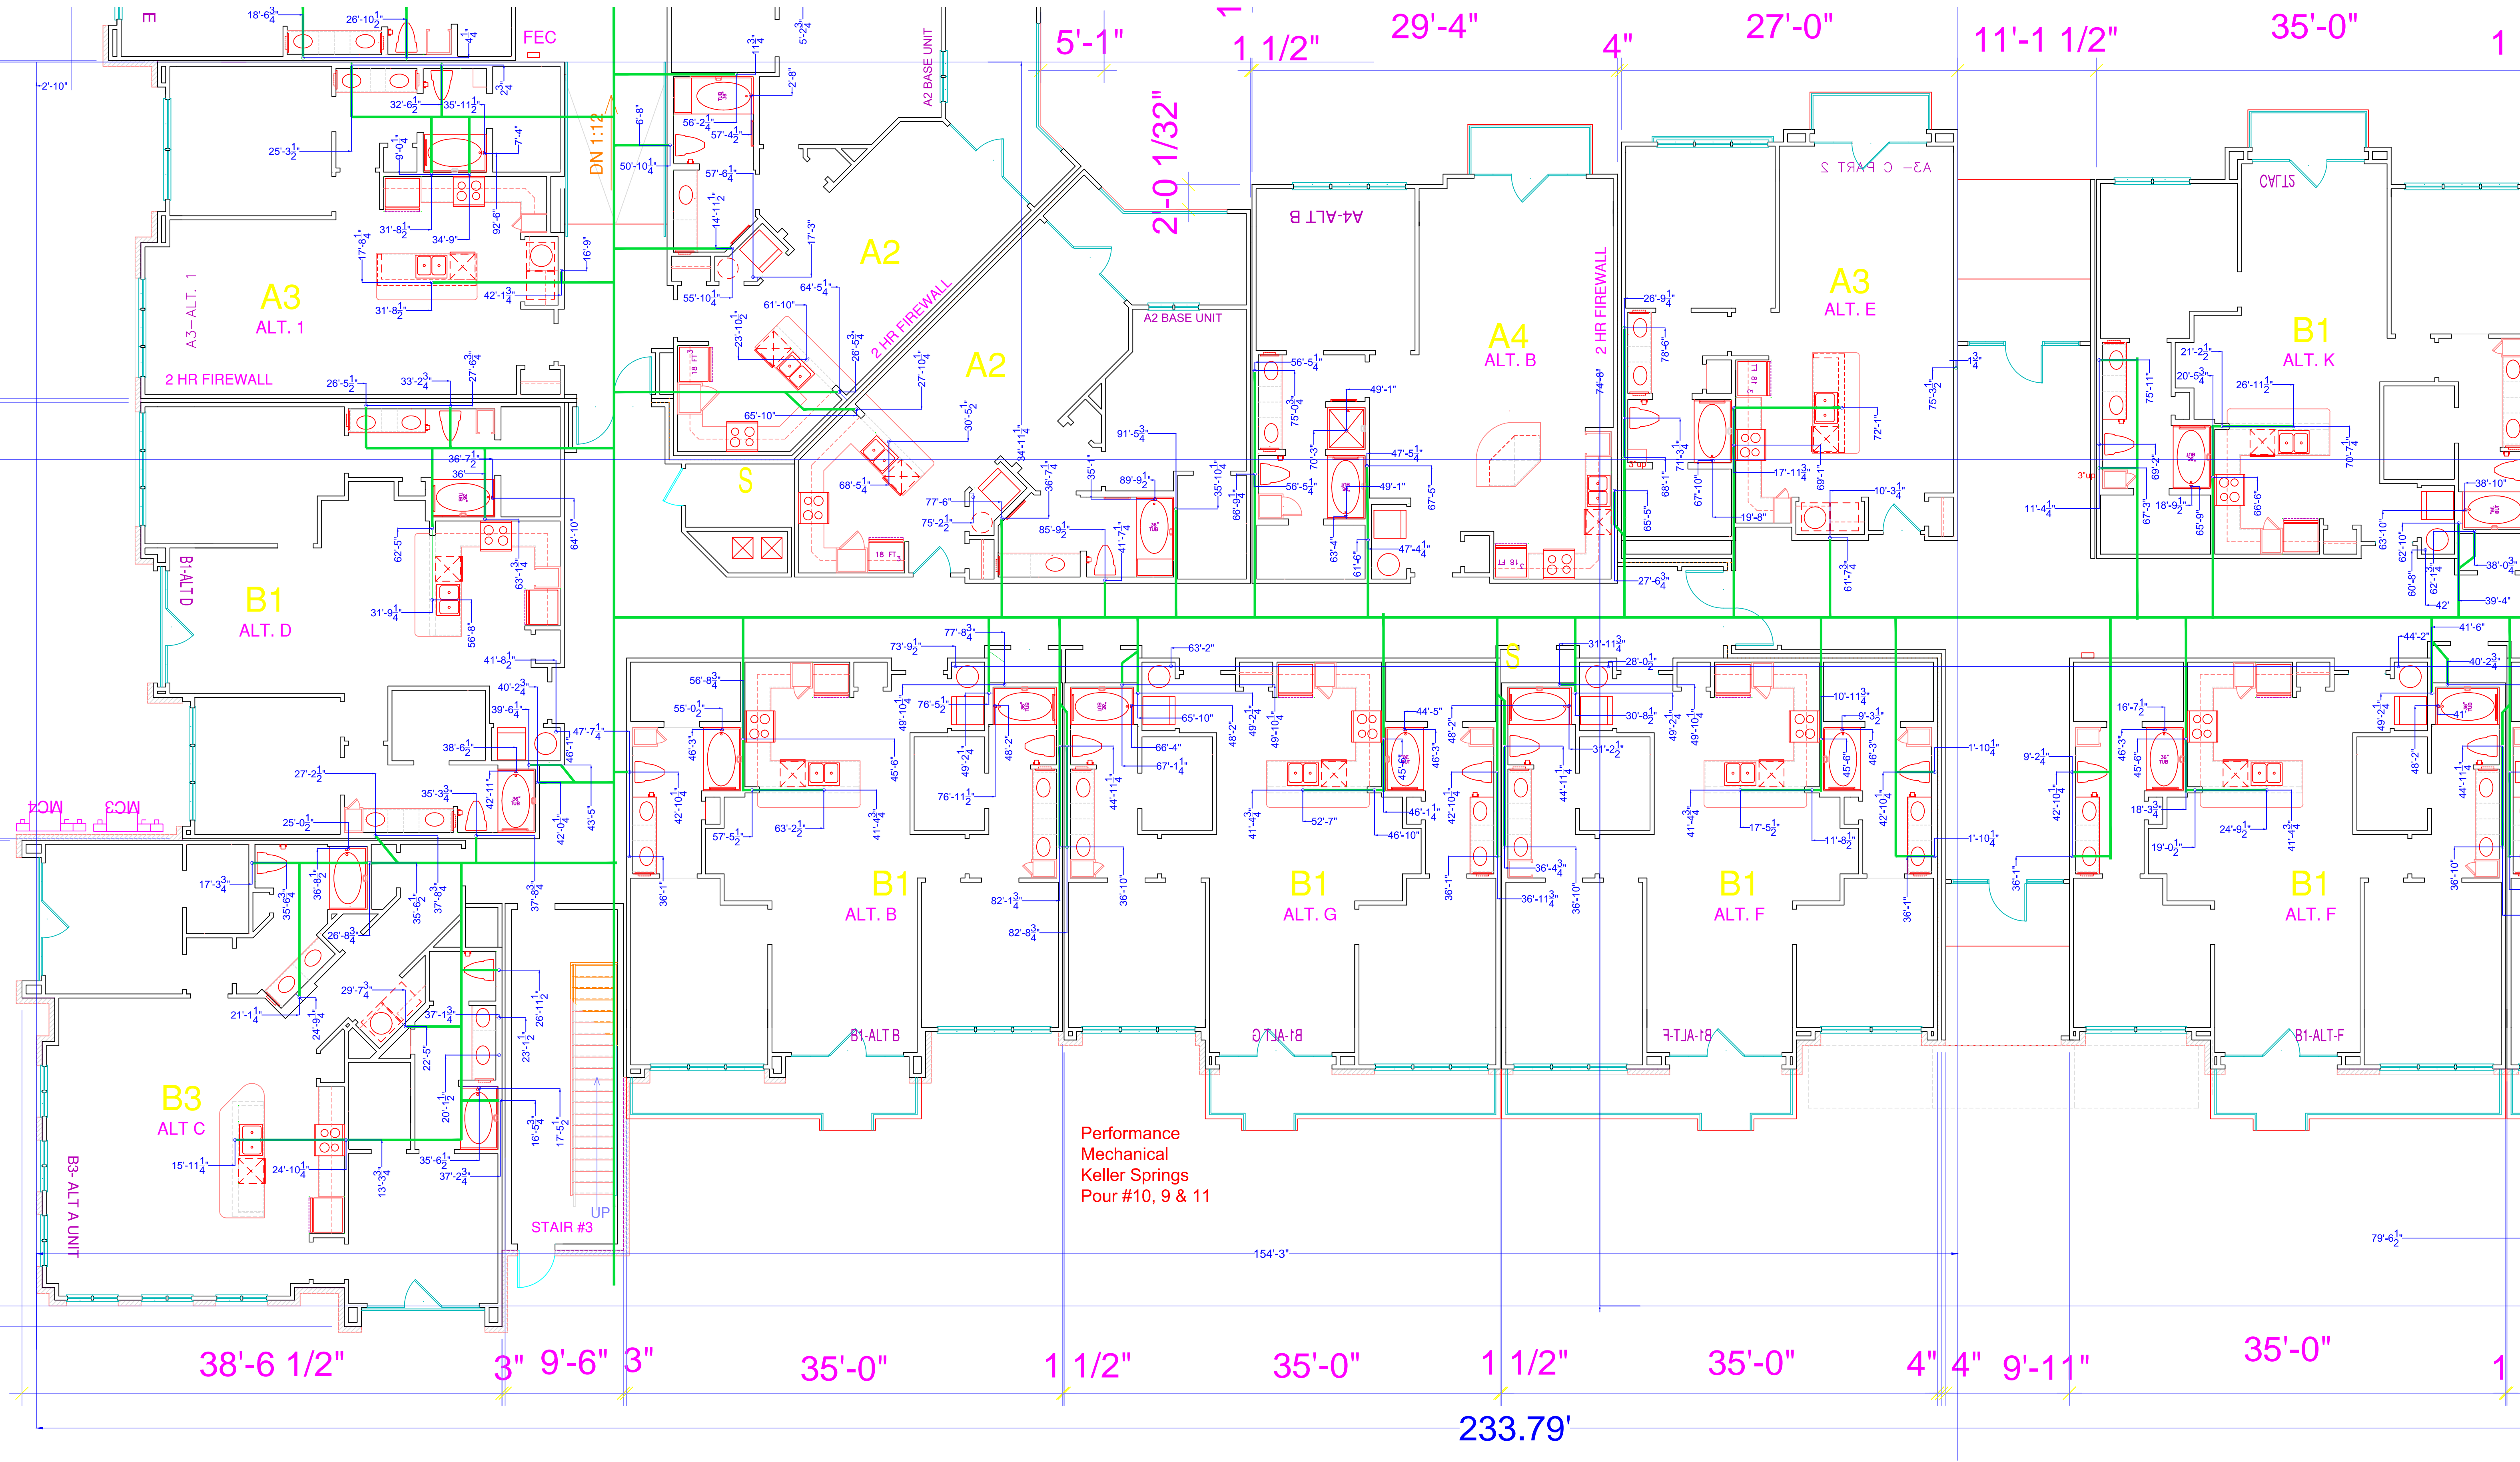

ARD

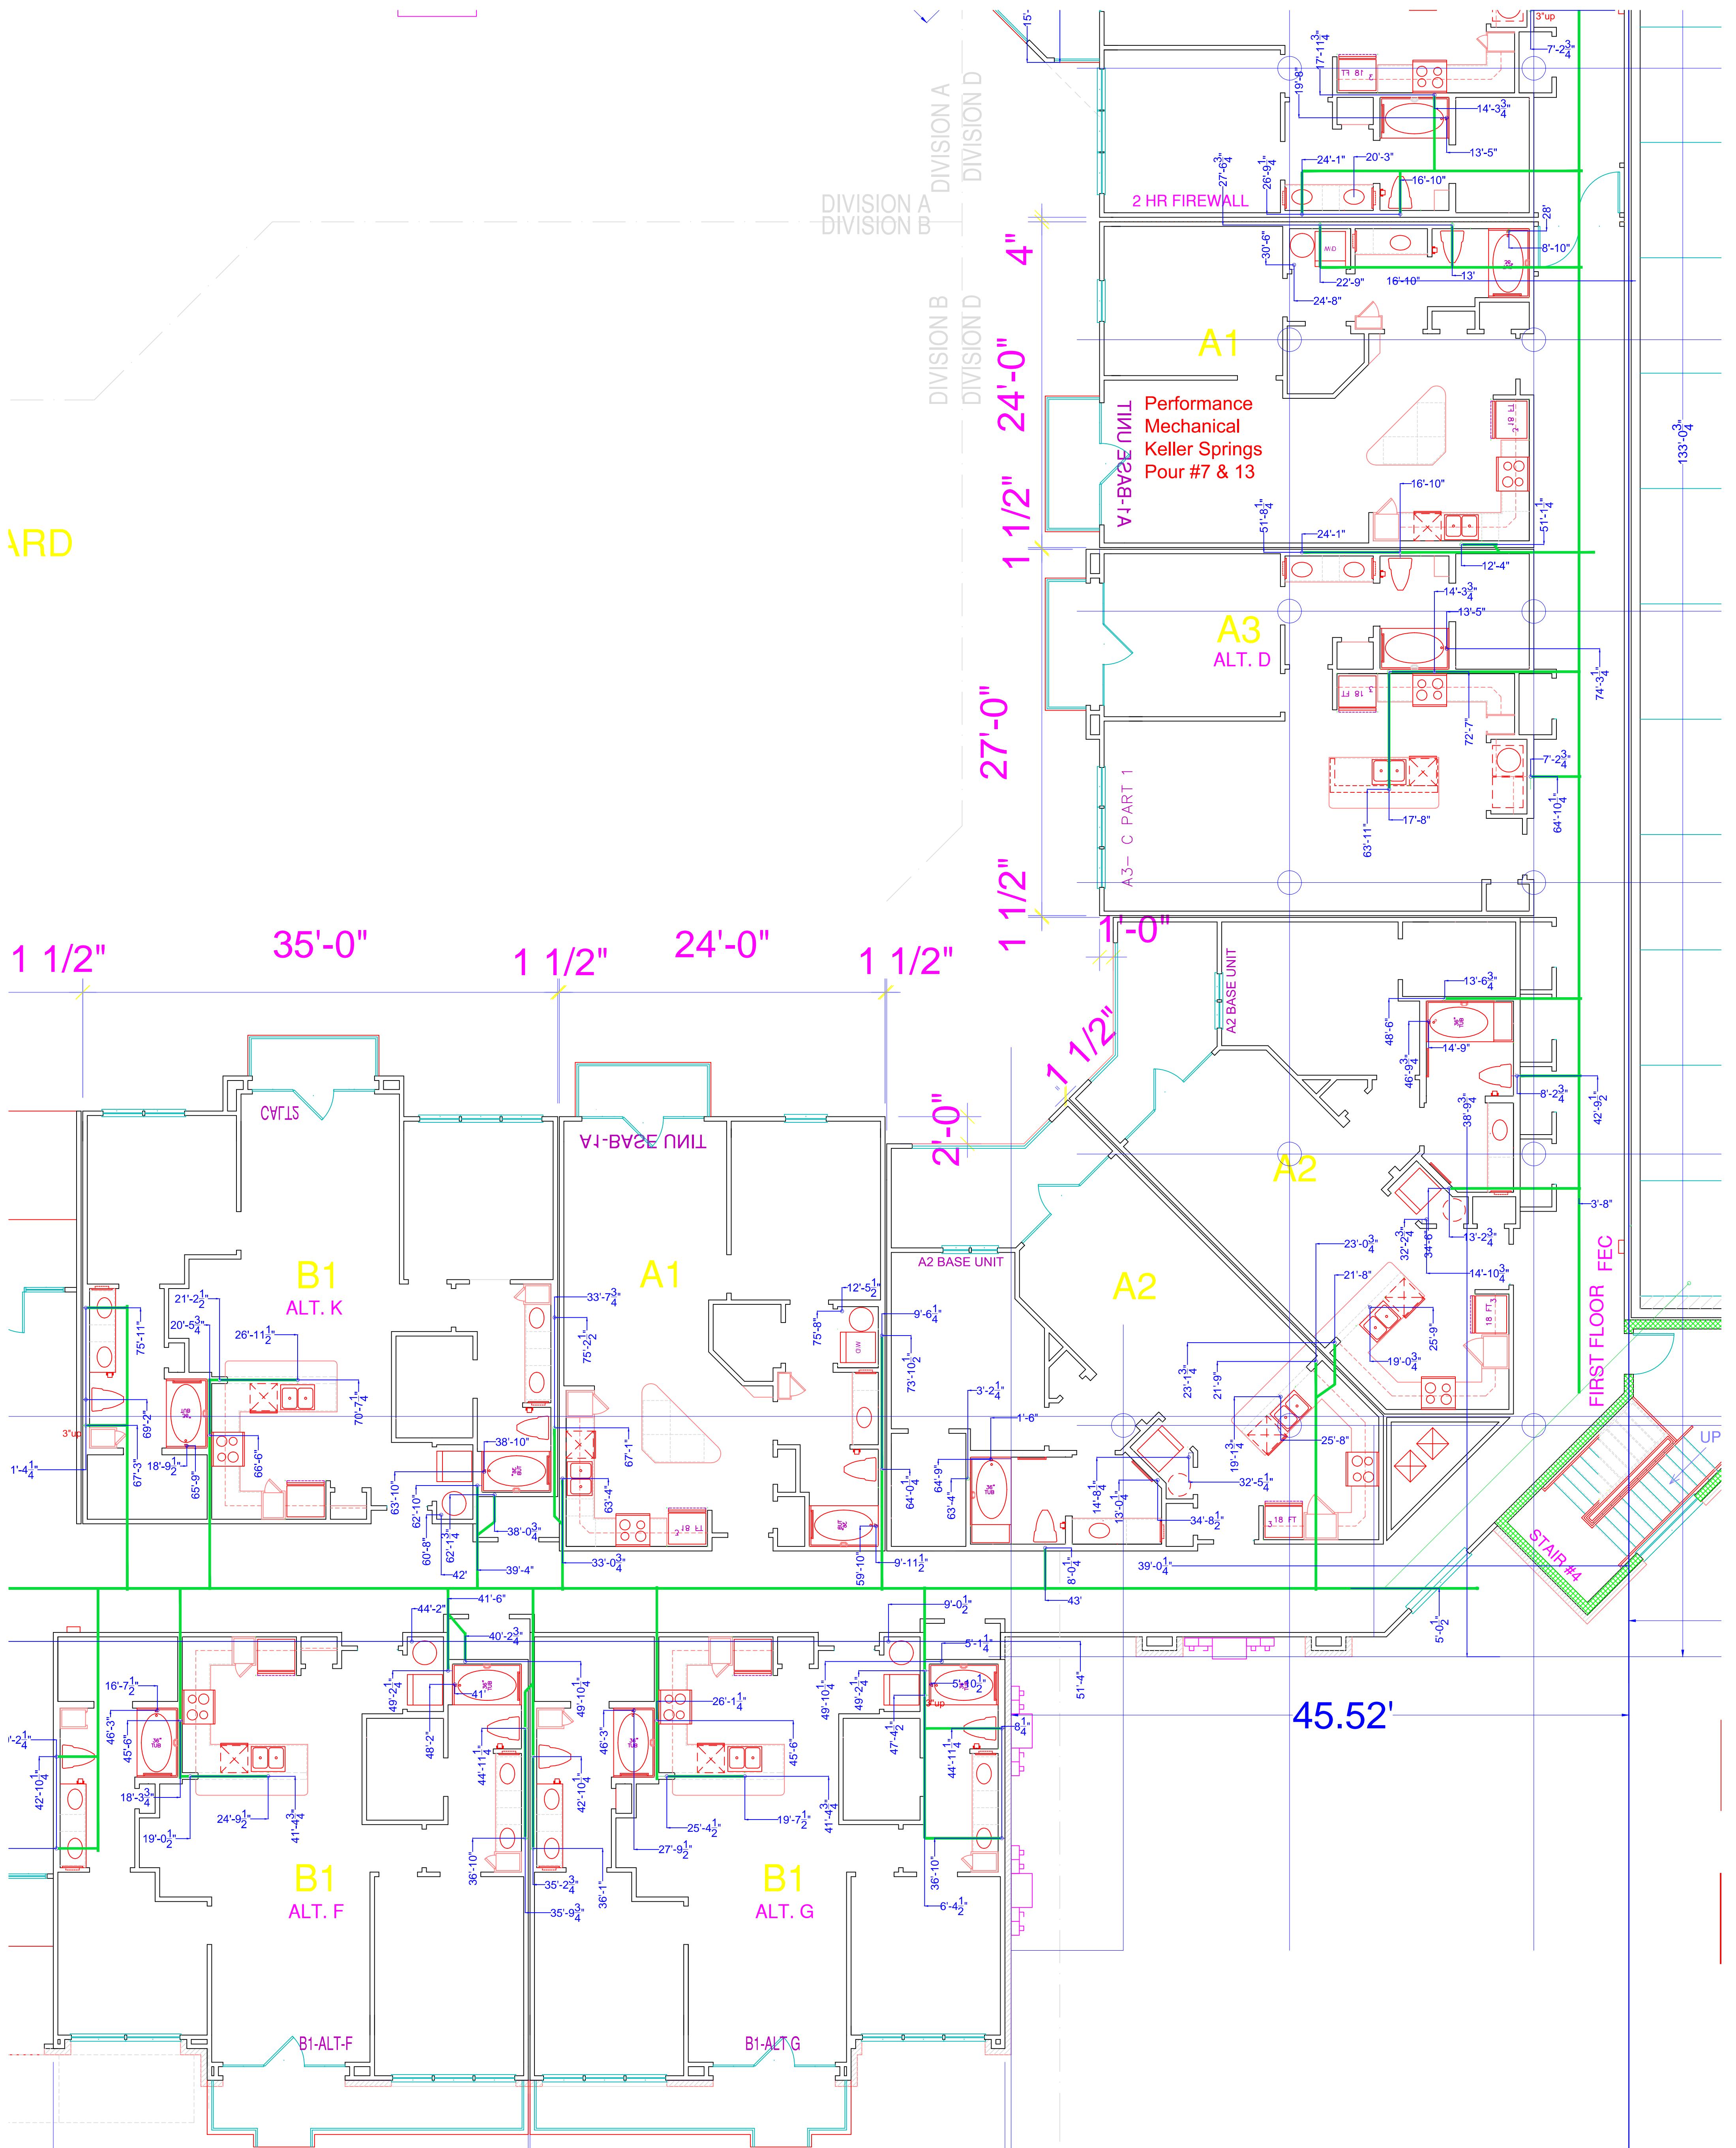

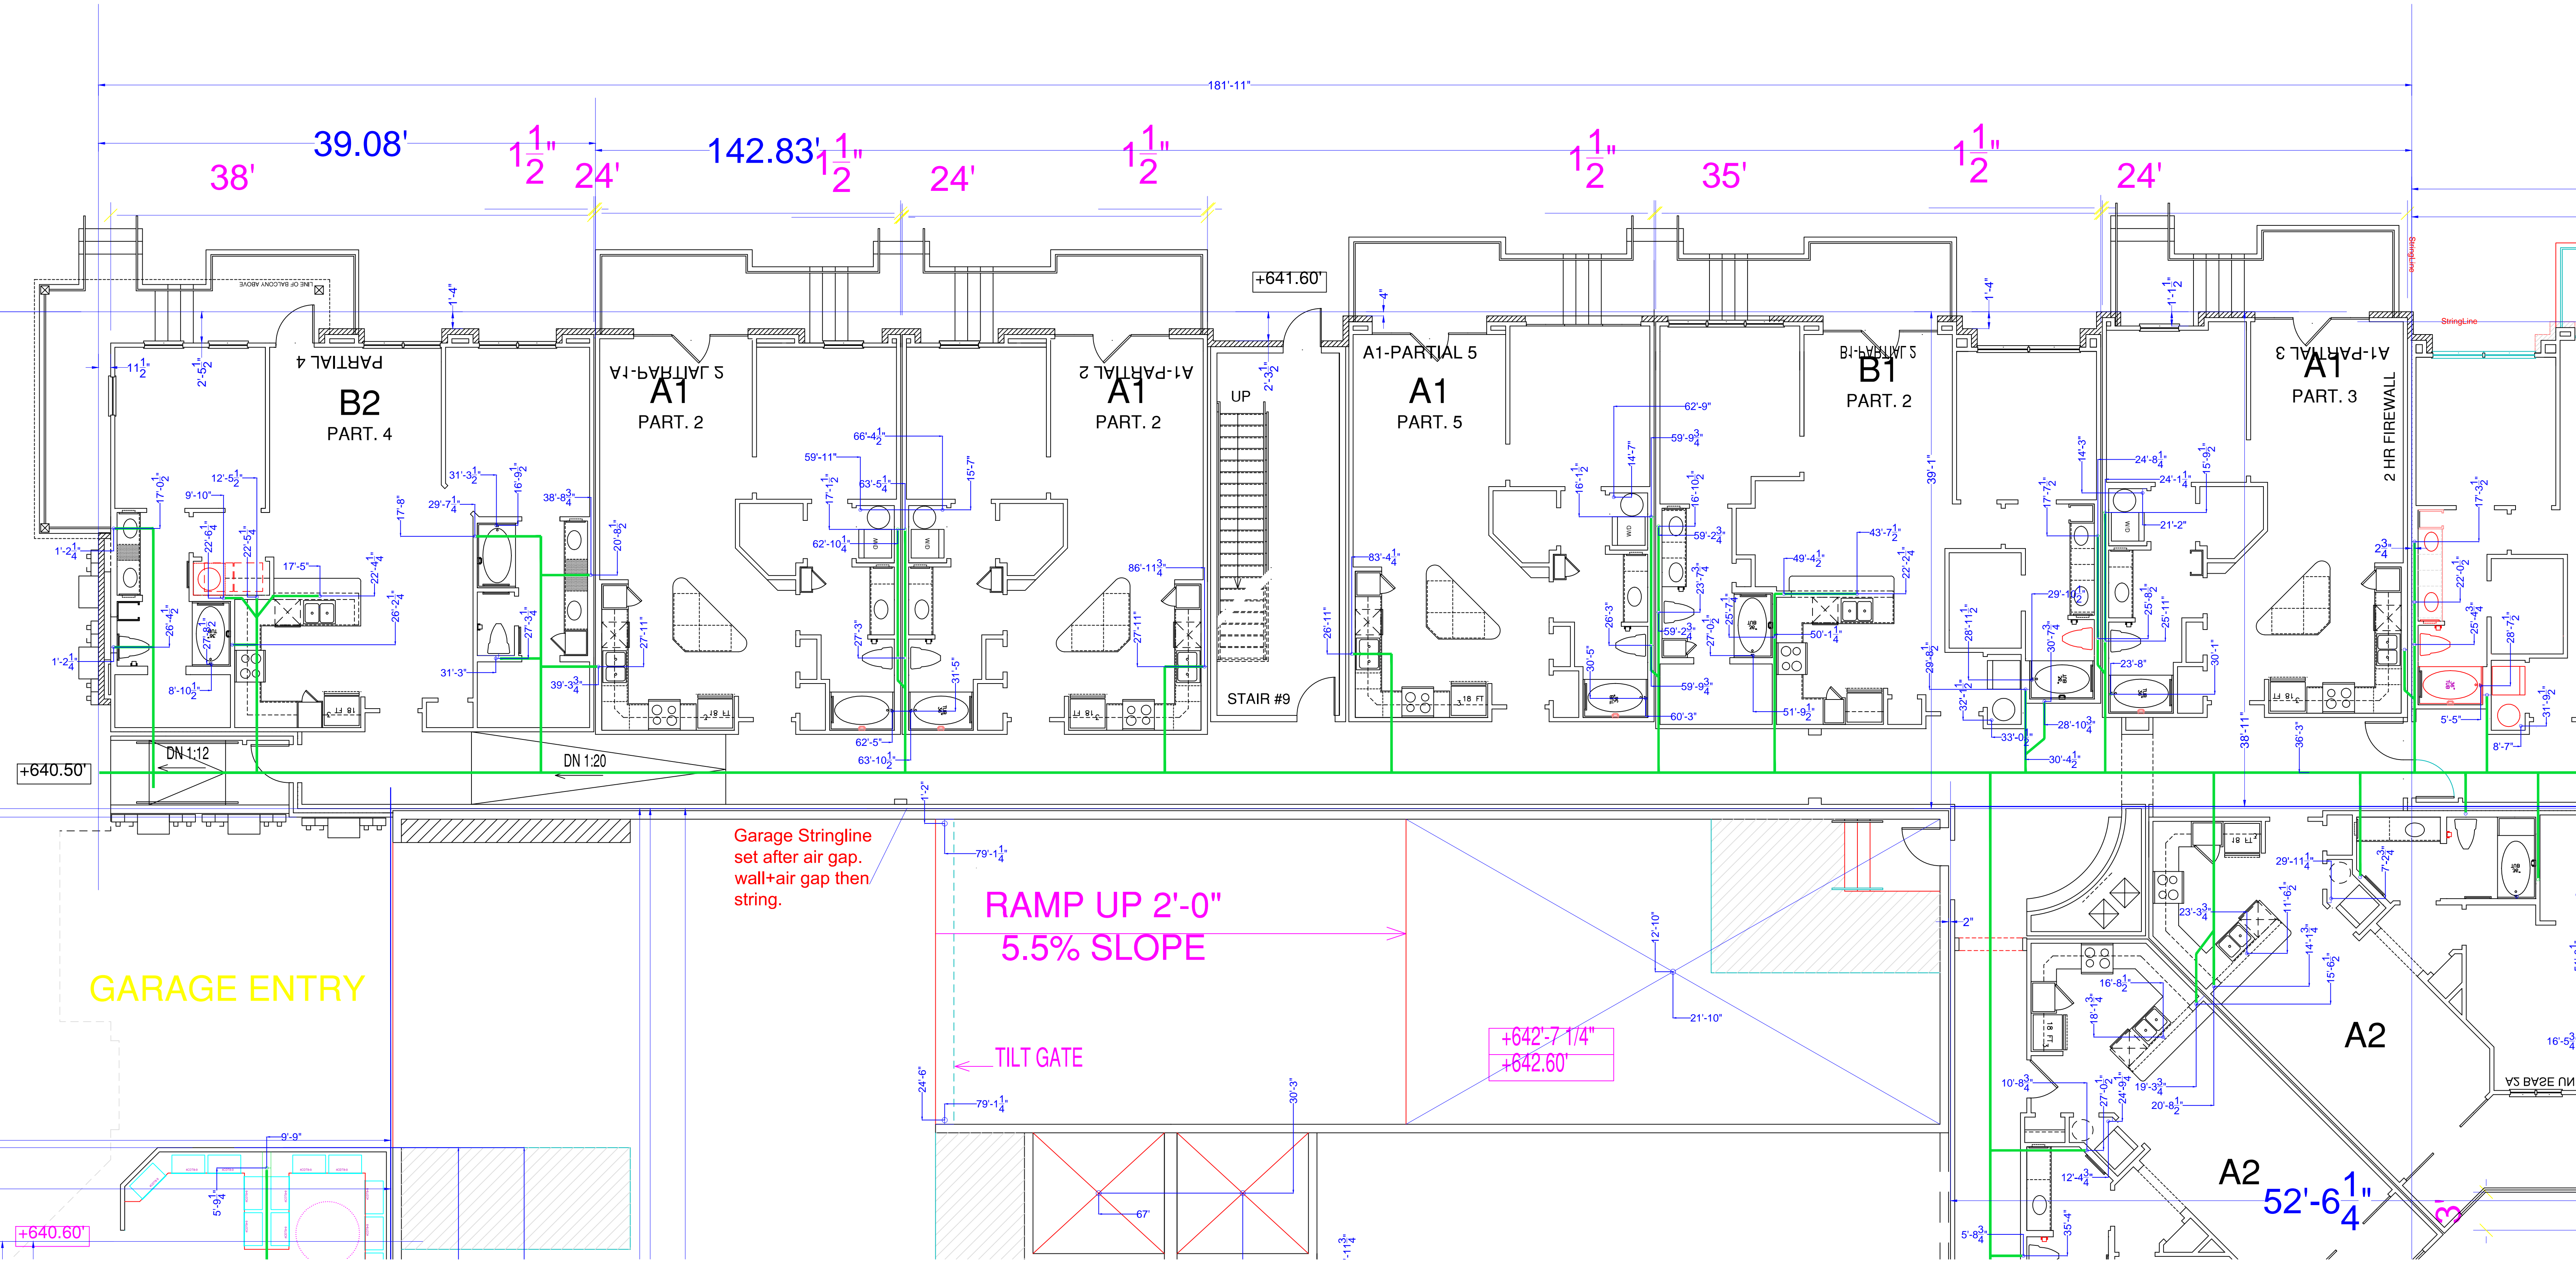

181'-11"

38'

39.08'

1 1/2"

24'

142.83' 1 1/2"

24'

1 1/2"

1 1/2"

35'

1 1/2"

24'

B2 PART. 4

A1 PART. 2

A1 PART. 2

A1 PART. 5

B1 PART. 2

A1 PART. 3

STAIR #9

2 HR FIRE WALL

+640.50'

+641.60'

DN 1:12

DN 1:20

Garage Stringline set after air gap. wall+air gap then string.

RAMP UP 2'-0" 5.5% SLOPE

TILT GATE

+642-7 1/4"
+642.60'

GARAGE ENTRY


+640.60'


A2 52'-6 1/4"

A2


BASE MILL

Performance
Mechanical
Keller Springs
Pour #1

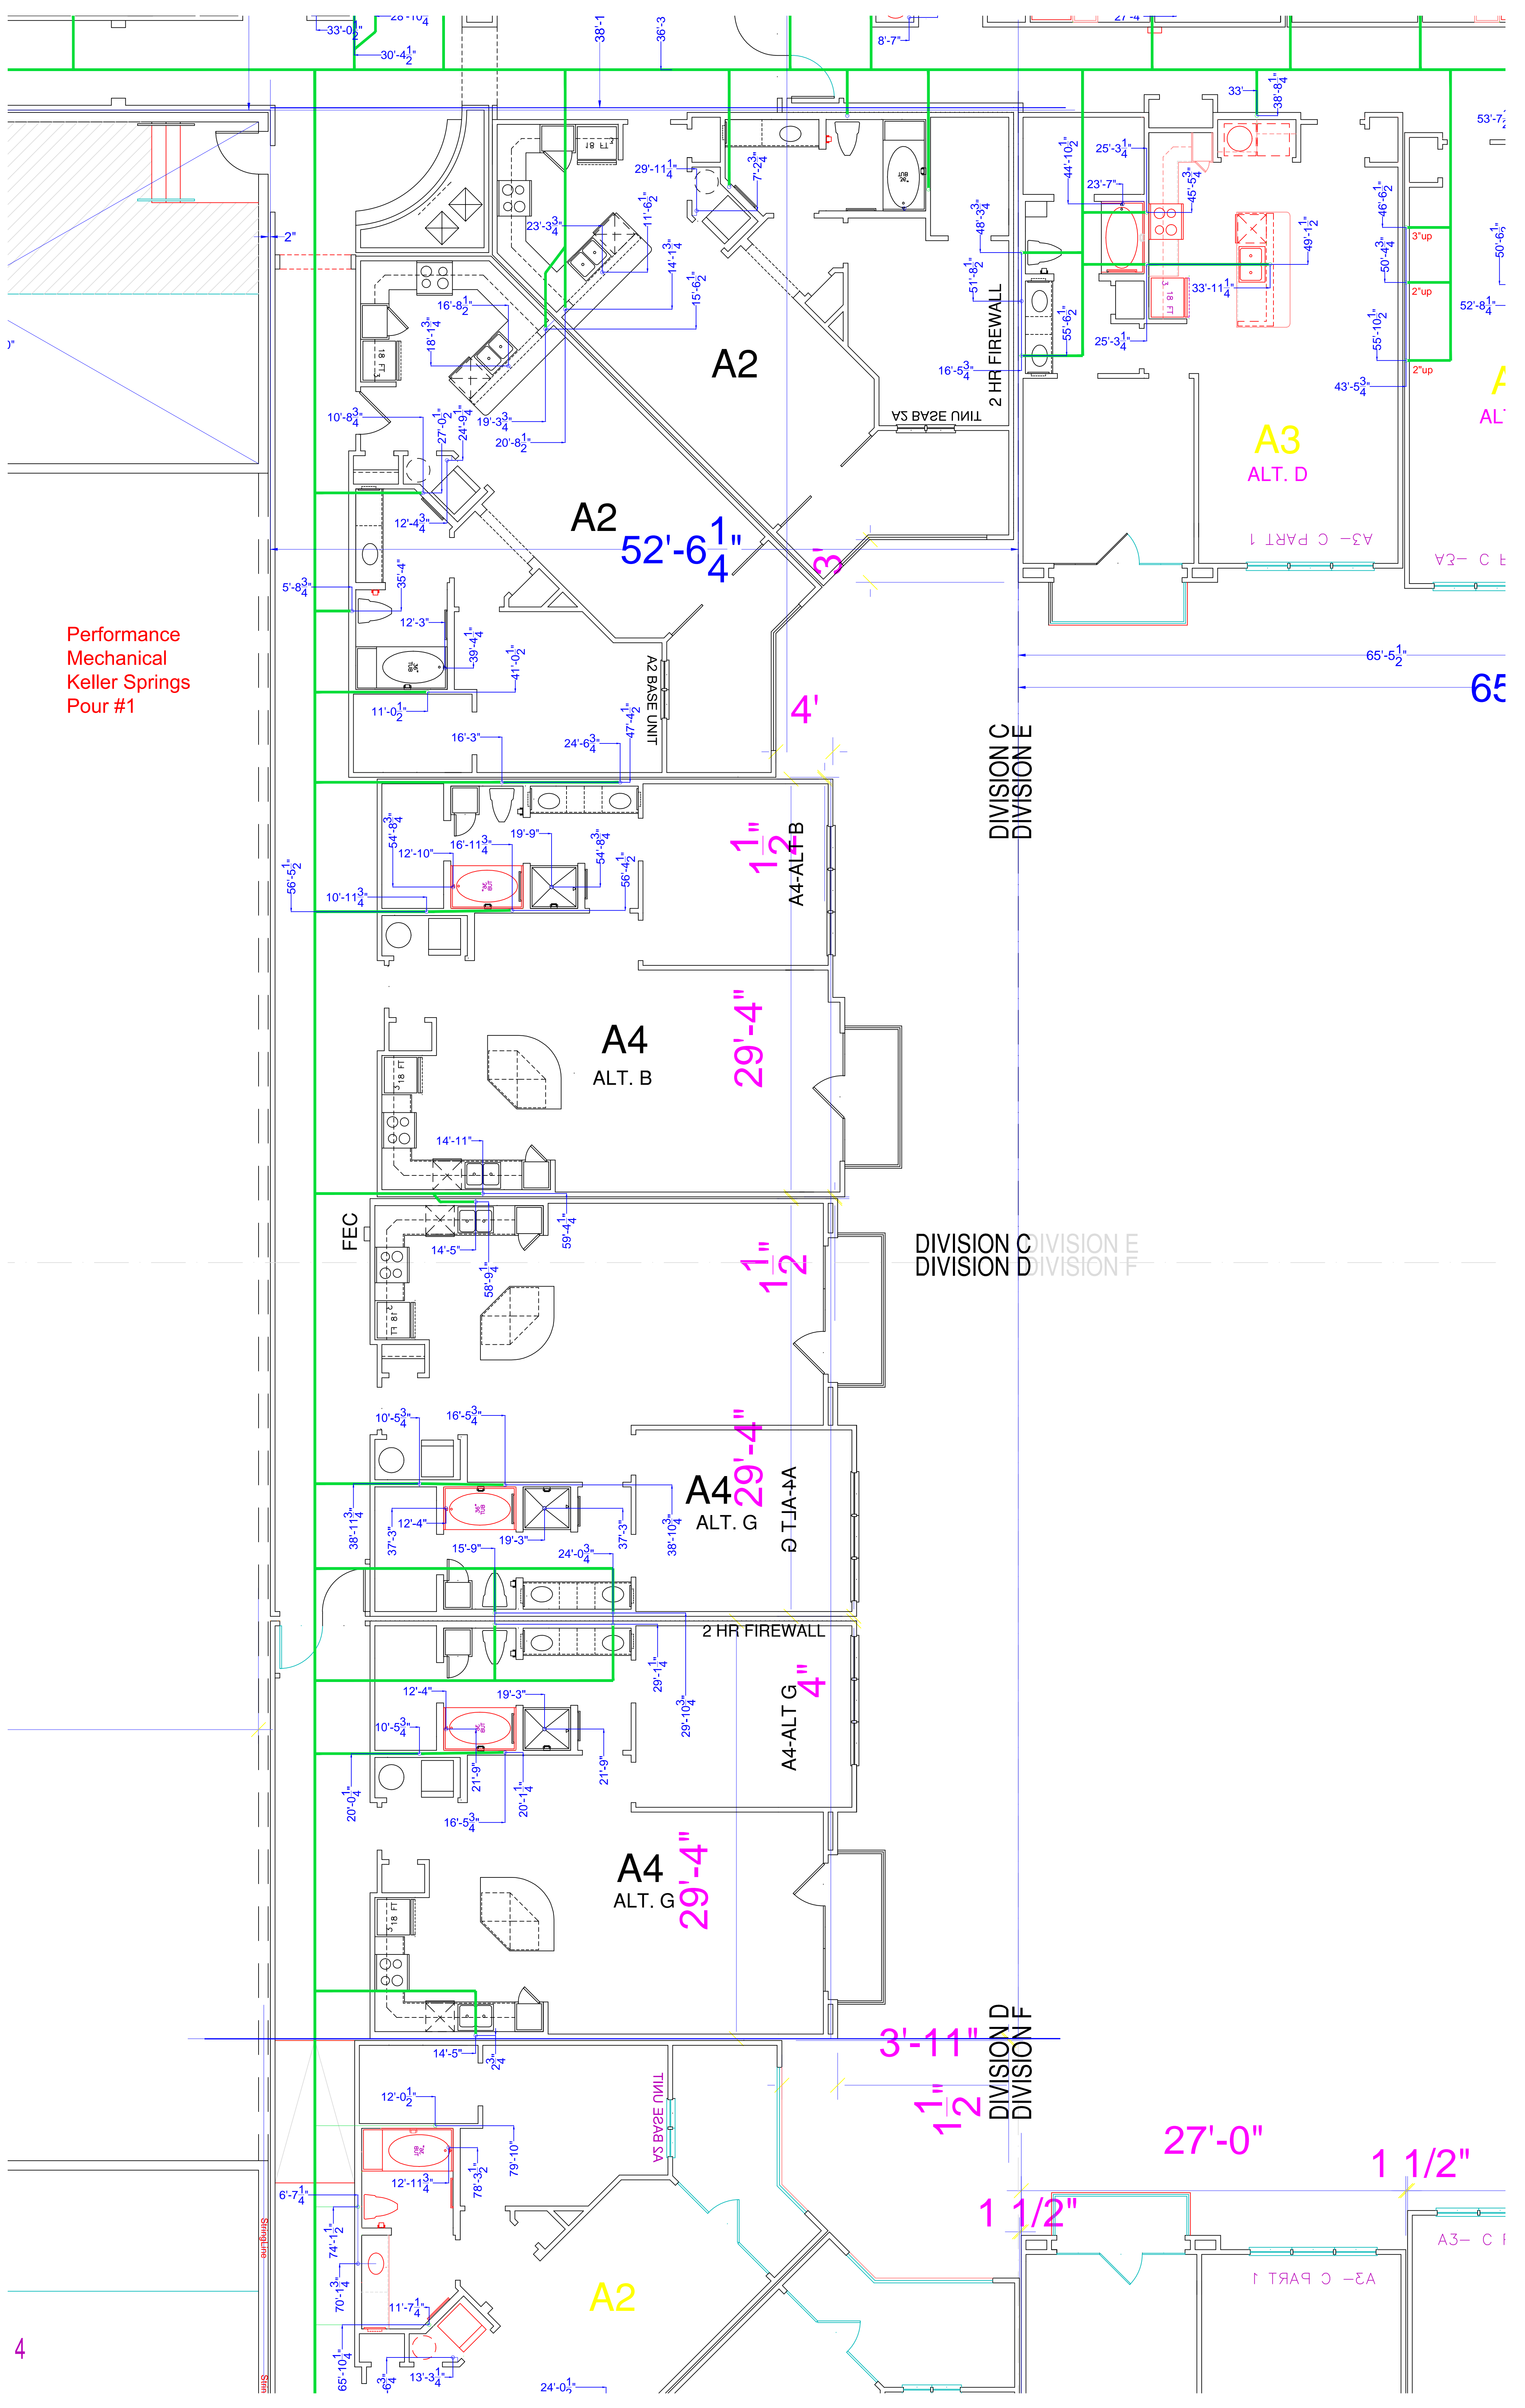

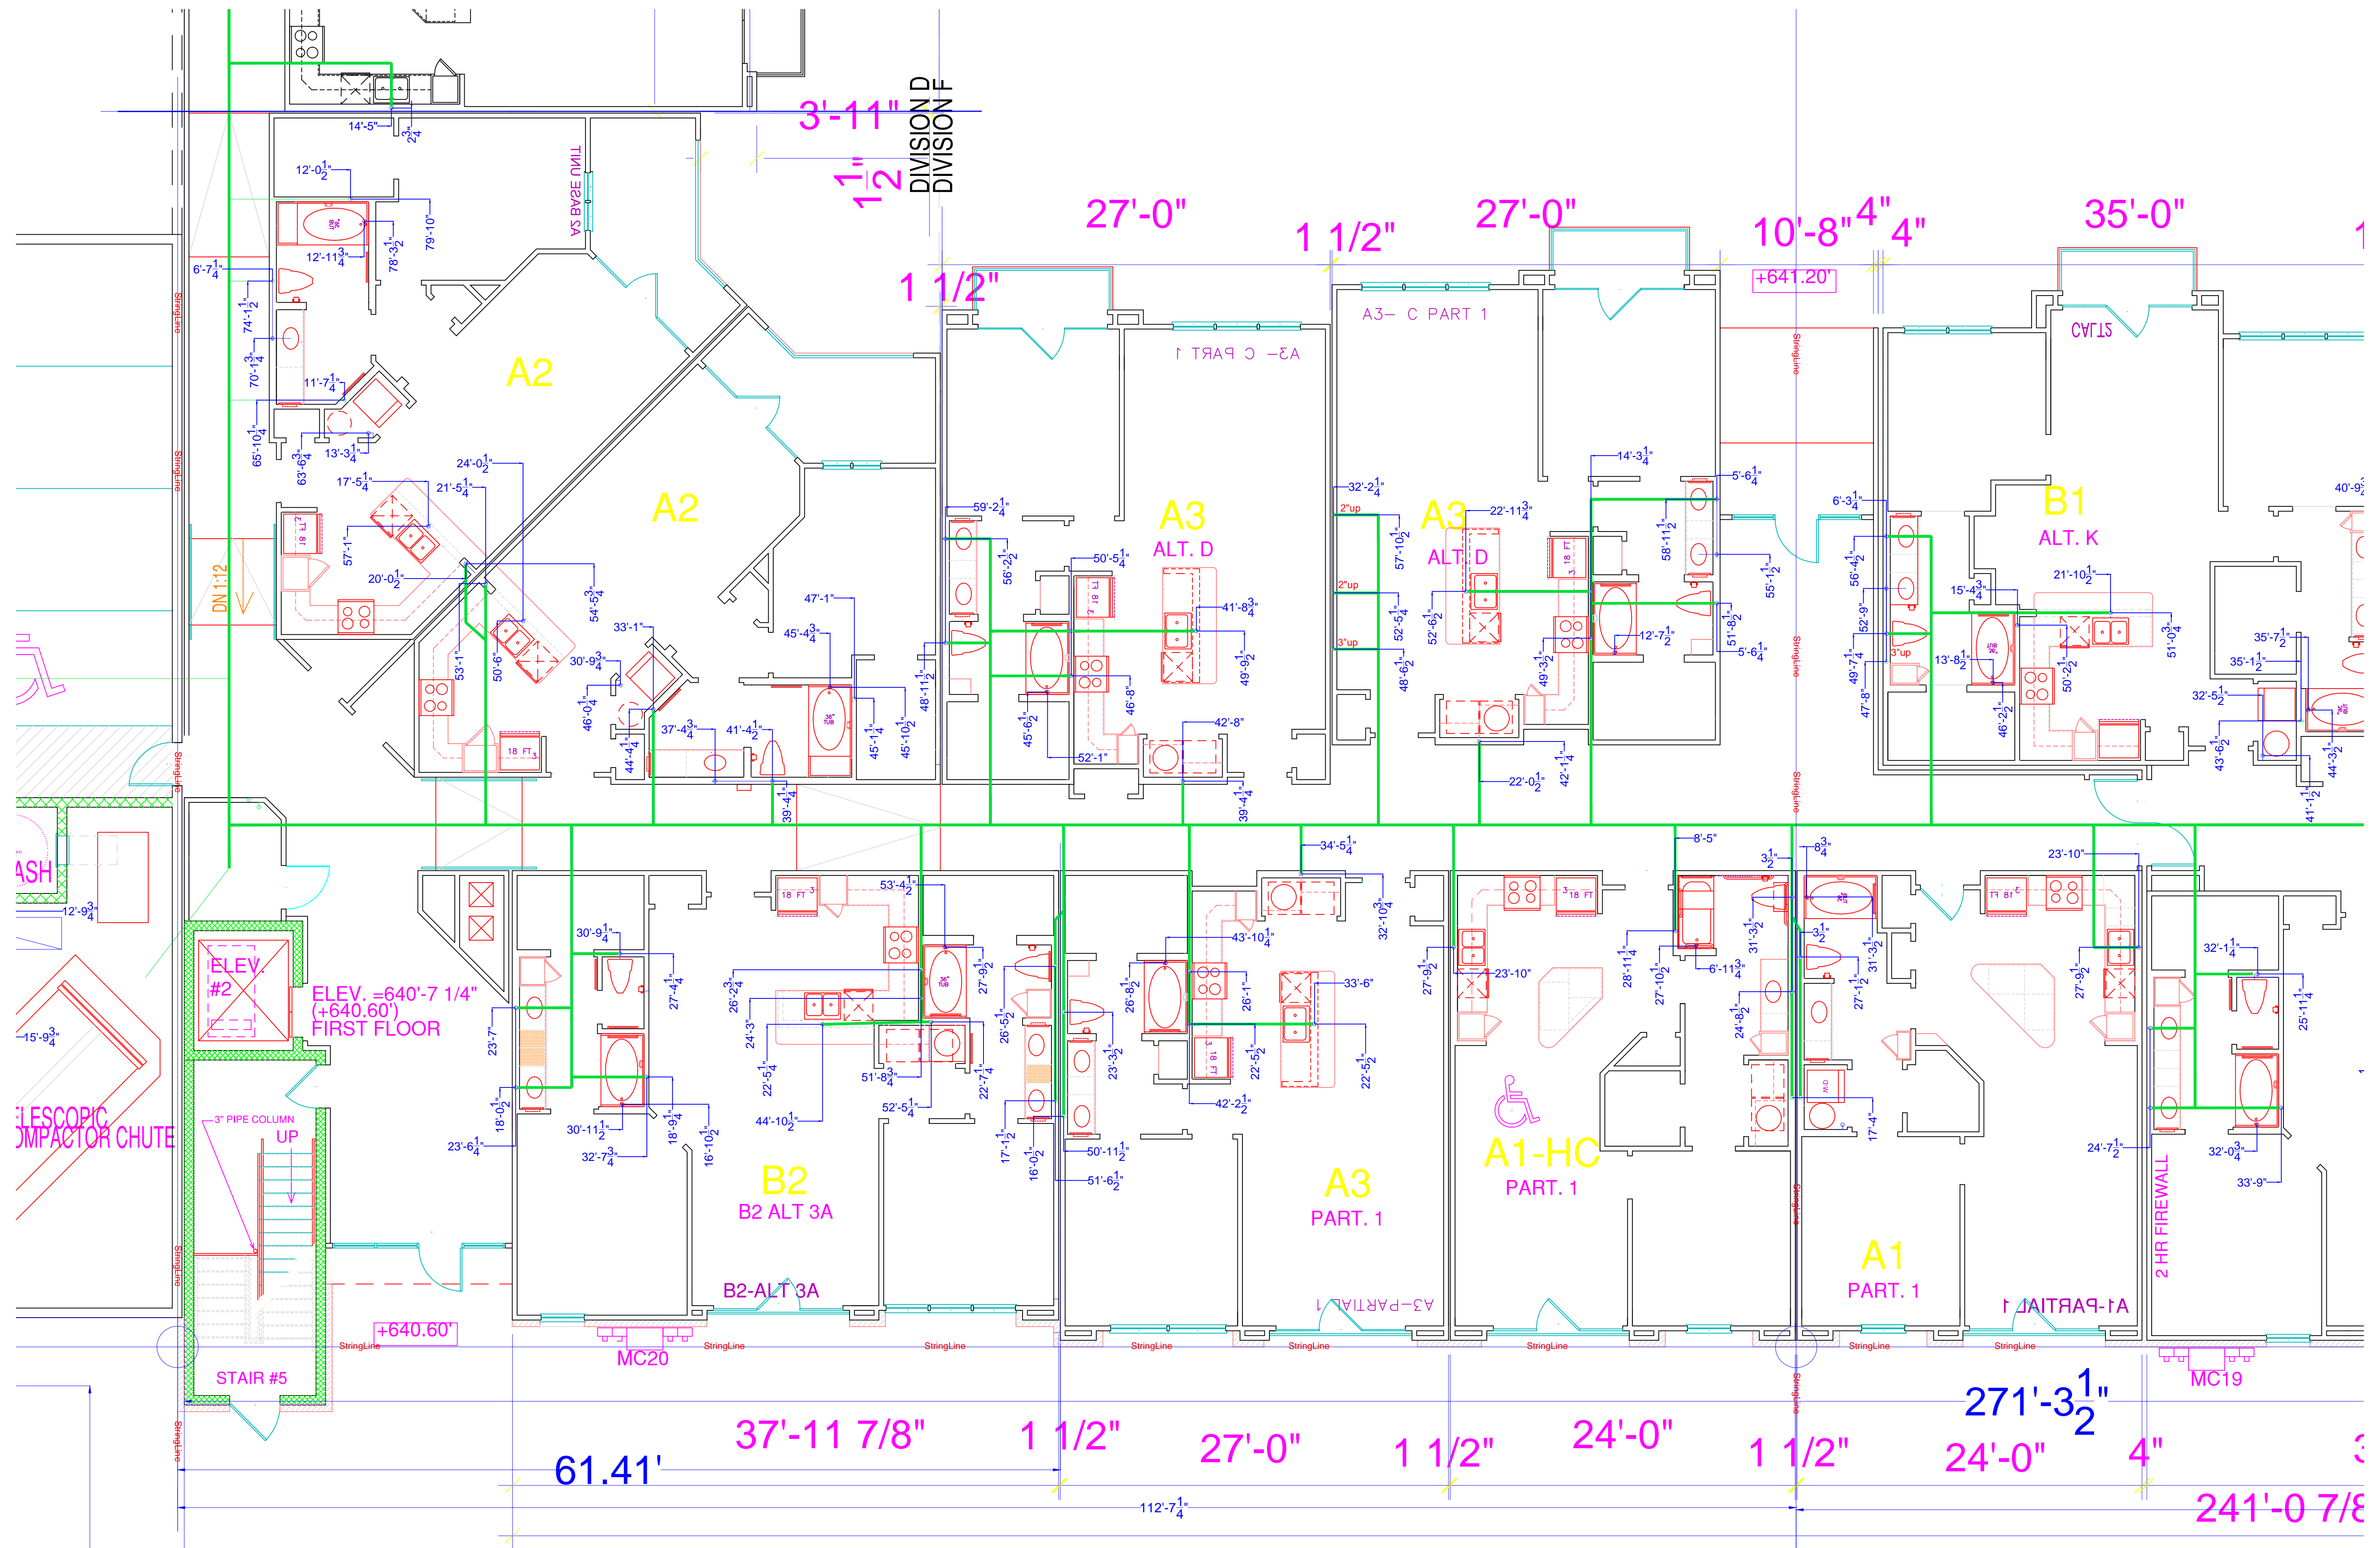


Performance Mechanical Pour 17,15,21 Keller Springs Lofts

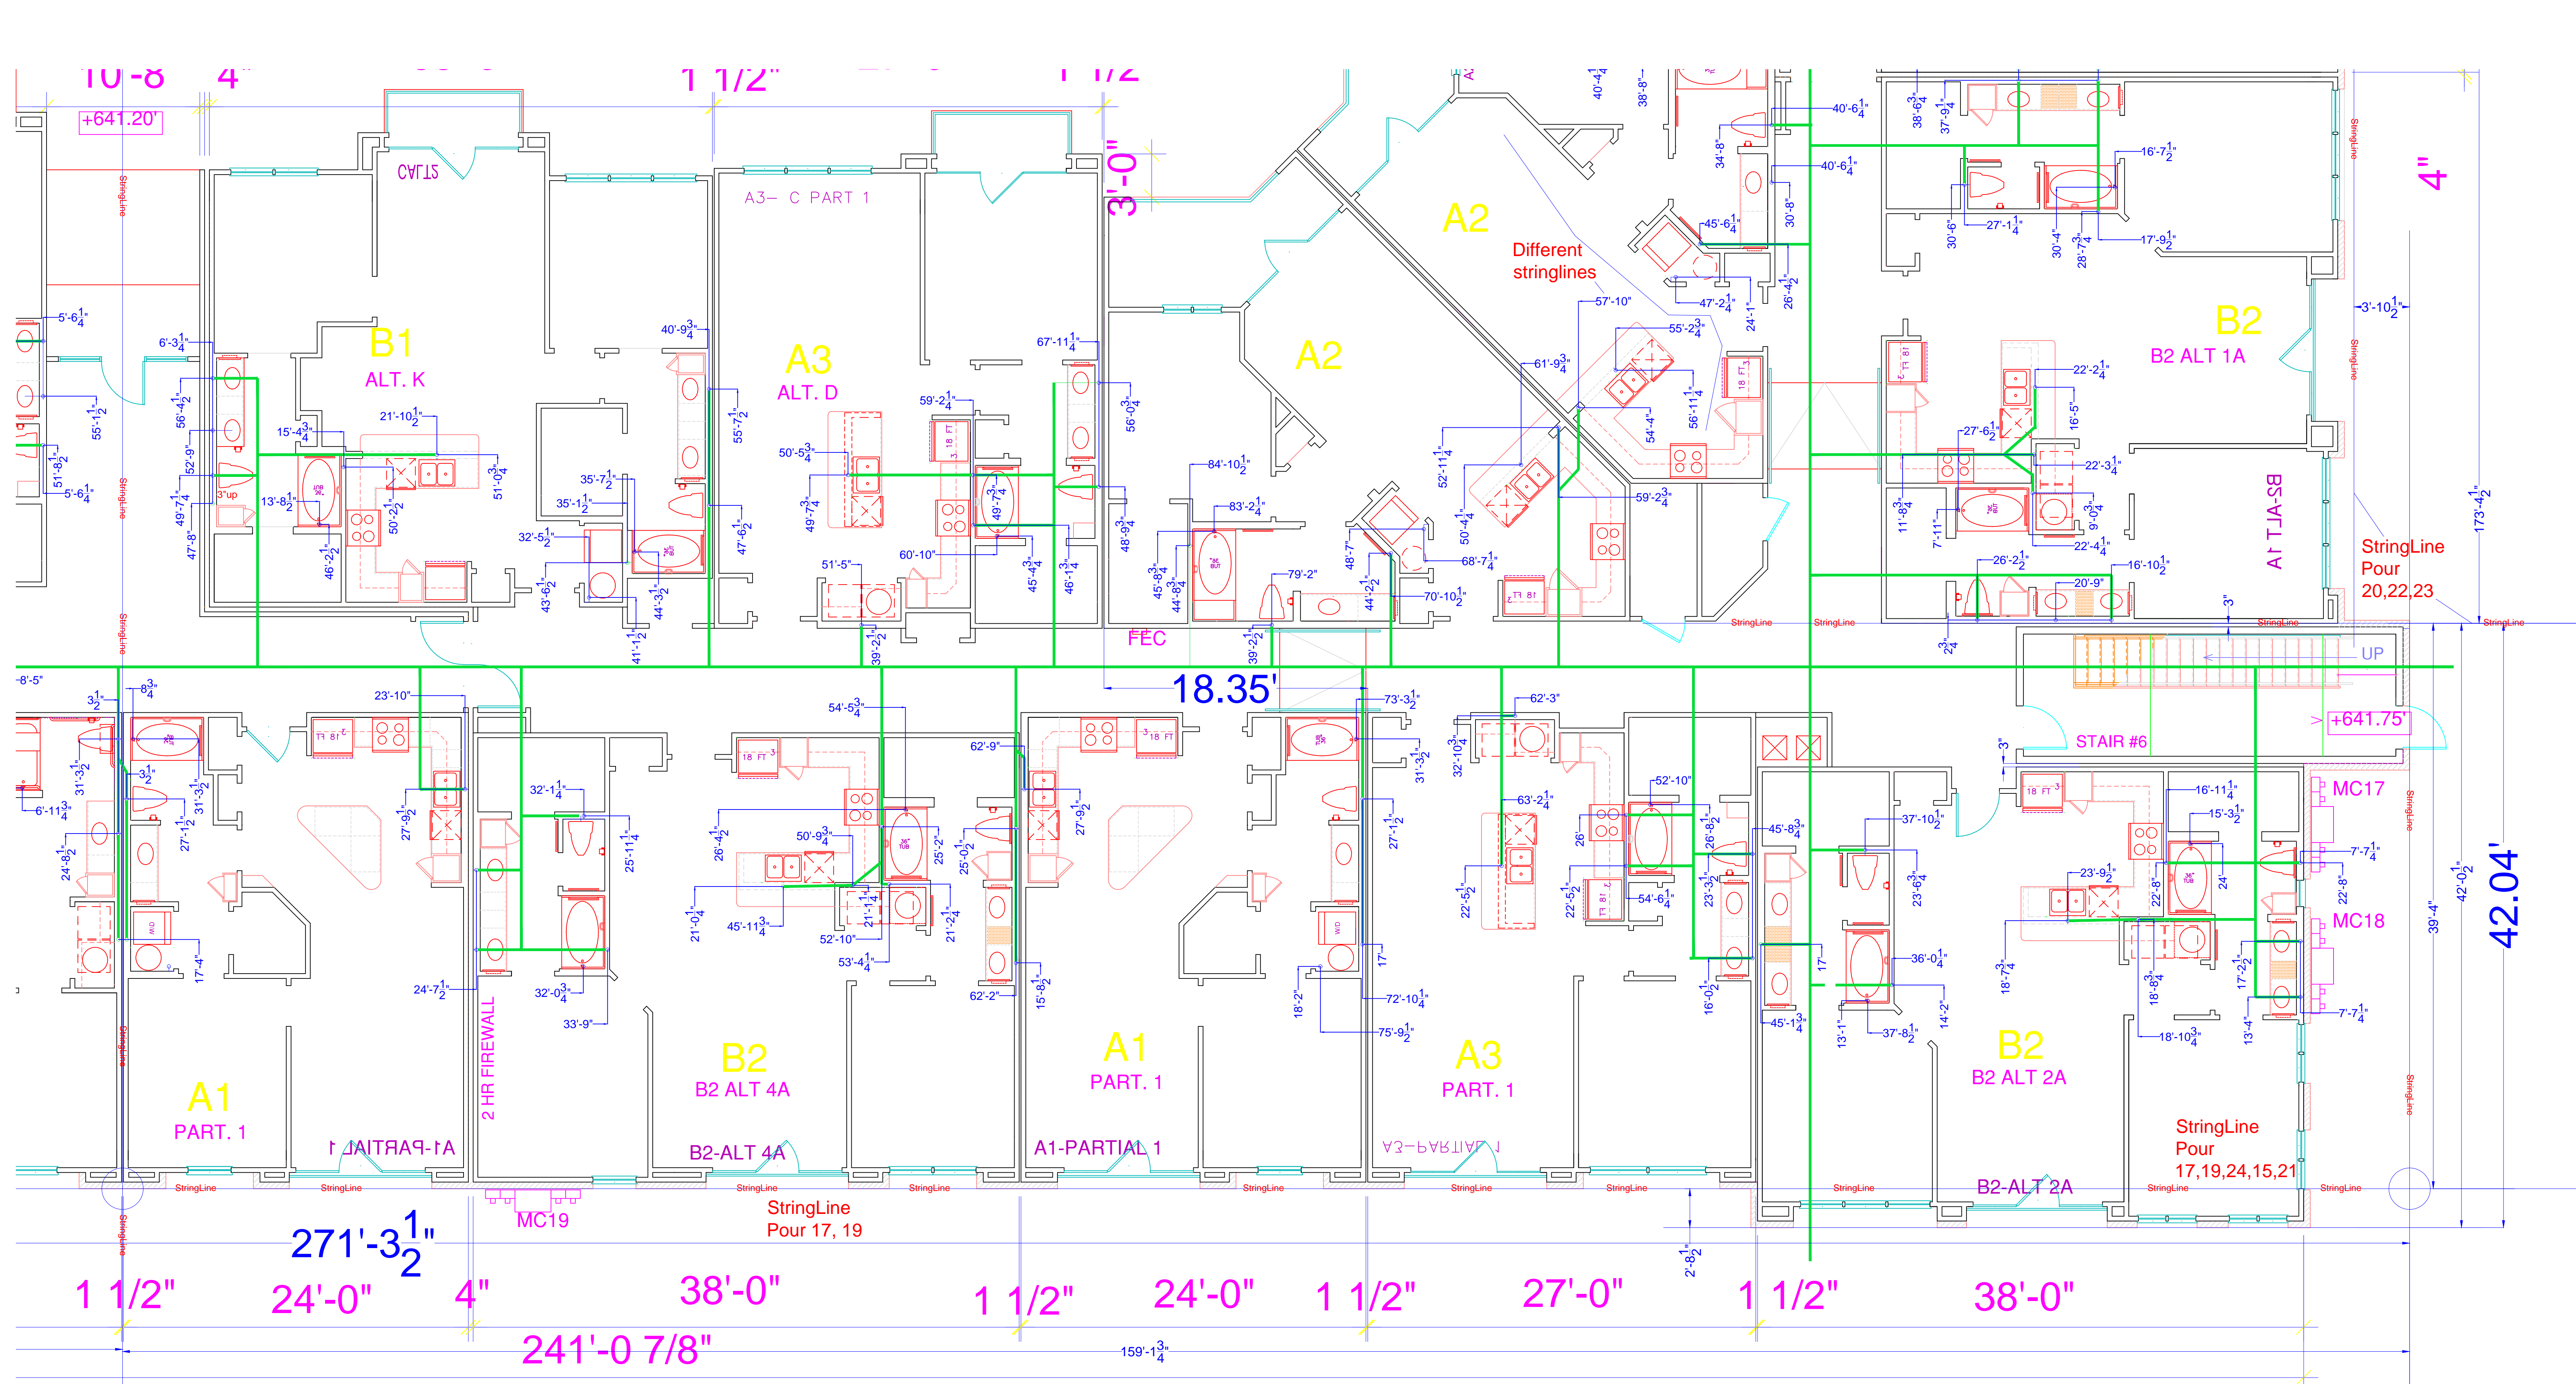

1

Performance Mechanical Pour ,23,24,19,17 Keller Springs Lofts

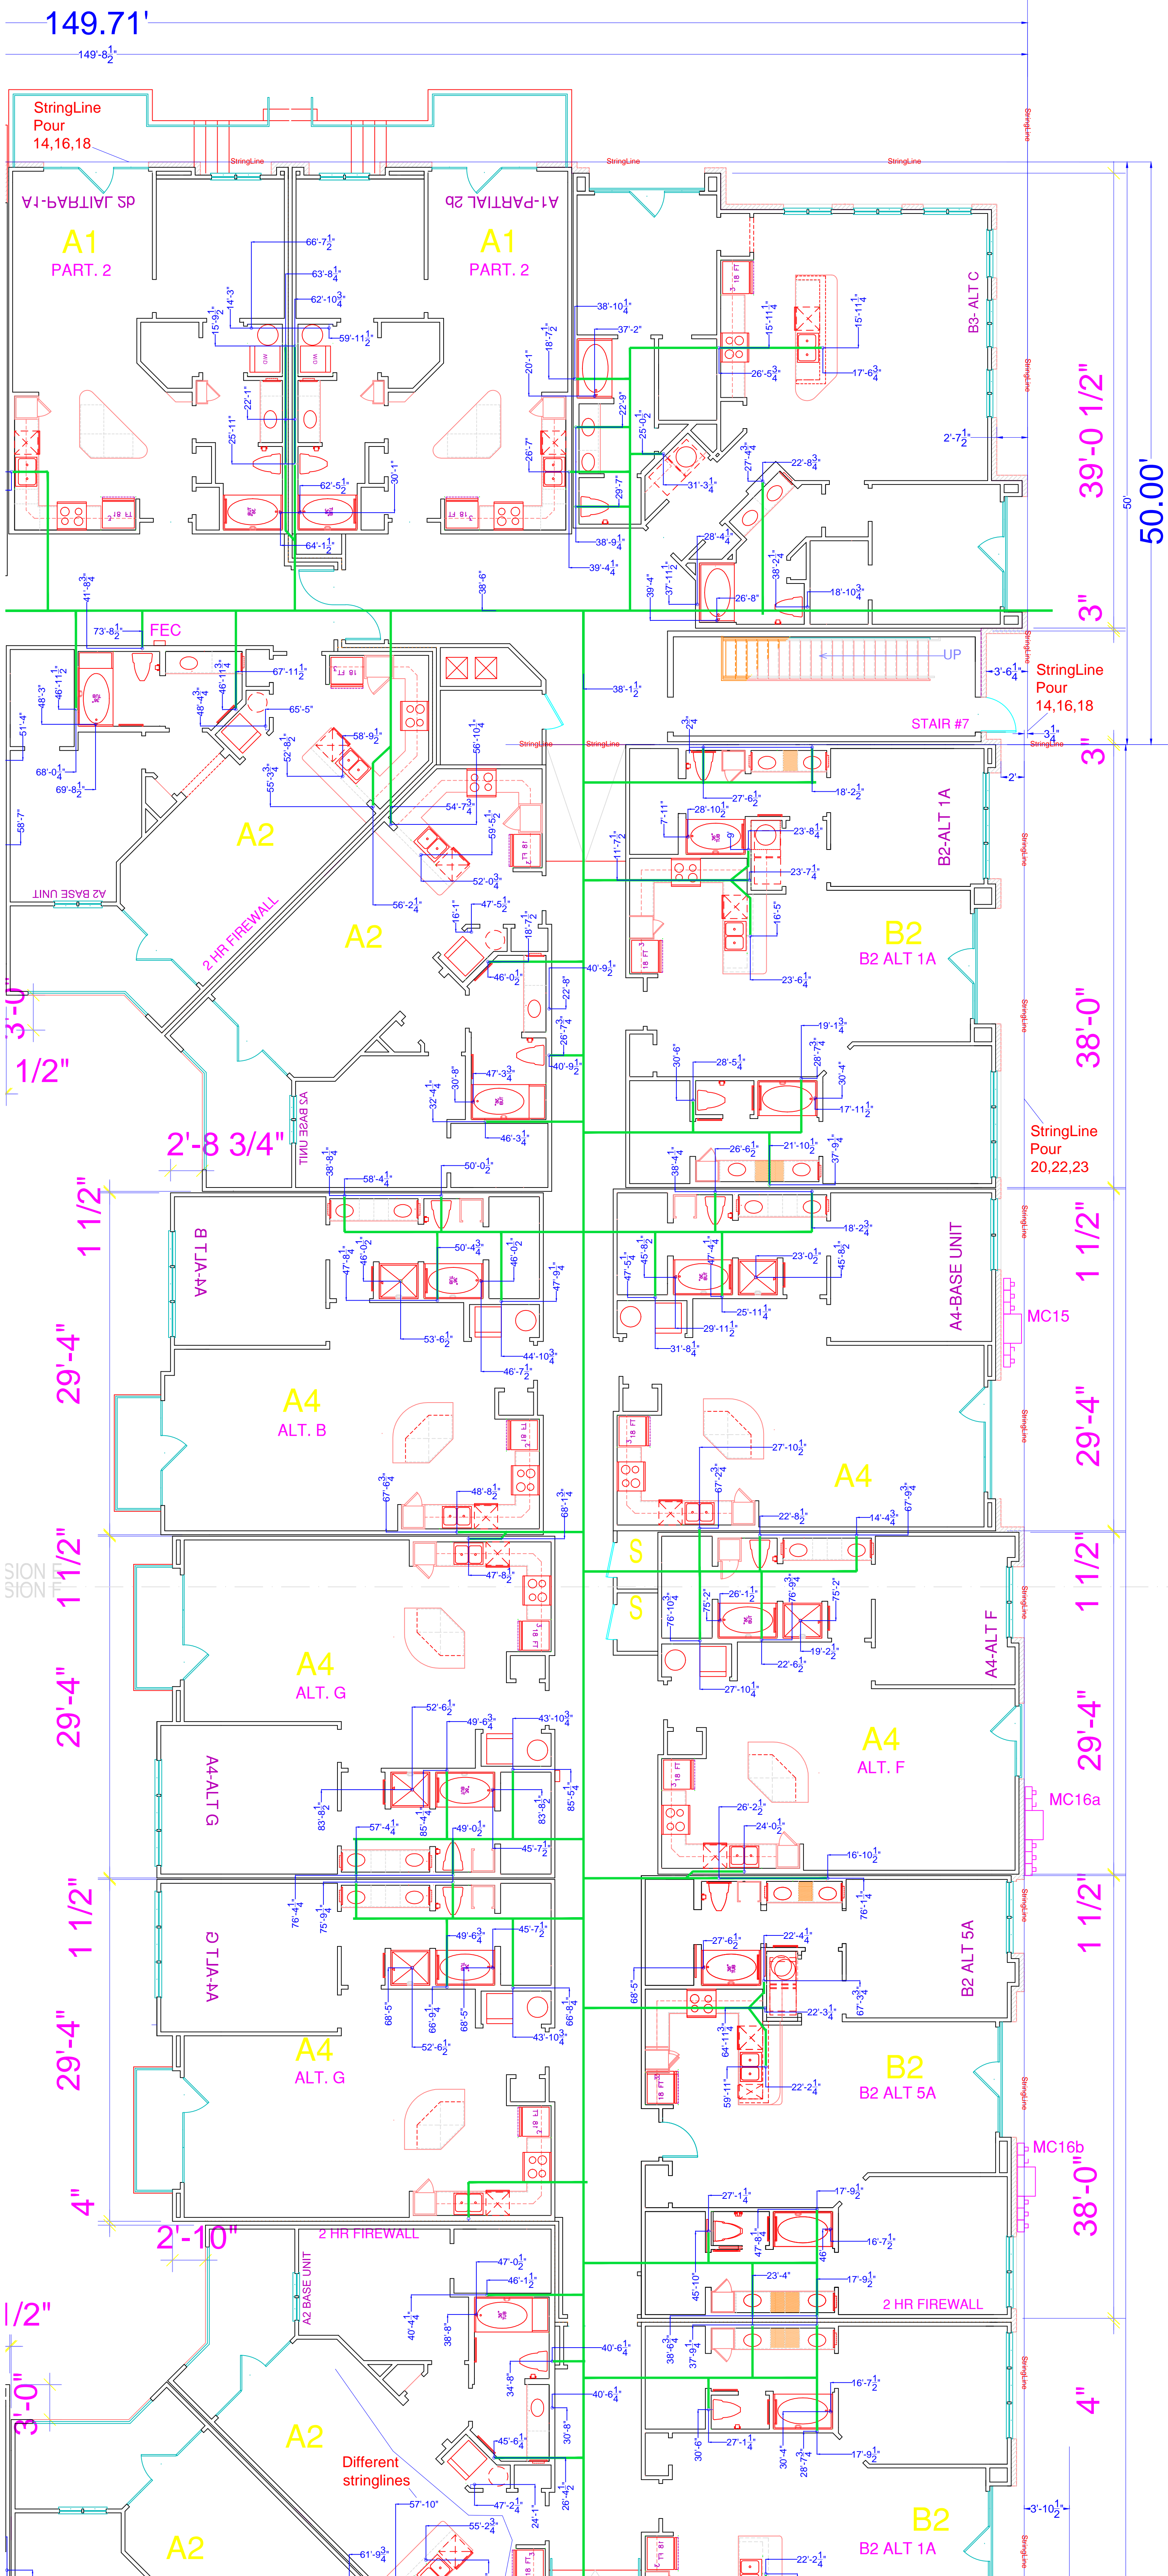


Performance Mechanical Pour 16, 18, 20, 22, 23

Keller Springs Lofts

SION
SION

DIVISION
DIVISION

Performance Mechanical Pour 12,14,16,18

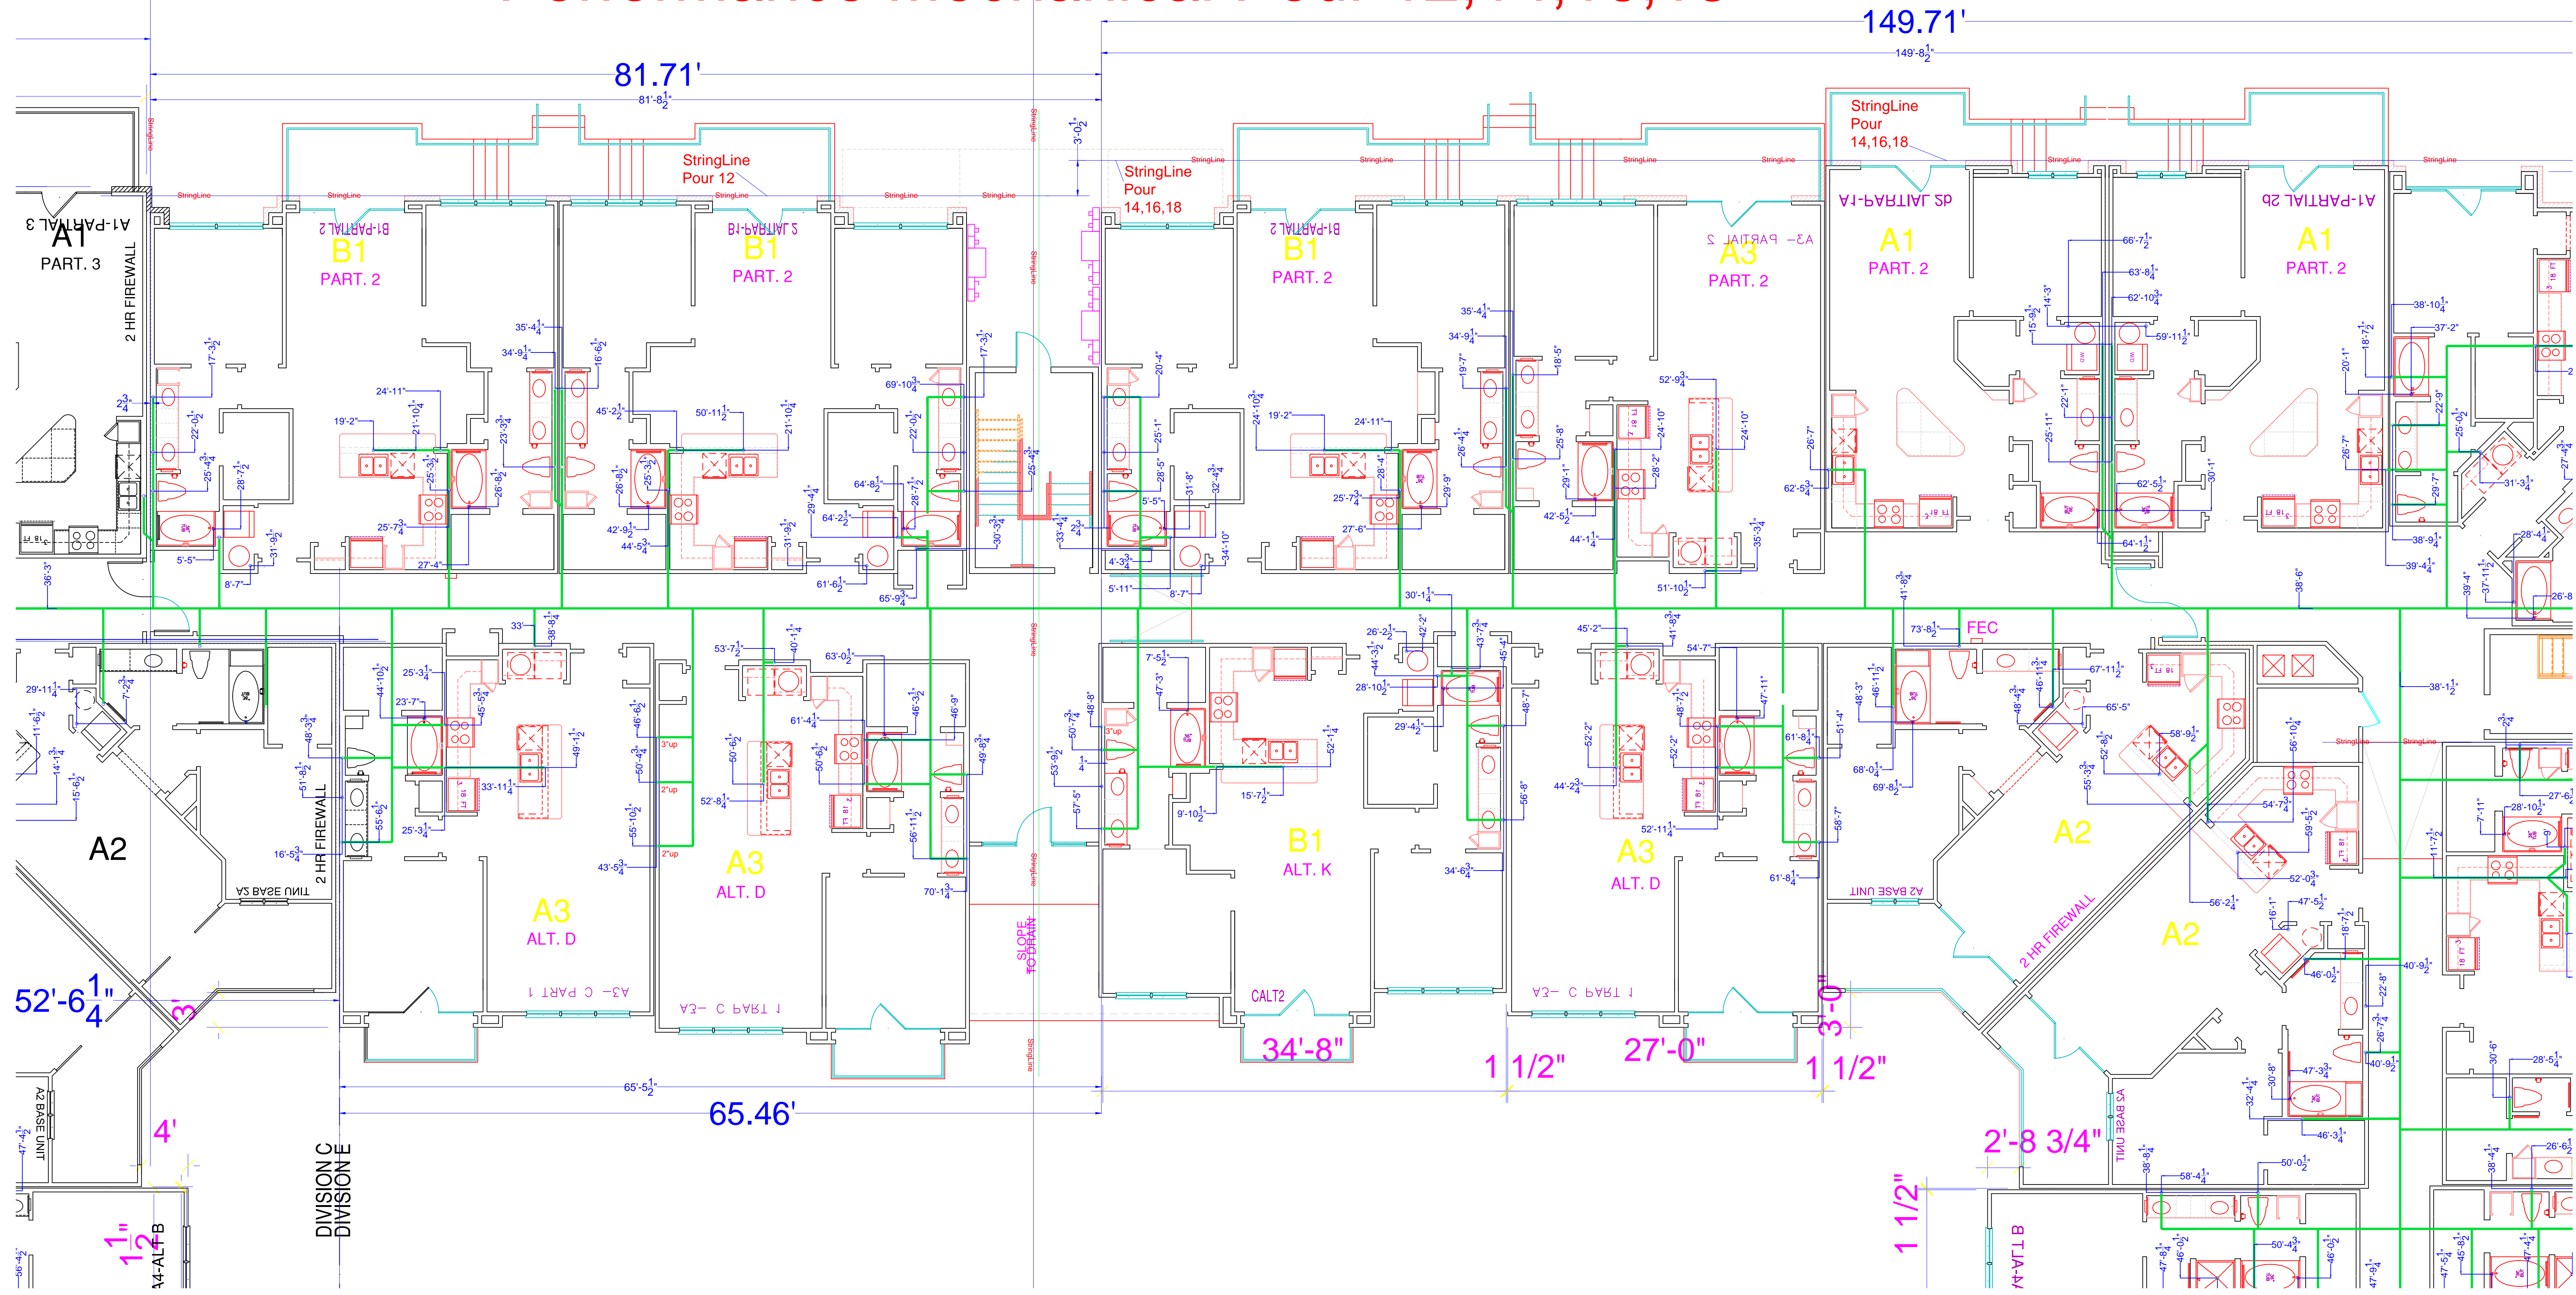



REVISIONS

KELLER SPRINGS LOFTS

LOFT APARTMENTS IN ADDISON, TEXAS



4144 N. Central Expy.
Suite 855
Dallas, TX 75204
214.520.8878
bgoarchitects.com

DATE
08-19-11


PROJECT
1130355

SHEET NUMBER

E-10.1

SITE PLAN ELECTRICAL

JSE Jordan & Skala Engineers
14700 Addison Road, Suite 330
Dallas, TX 75244-3126
V: (972) 341-1400 F: (972) 341-1613
Project Number: 1130355 Title: From Register Item # F-4090
Drawn By: NJ Checked By: RAD

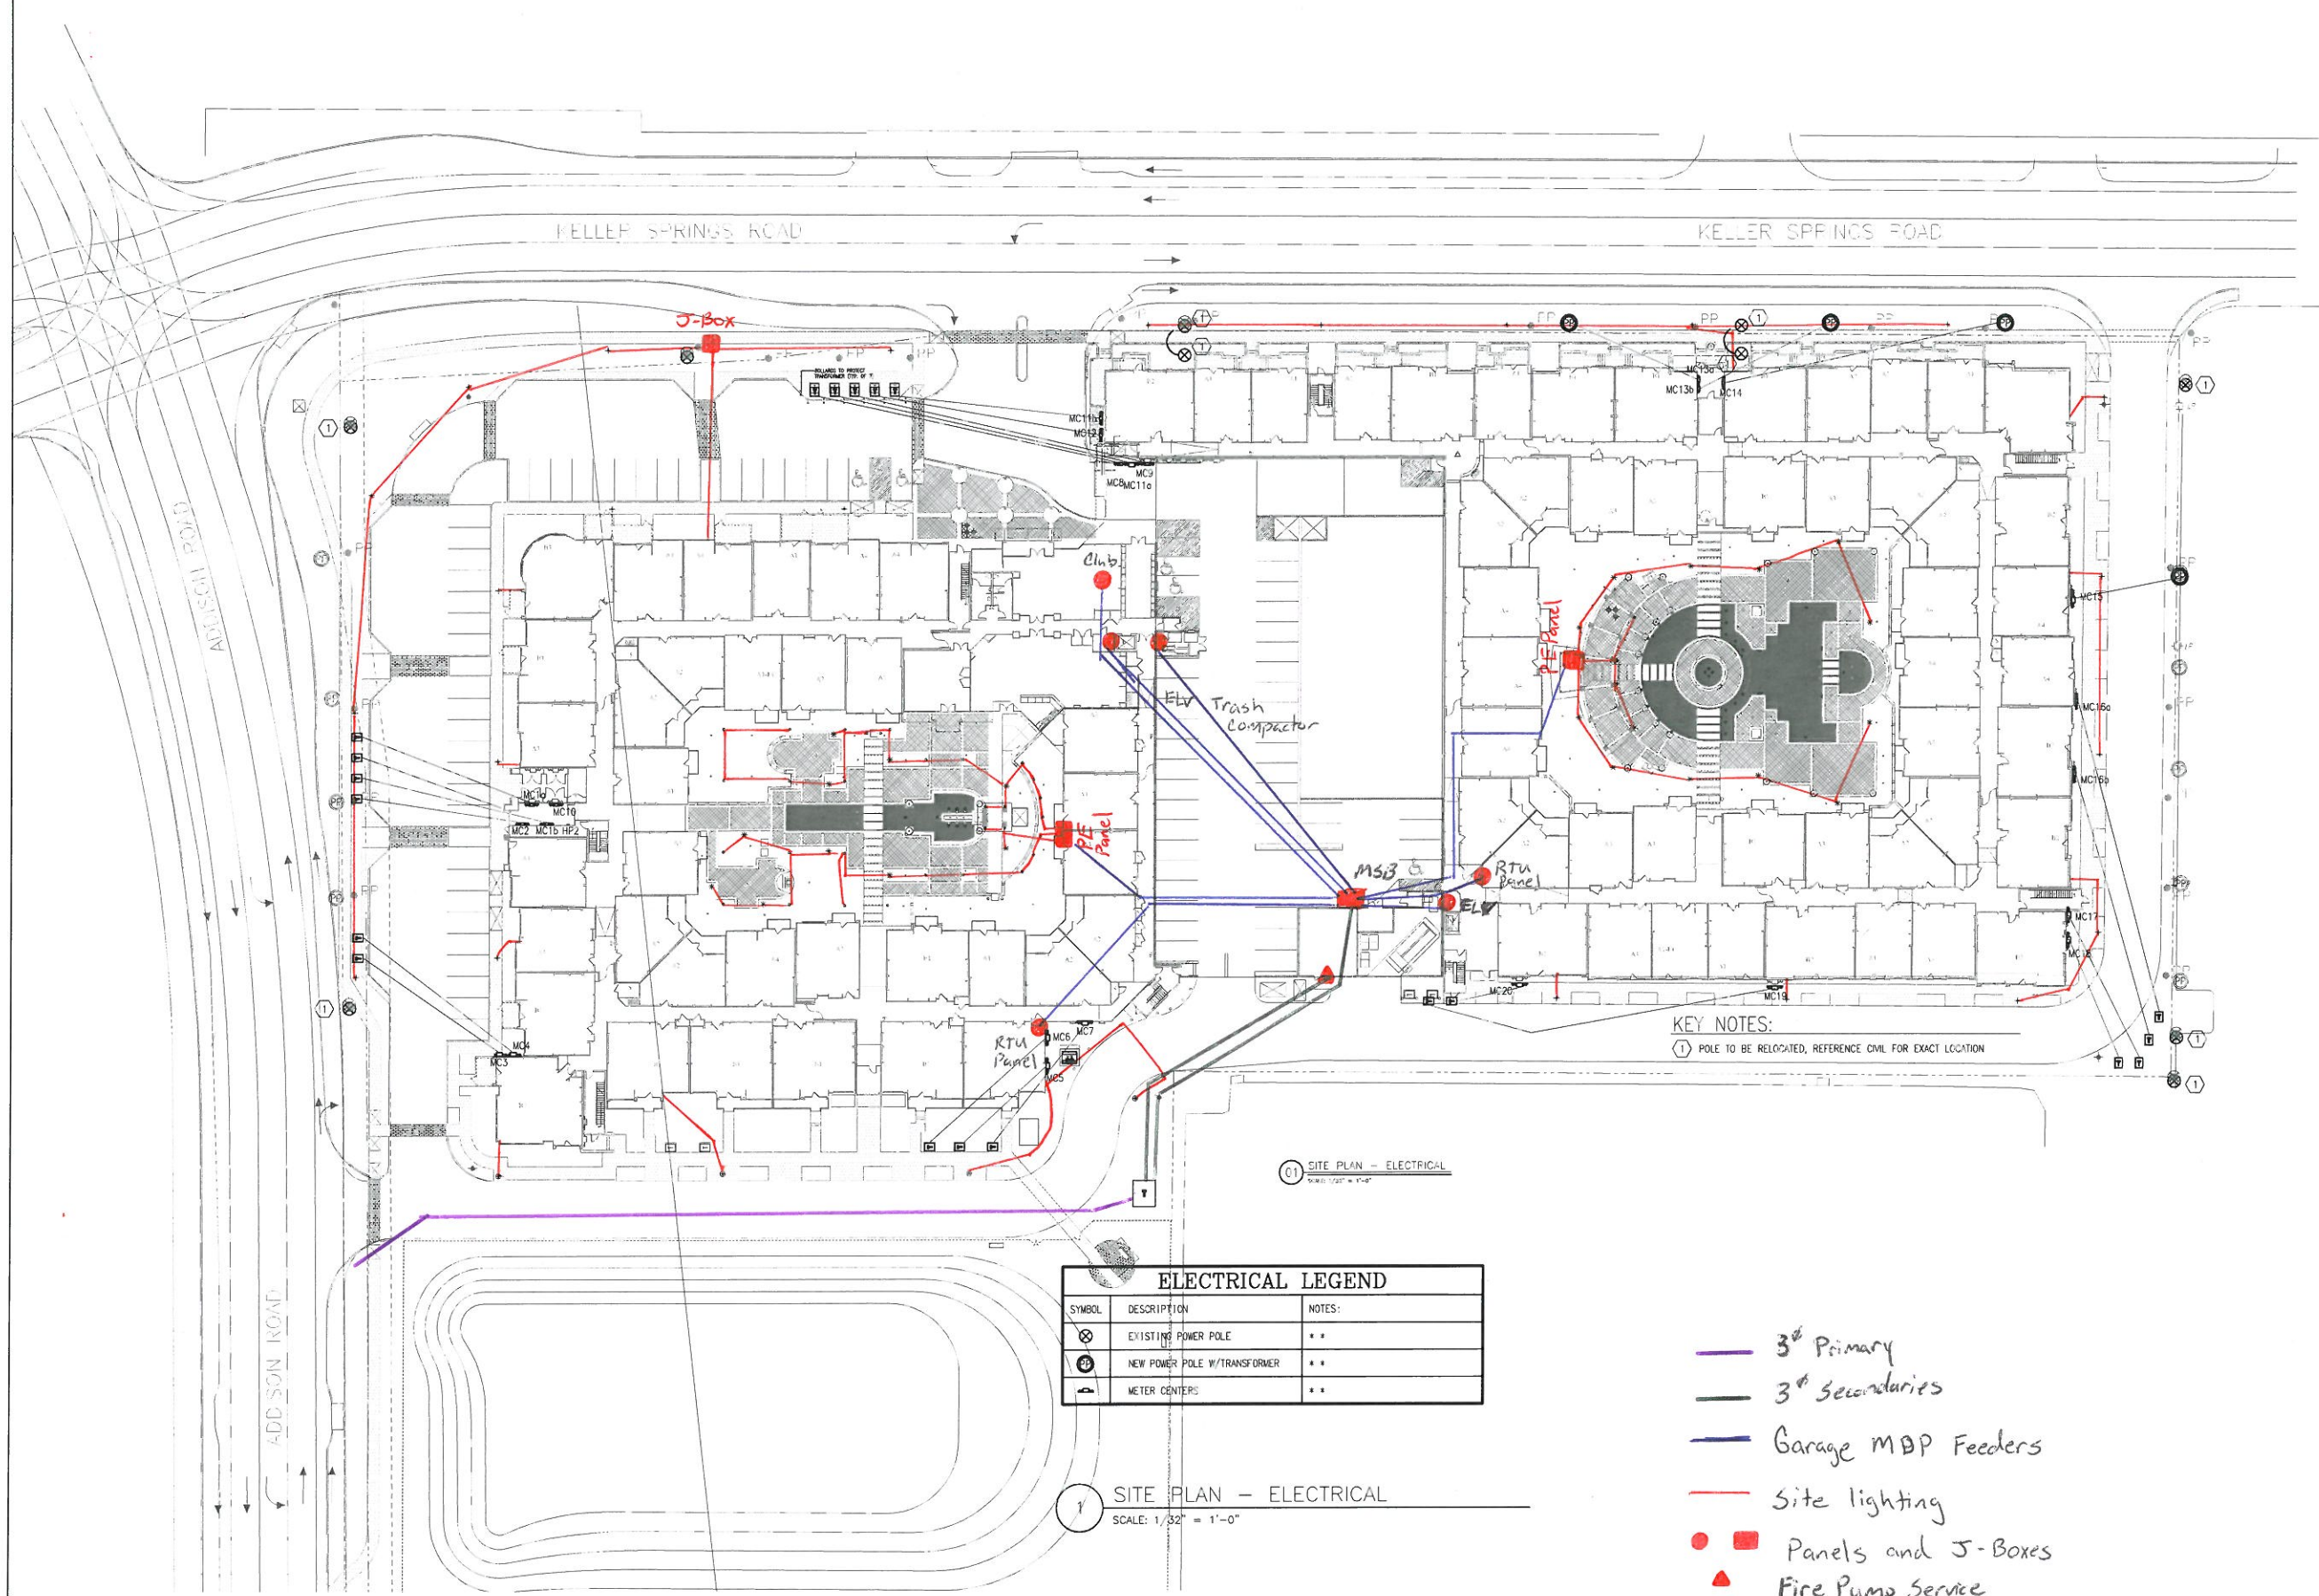

ELECTRICAL LEGEND		
SYMBOL	DESCRIPTION	NOTES
⊗	EXISTING POWER POLE	**
⊕	NEW POWER POLE W/TRANSFORMER	**
⊖	METER CENTER	**

- 3rd Primary
- 3rd Secondaries
- Garage MBP Feeders
- Site lighting
- Panels and J-Boxes
- ▲ Fire Pump Service

1 SITE PLAN - ELECTRICAL
SCALE: 1/32" = 1'-0"

01 SITE PLAN - ELECTRICAL
SCALE: 1/32" = 1'-0"