




REVISIONS

KELLER SPRINGS LOFTS

LOFT APARTMENTS IN ADDISON, TEXAS

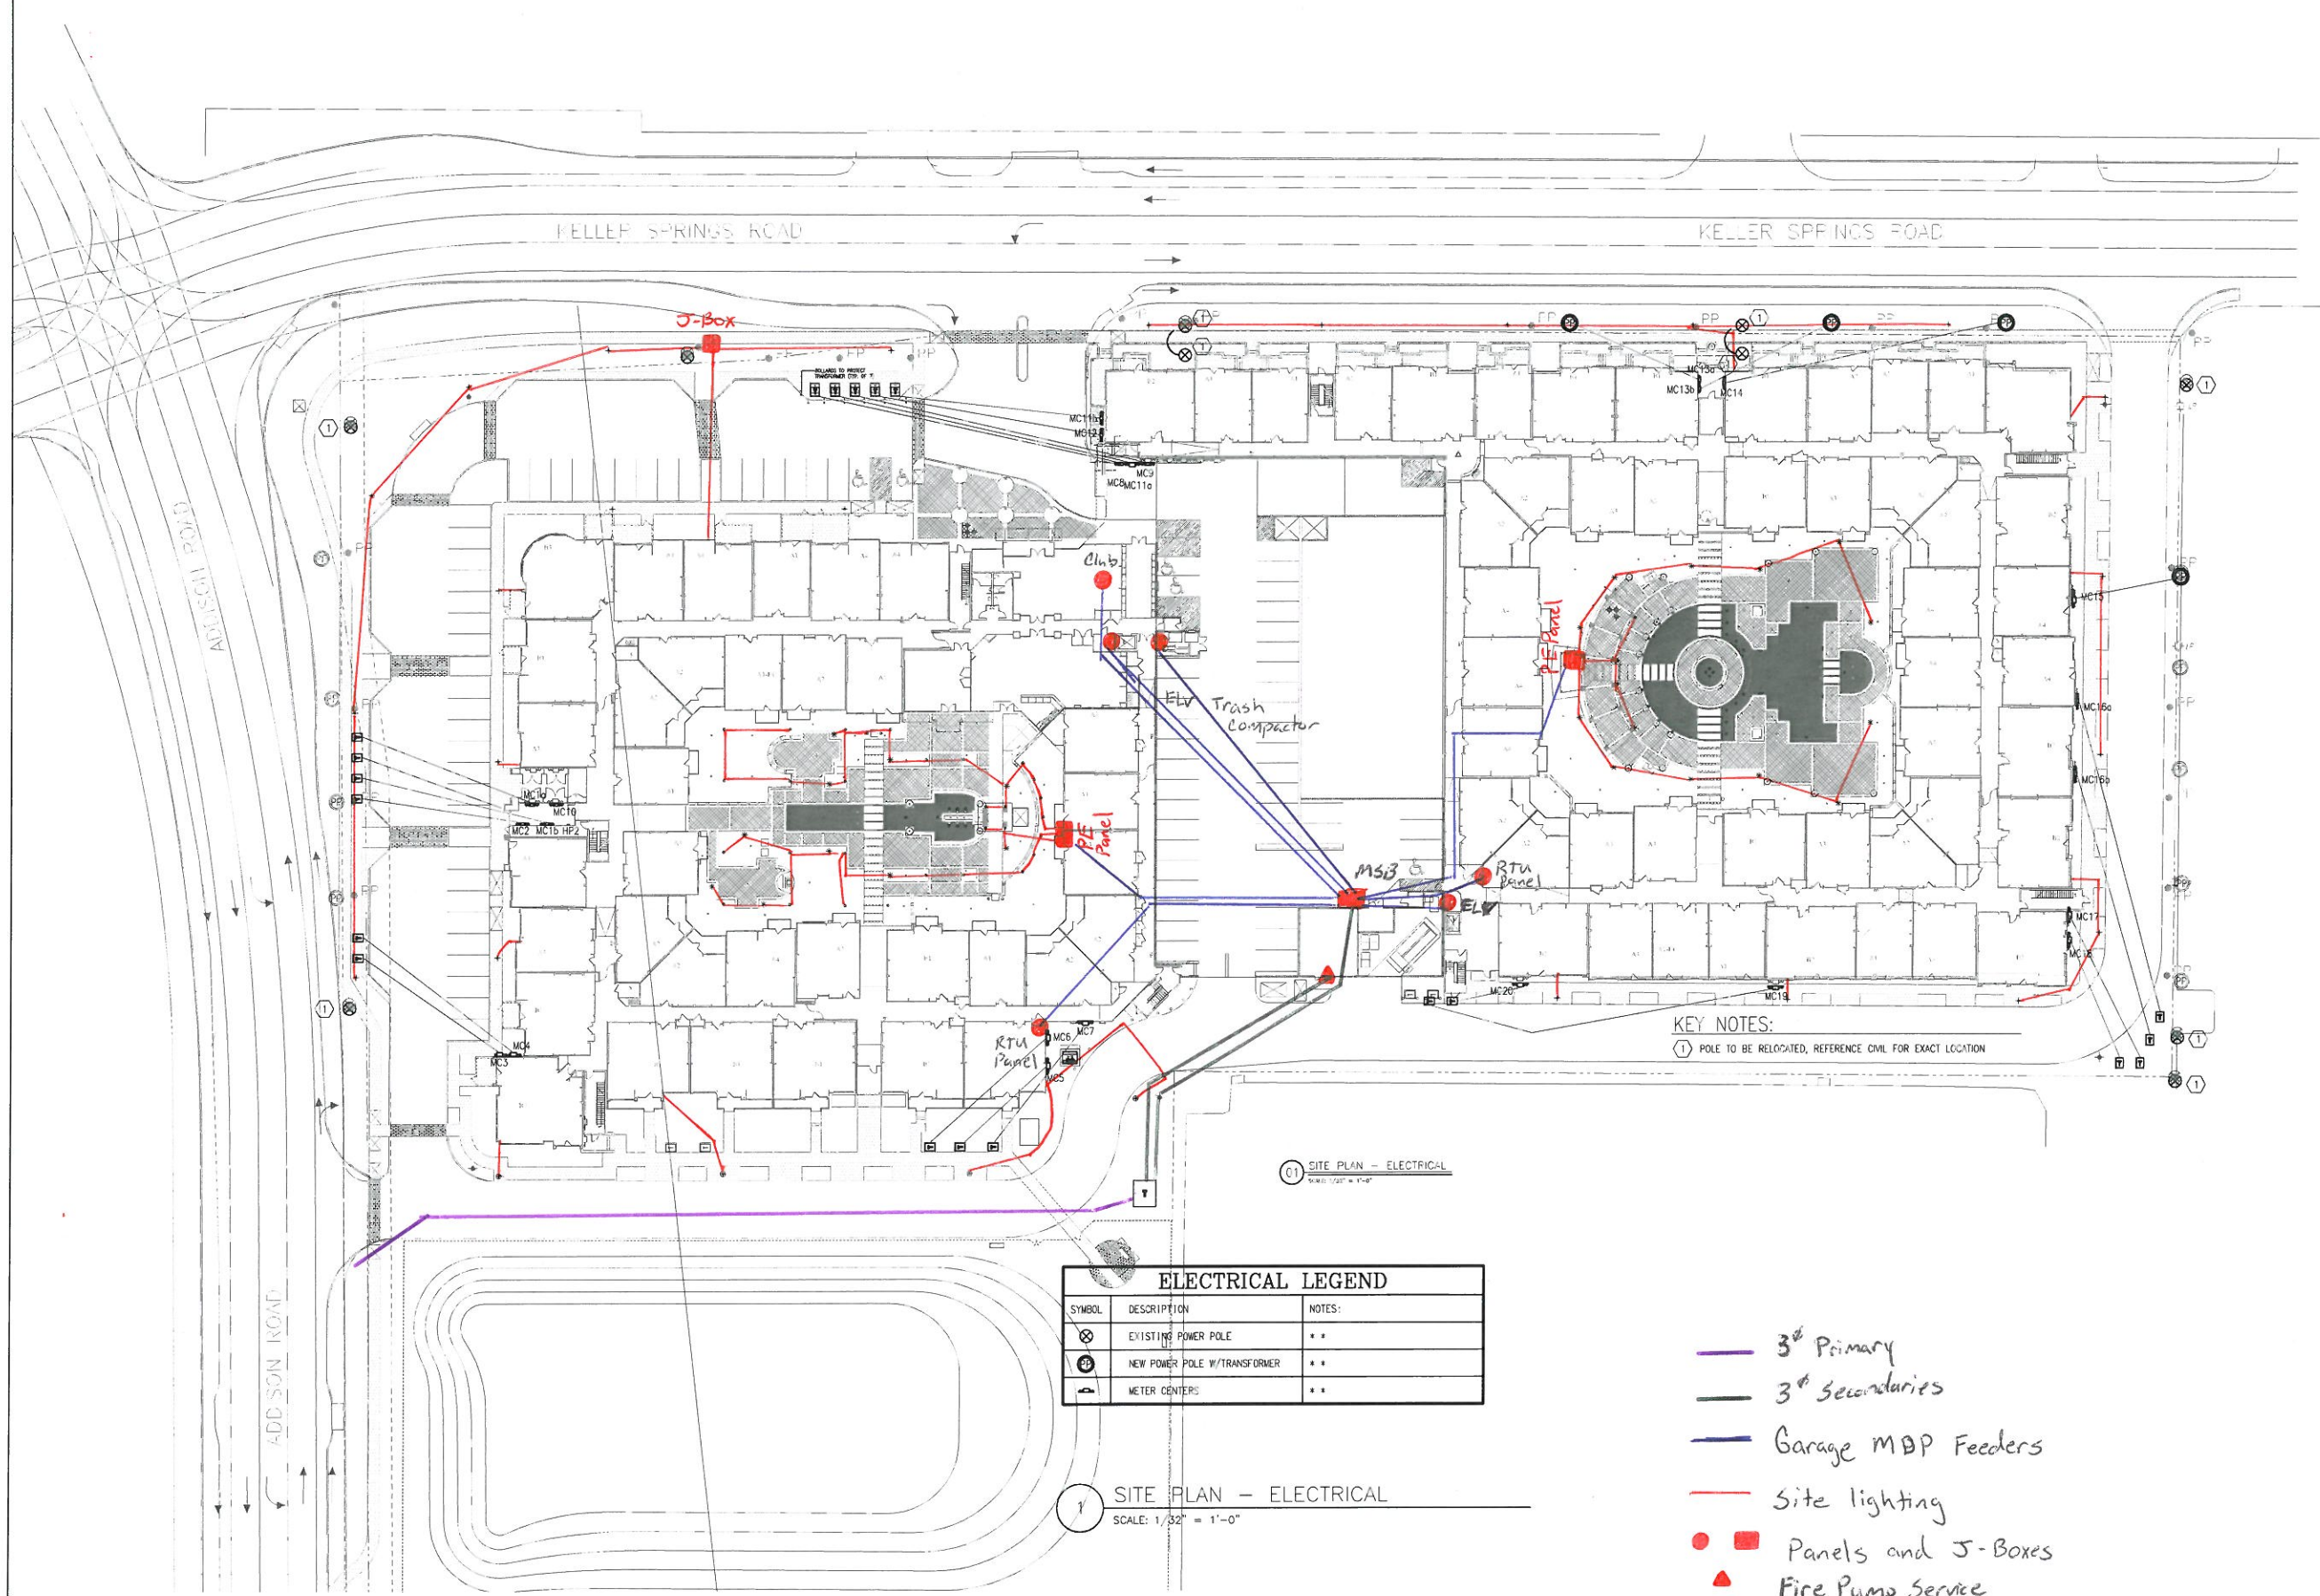

KEY NOTES:
 ① POLE TO BE RELOCATED, REFERENCE CIVIL FOR EXACT LOCATION

① SITE PLAN - ELECTRICAL
 SCALE: 1/32" = 1'-0"

ELECTRICAL LEGEND		
SYMBOL	DESCRIPTION	NOTES
⊗	EXISTING POWER POLE	**
⊕	NEW POWER POLE W/TRANSFORMER	**
⊖	METER CENTER	**

- 3rd Primary
- 3rd Secondaries
- Garage MBP Feeders
- Site lighting
- Panels and J-Boxes
- ▲ Fire Pump Service

① SITE PLAN - ELECTRICAL
 SCALE: 1/32" = 1'-0"

BGO
 architects
 4144 N. Central Expy.
 Suite 855
 Dallas, TX 75204
 214.520.8878
 bgoarchitects.com

DATE
 08-19-11

PROJECT
 1130355

SHEET NUMBER

E-10.1

**SITE PLAN
 ELECTRICAL**

JSE Jordan & Skala Engineers
 14740 Addison Road, Suite 330
 Dallas, TX 75244-3126
 V. 972.340.1400 F. 972.340.1613
 Project Number: 1130355 Title: From Register Item # F-4090
 Drawn By: NJ Checked By: RAD