



① PLUMBING & FIRE PROTECTION PLAN
SCALE: 1" = 50'

- KEY NOTES:
- ① INCLUDE A #12 COPPER WIRE IN THE LENGTH OF TRENCH WITH THE PVC PIPE.
 - ② IMBED CONTROL CONDUIT IN CONCRETE ADJACENT TO POWER CONDUITS. REF: SHEET E164 FOR POWER CONDUITS.

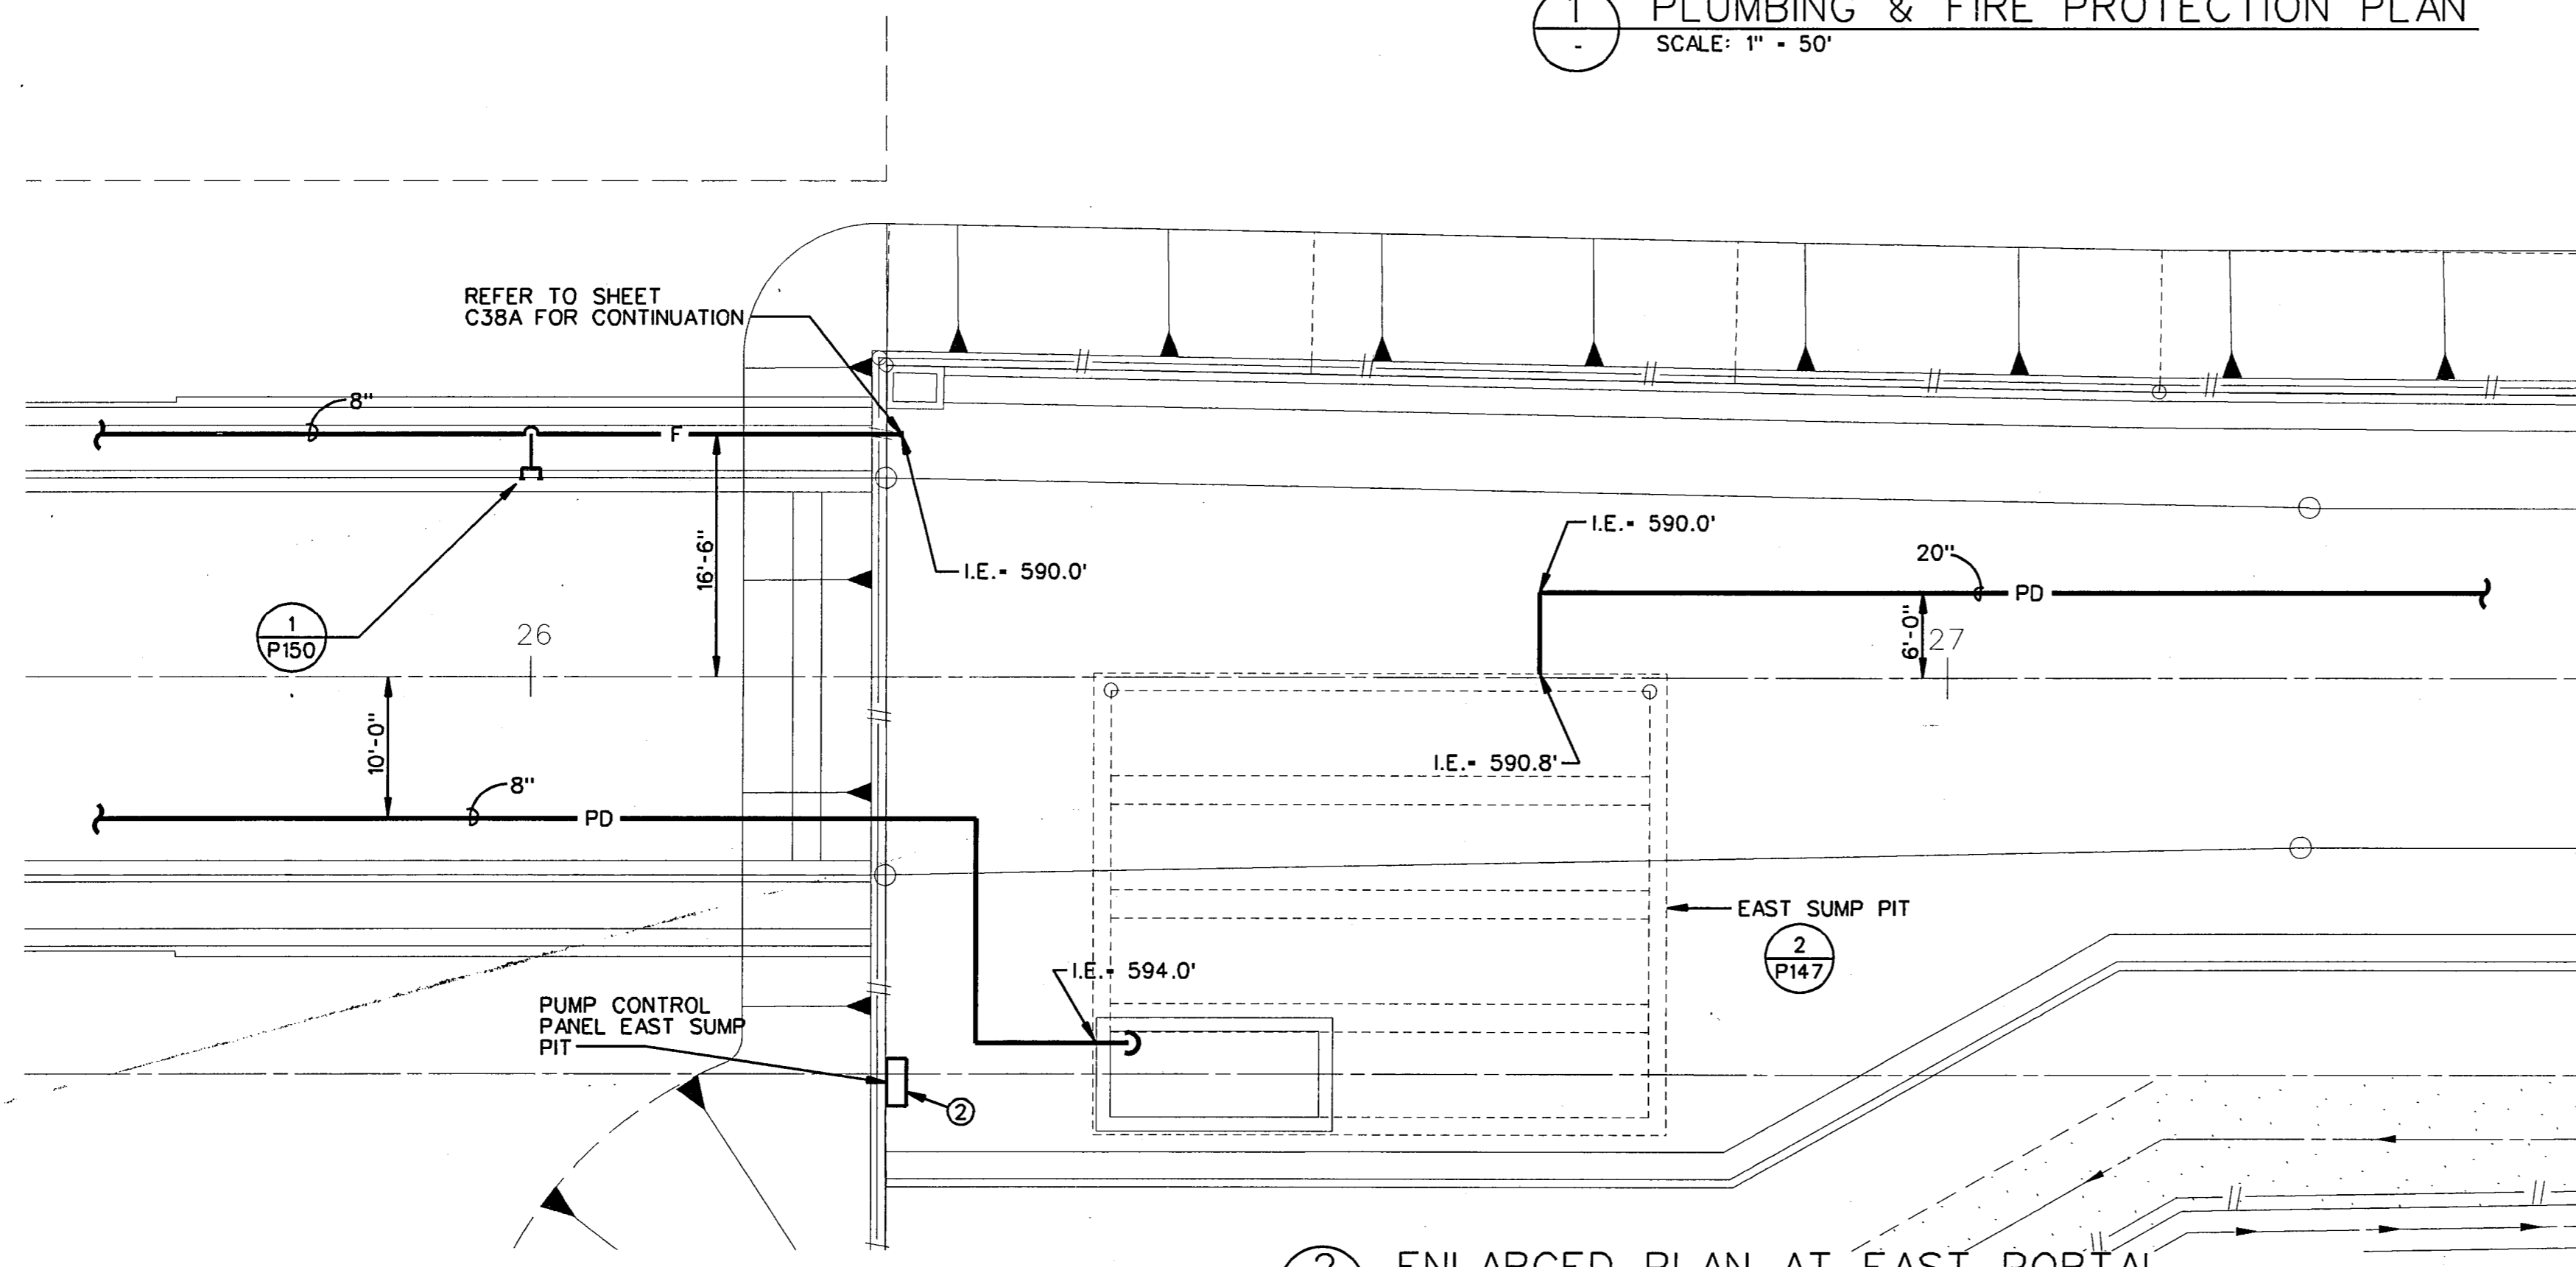

② ENLARGED PLAN AT EAST PORTAL
SCALE: 1" = 10'

FINAL RECORD
DRAWING
Date: 12/25/99

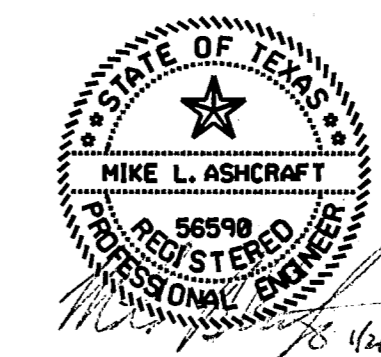

THE SEAL APPEARING ON THIS DOCUMENT WAS AUTHORIZED BY MIKE L. ASHCRAFT, P.E., 56590 ON SEPTEMBER 9, 1996

No.	REVISION	BY	DATE
TEXAS TURNPIKE AUTHORITY ADDISON AIRPORT TUNNEL			
TUNNEL FIRE PROTECTION & PLUMBING PLAN			
HDR Engineering, Inc.			SECTION XIII
DRAWN: WTD	DATE: 12/05/96	DESIGNED: MLA	DATE: 08/28/96
CHECKED: BL	DATE: 08/28/96	SCALE: 1" = 50'	
CONTRACT No. DNT-260 SHEET P146 OF 166			

FILE: p:\additun\adn\adup103.dgn
DATE: 23-Apr-96 20:01