




EXTERIOR LIGHT FIXTURE SCHEDULE				
SYMBOL	DESCRIPTION	MFG. #	QUAN.	REMARKS
ⓐ	150 W INCANDESCENT RECESSED, 110V.	HALO # H-7 W/ #4266 REFL. CONE	8	MOUNT IN CANOPY SOFFIT
ⓑ	250W MERCURY VAPOR SURFACE MTD. FLOOD-LIGHT, 208 V.	HUBBEL # MNM-250C-112	5	REFER EXT. ELEVATIONS FOR EXACT MOUNTING LOCATIONS
ⓒ	100 W MERCURY VAPOR W/ 18" Ø OPAL WHITE GLOBE ON 8' POLE, 110V.	SPALDING #802 W/ #902-8' POLE (BRONZE FINISH, NO PAINT REQ'D)	9	MOUNT ON CONC. BASE REF. P 108, PROVIDE W.P. 110V CUT-LETS, OUTLETS TO BE CONT. POWERED - UNSWITCHED

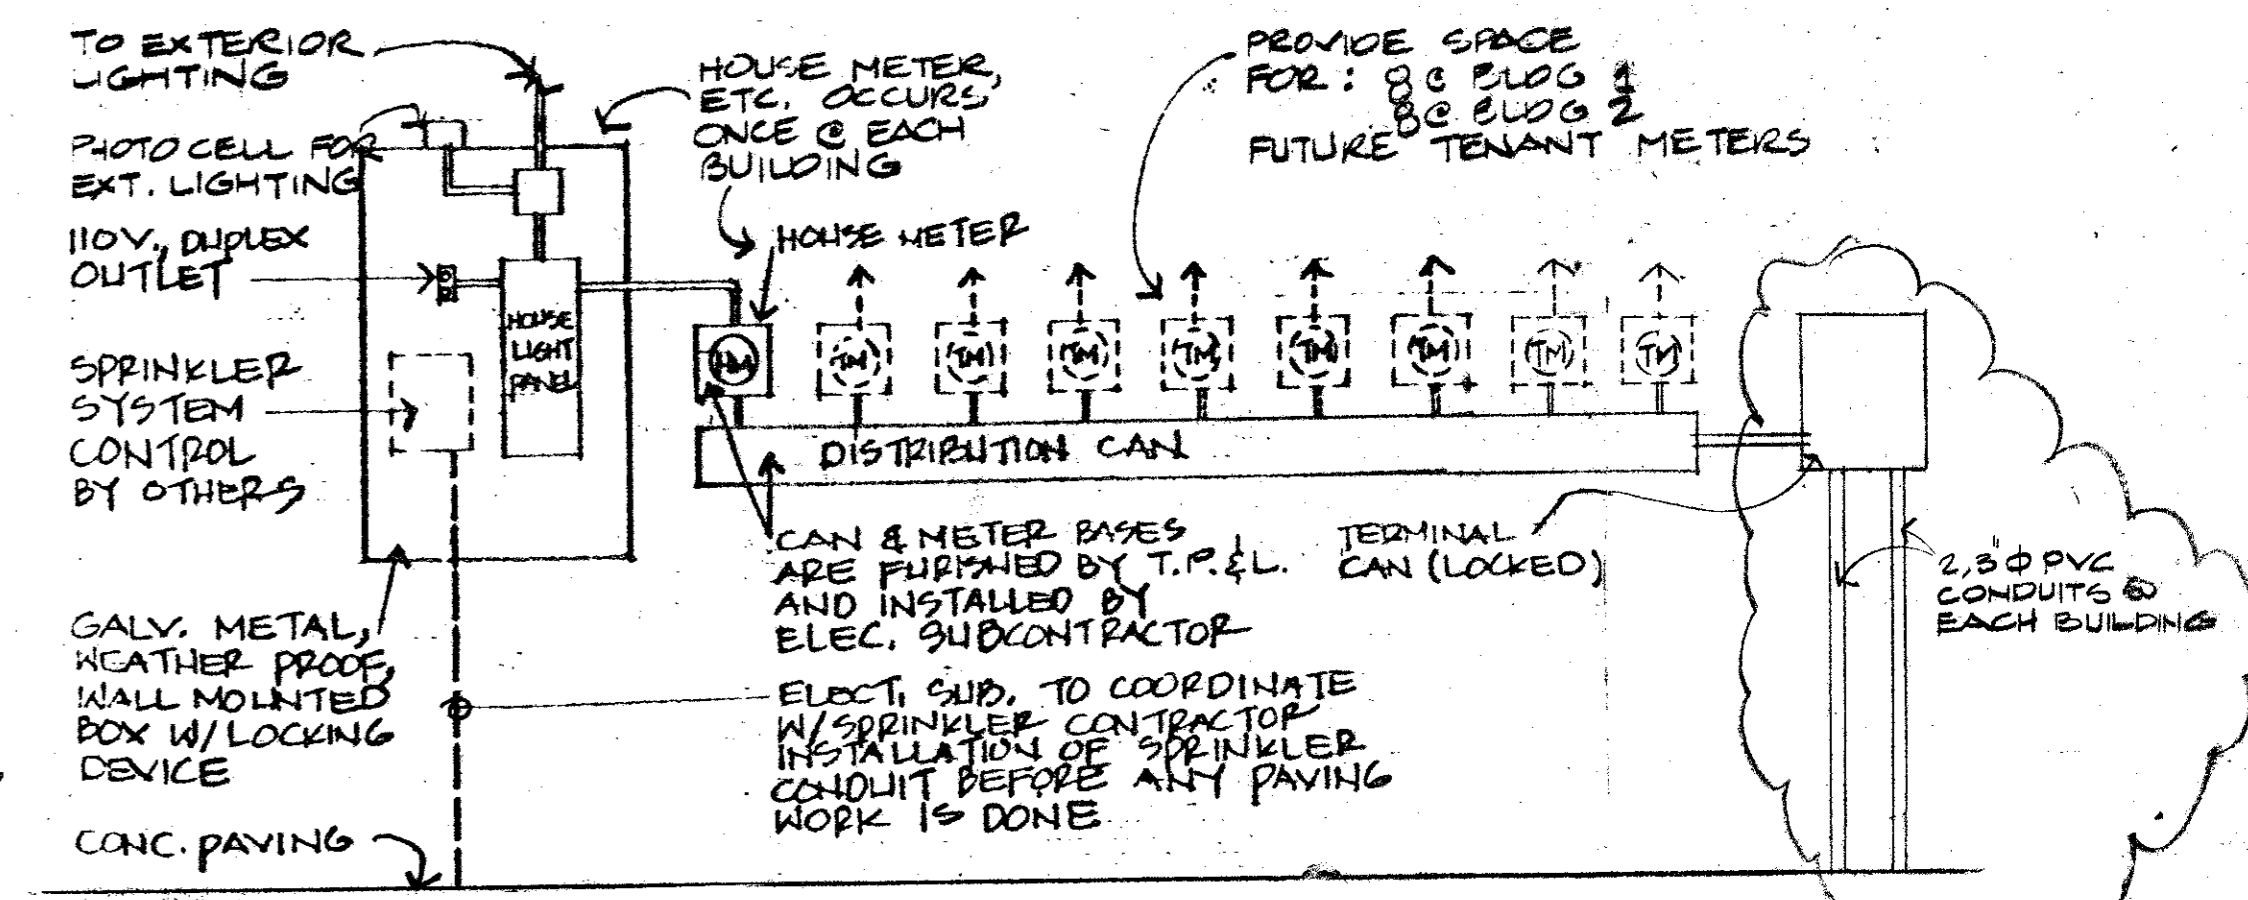

U102 ELECTRICAL SCHEMATIC  
NO SCALE

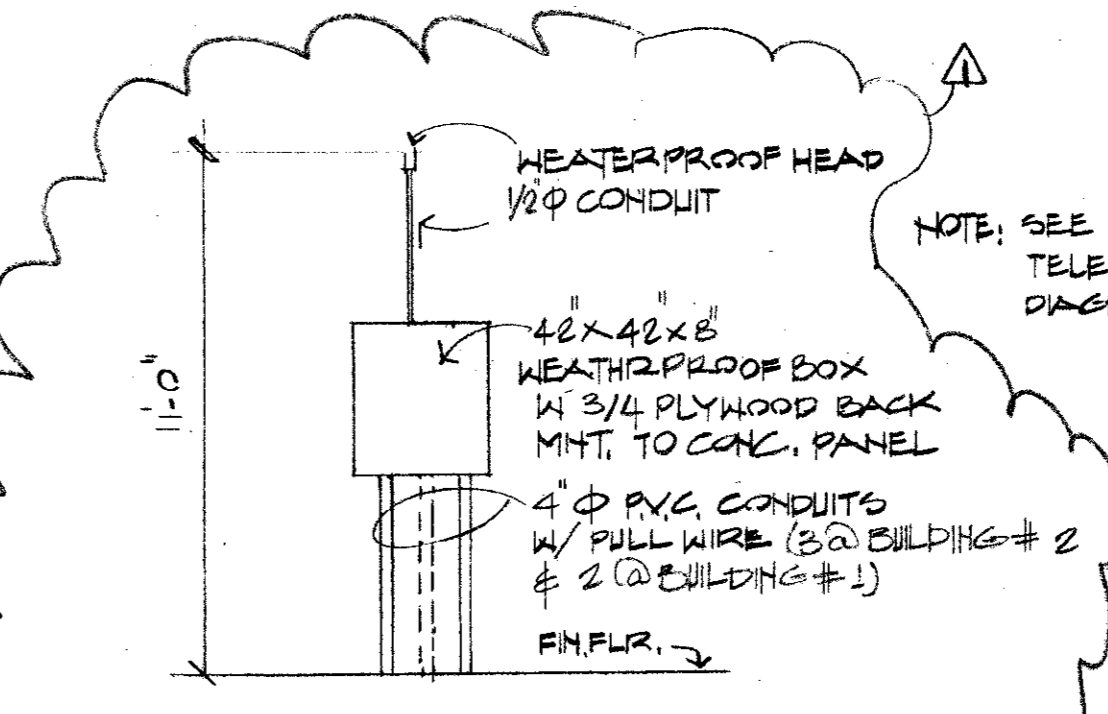


U103 TELE. SCHEMATIC  
NO SCALE

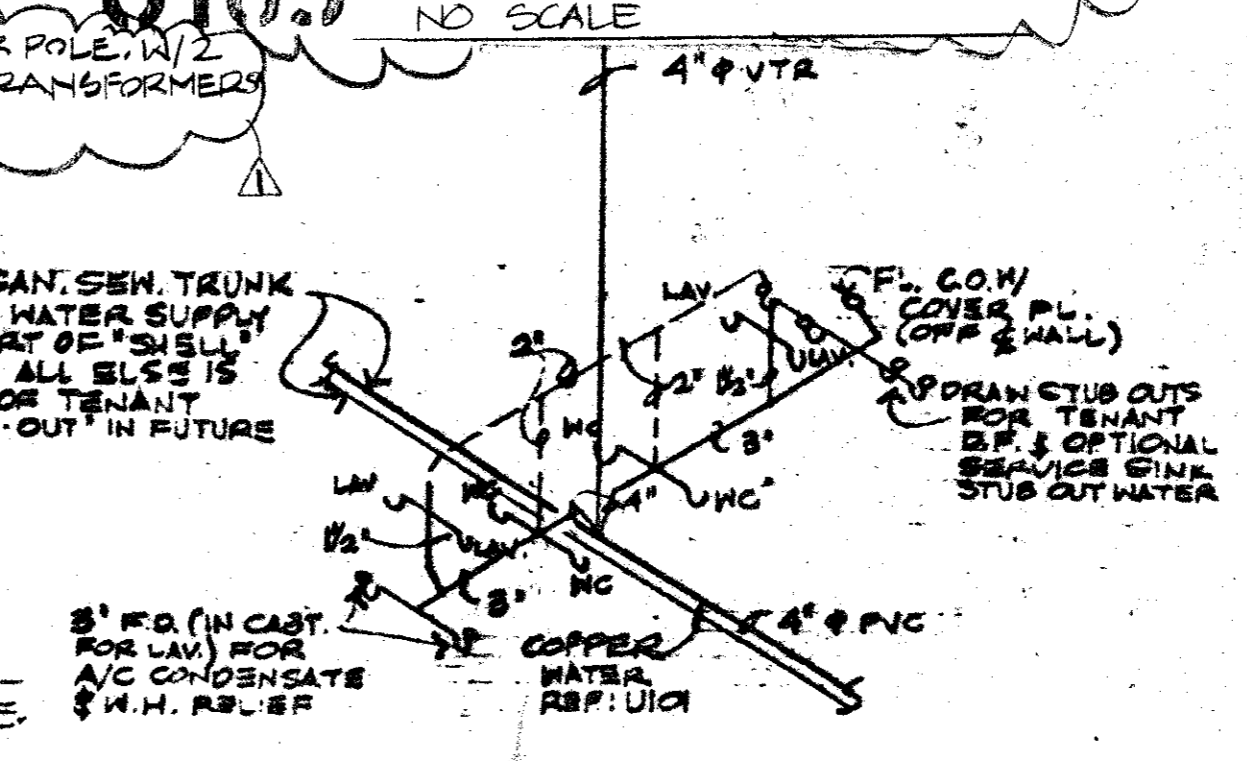

U104 SCHEMATIC PLUMBING RISER  
NO SCALE

**UTILITY NOTES**

1. THIS PLAN INDICATES TOTAL SITE UTILITIES FOR OVERALL COORDINATION AMONG ALL TRADES.
2. VERIFY EXISTENCE, LOCATIONS AND SIZES OF ALL EXISTING UTILITIES SHOWN ON THIS SHEET BEFORE STARTING WORK.
3. GRAVITY FLOW SEWER TO BE INSTALLED BEFORE ALL OTHER SUBSURFACE UTILITIES, BY PLUMBING CONTRACTOR.
4. REFER TO BUILDING LEASE PLANS FOR EXACT LOCATIONS OF TOILETS AND COFFEE BARS.
5. PLUMBING CONTRACTOR TO INSTALL ENTIRE NEW WATER SERVICE SHOWN ON THIS SHEET.
6. 3\"/>

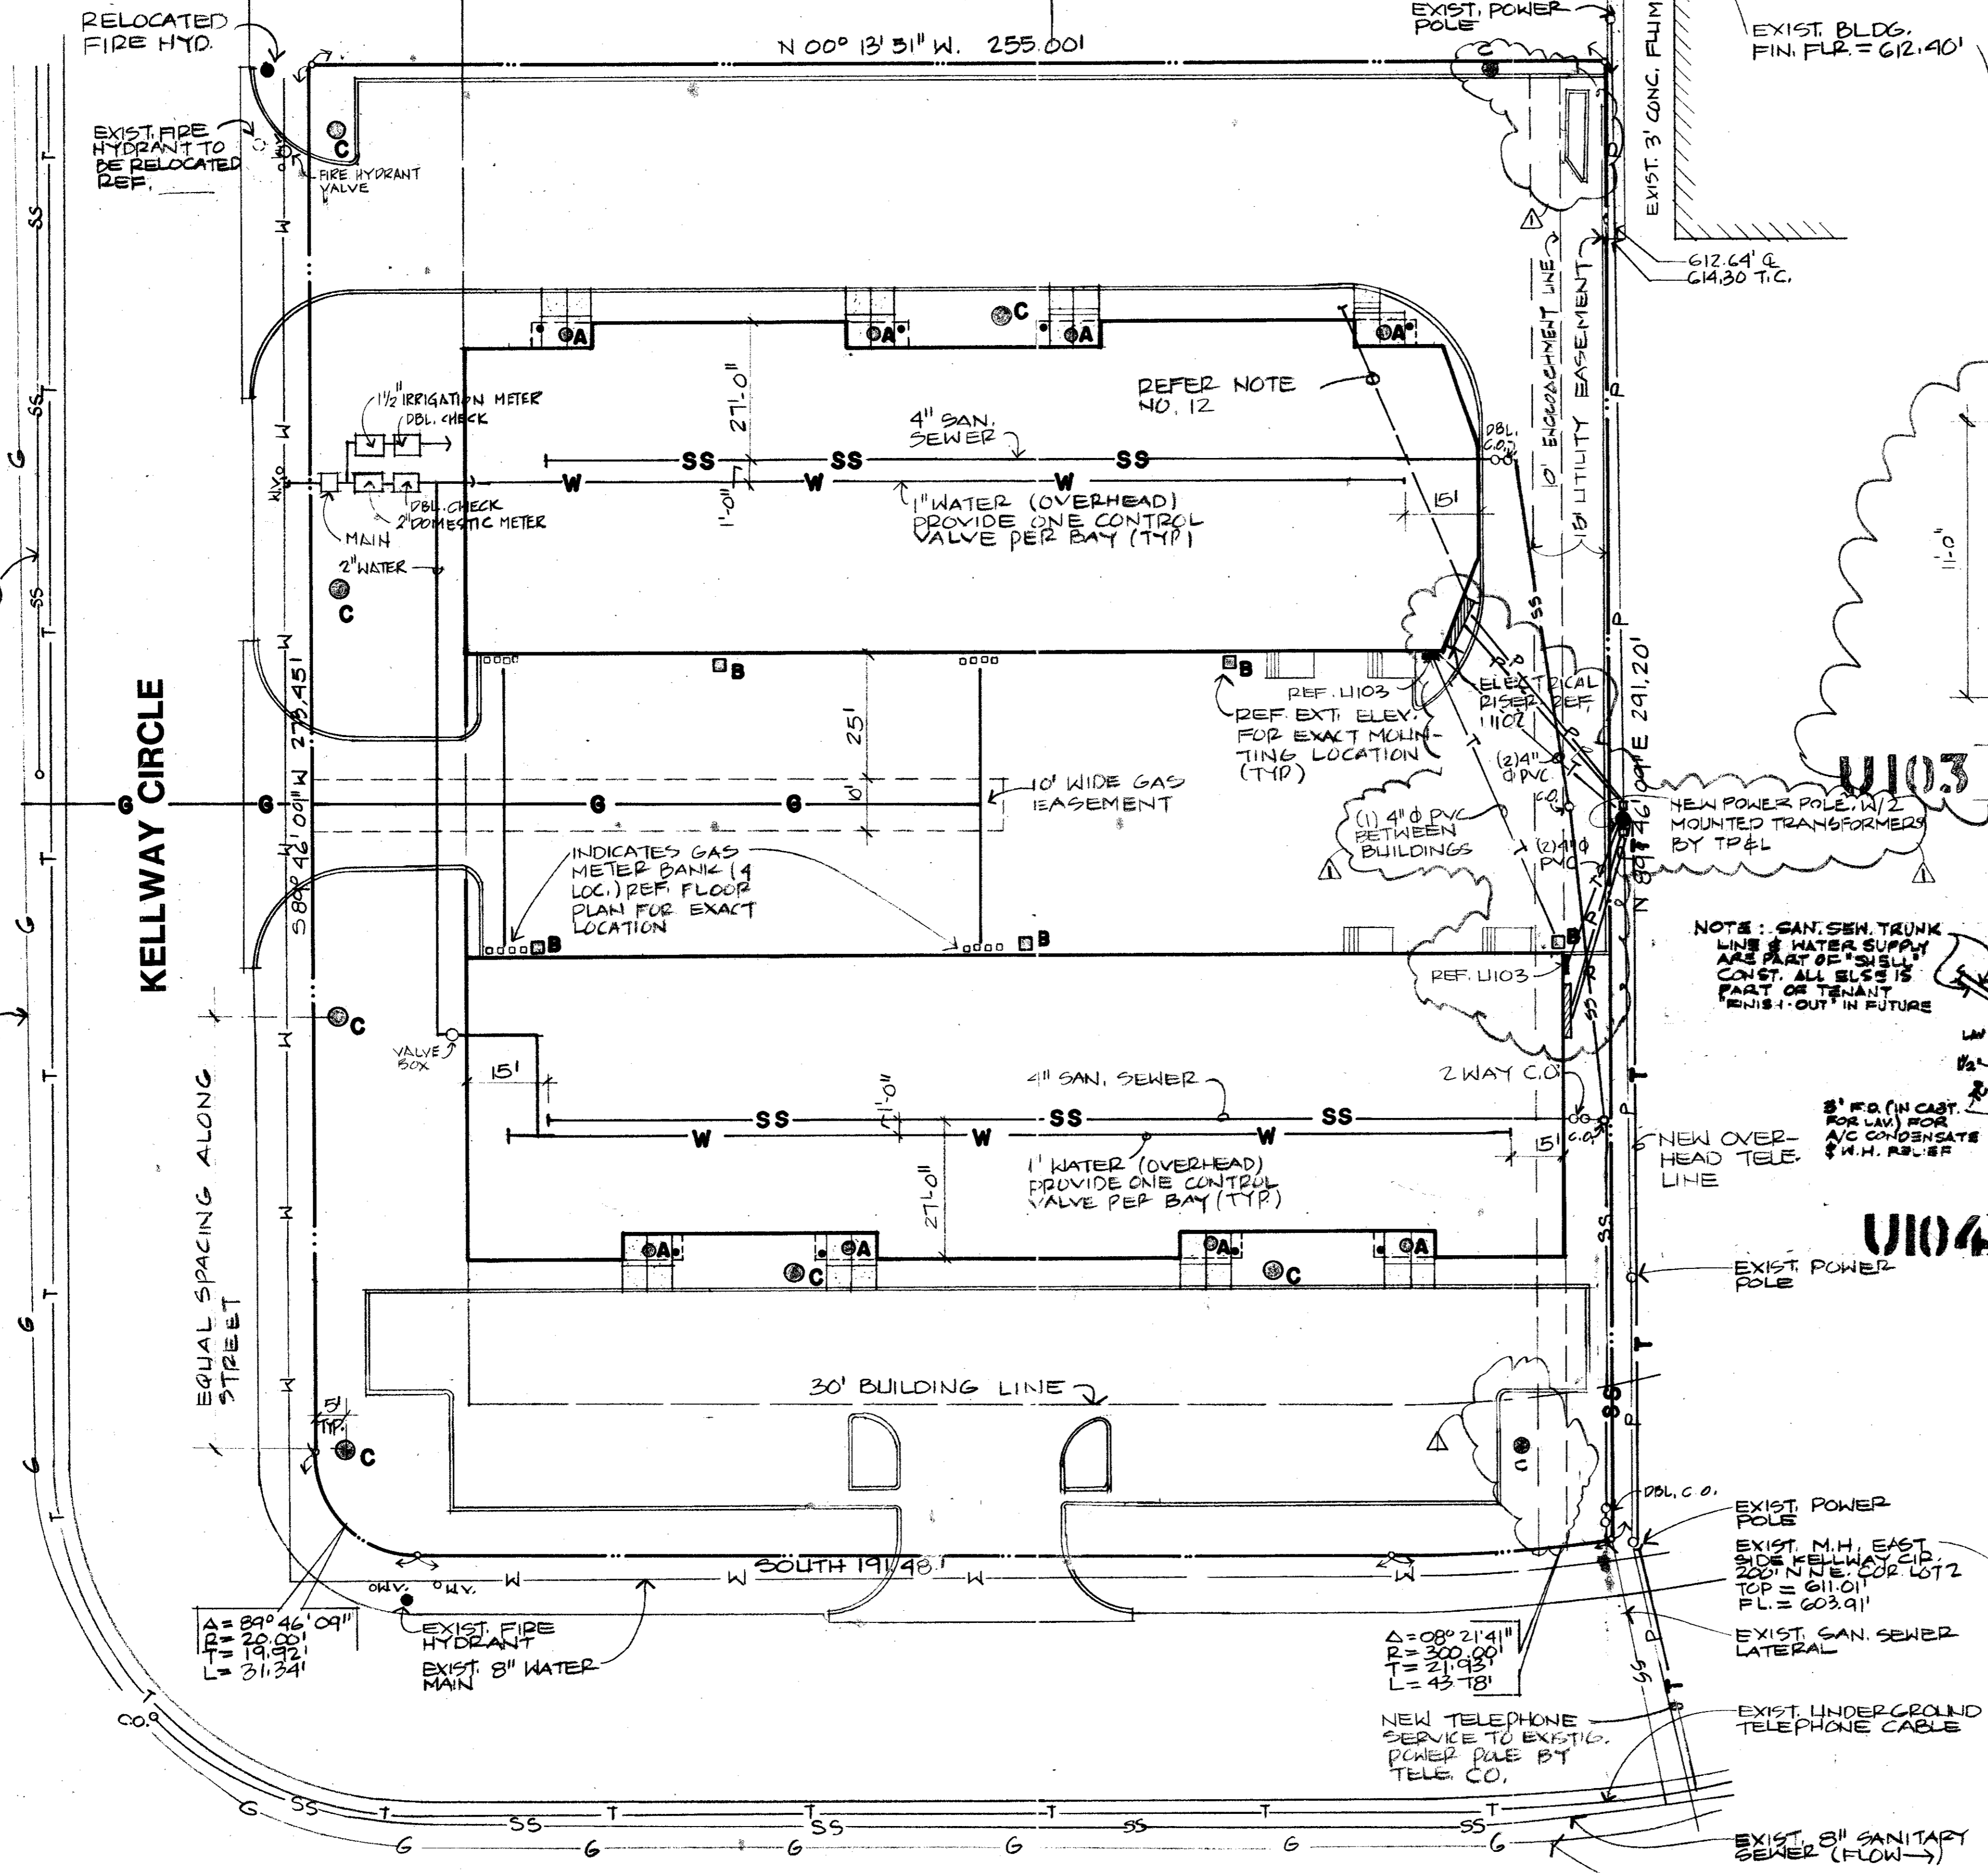

U101 UTILITY SITE PLAN  
SCALE: 1" = 20'-0"



REVISION WATER & SANITARY SEWER ROUTING PER MAG BUILT

Richard Ferrara Architect, Inc.  
4020 McEwen / Suite 120  
Dallas, Texas 75234  
214-980-7828

**KELLYWAY LIMITED**  
OFFICE / WAREHOUSE  
ADDISON TEXAS

Date 1/23/84  
Revision 4-13-84

Sheet 11  
Job 83-74

REVISION 12/27/84

4260-90  
Kellway Circle