



A LOWER LEVEL LIGHTING/POWER
SCALE: 1/4" = 1' - 0"

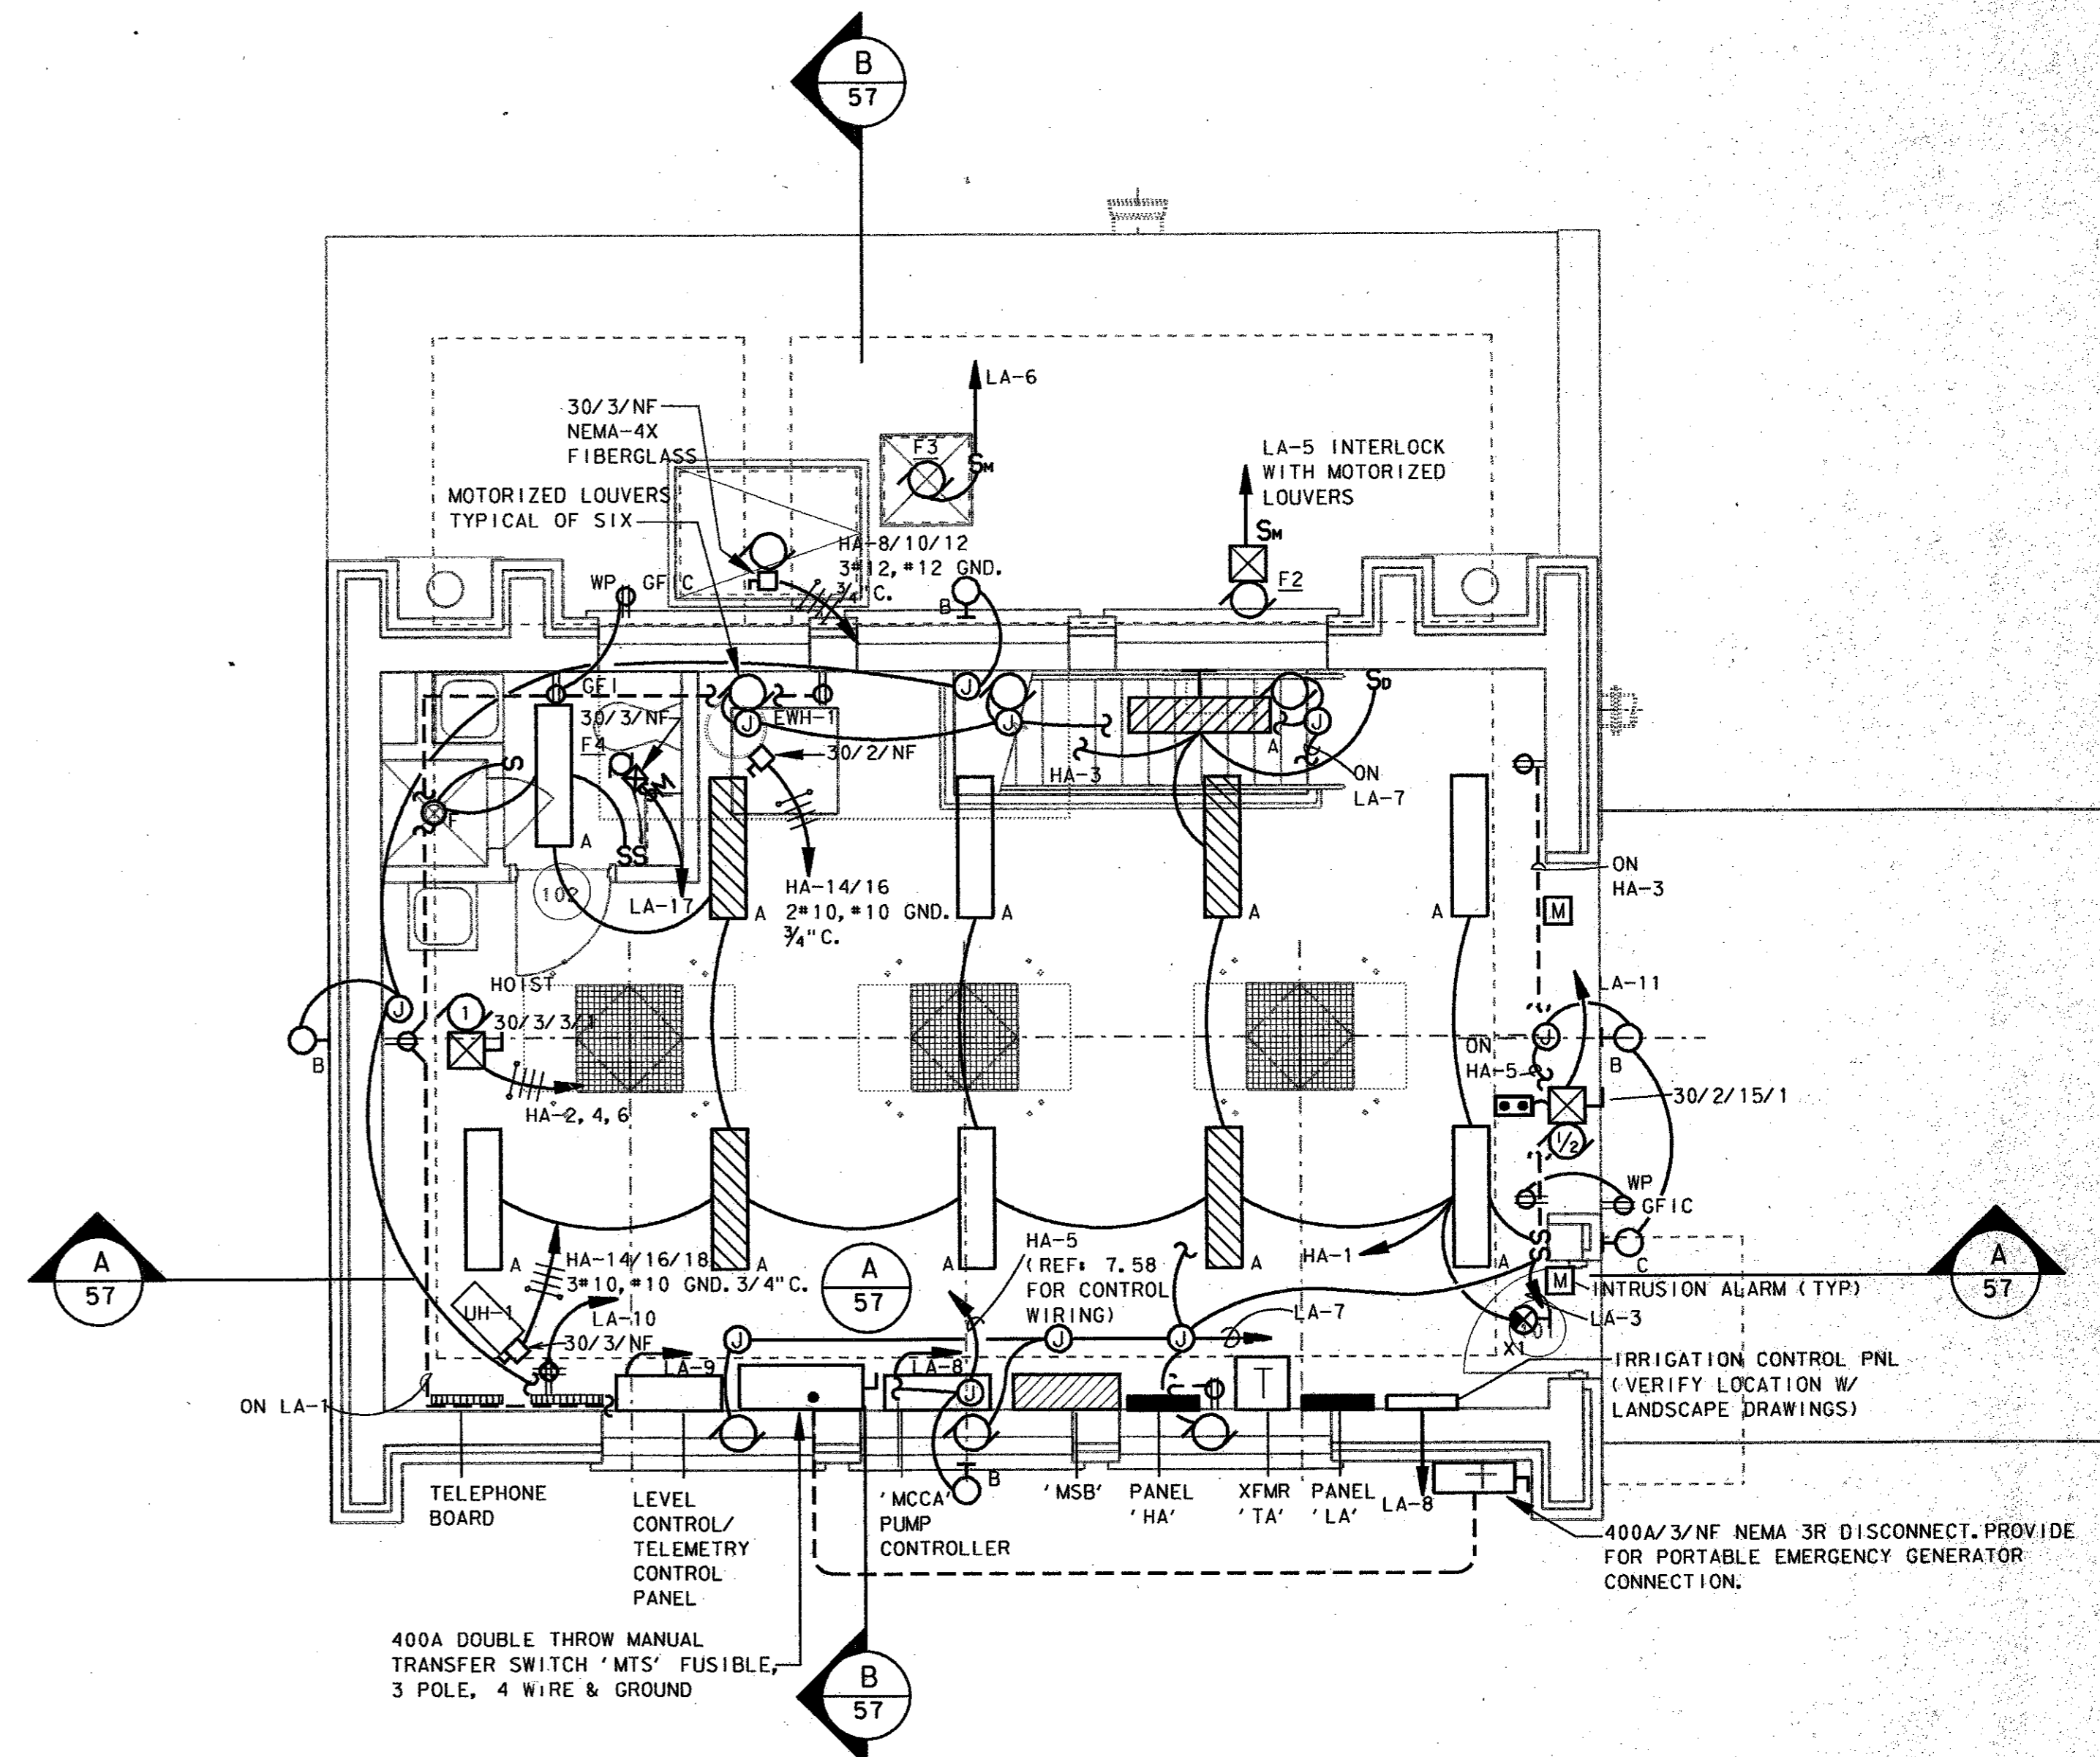

B GROUND LEVEL LIGHTING/POWER
SCALE: 1/4" = 1' - 0"

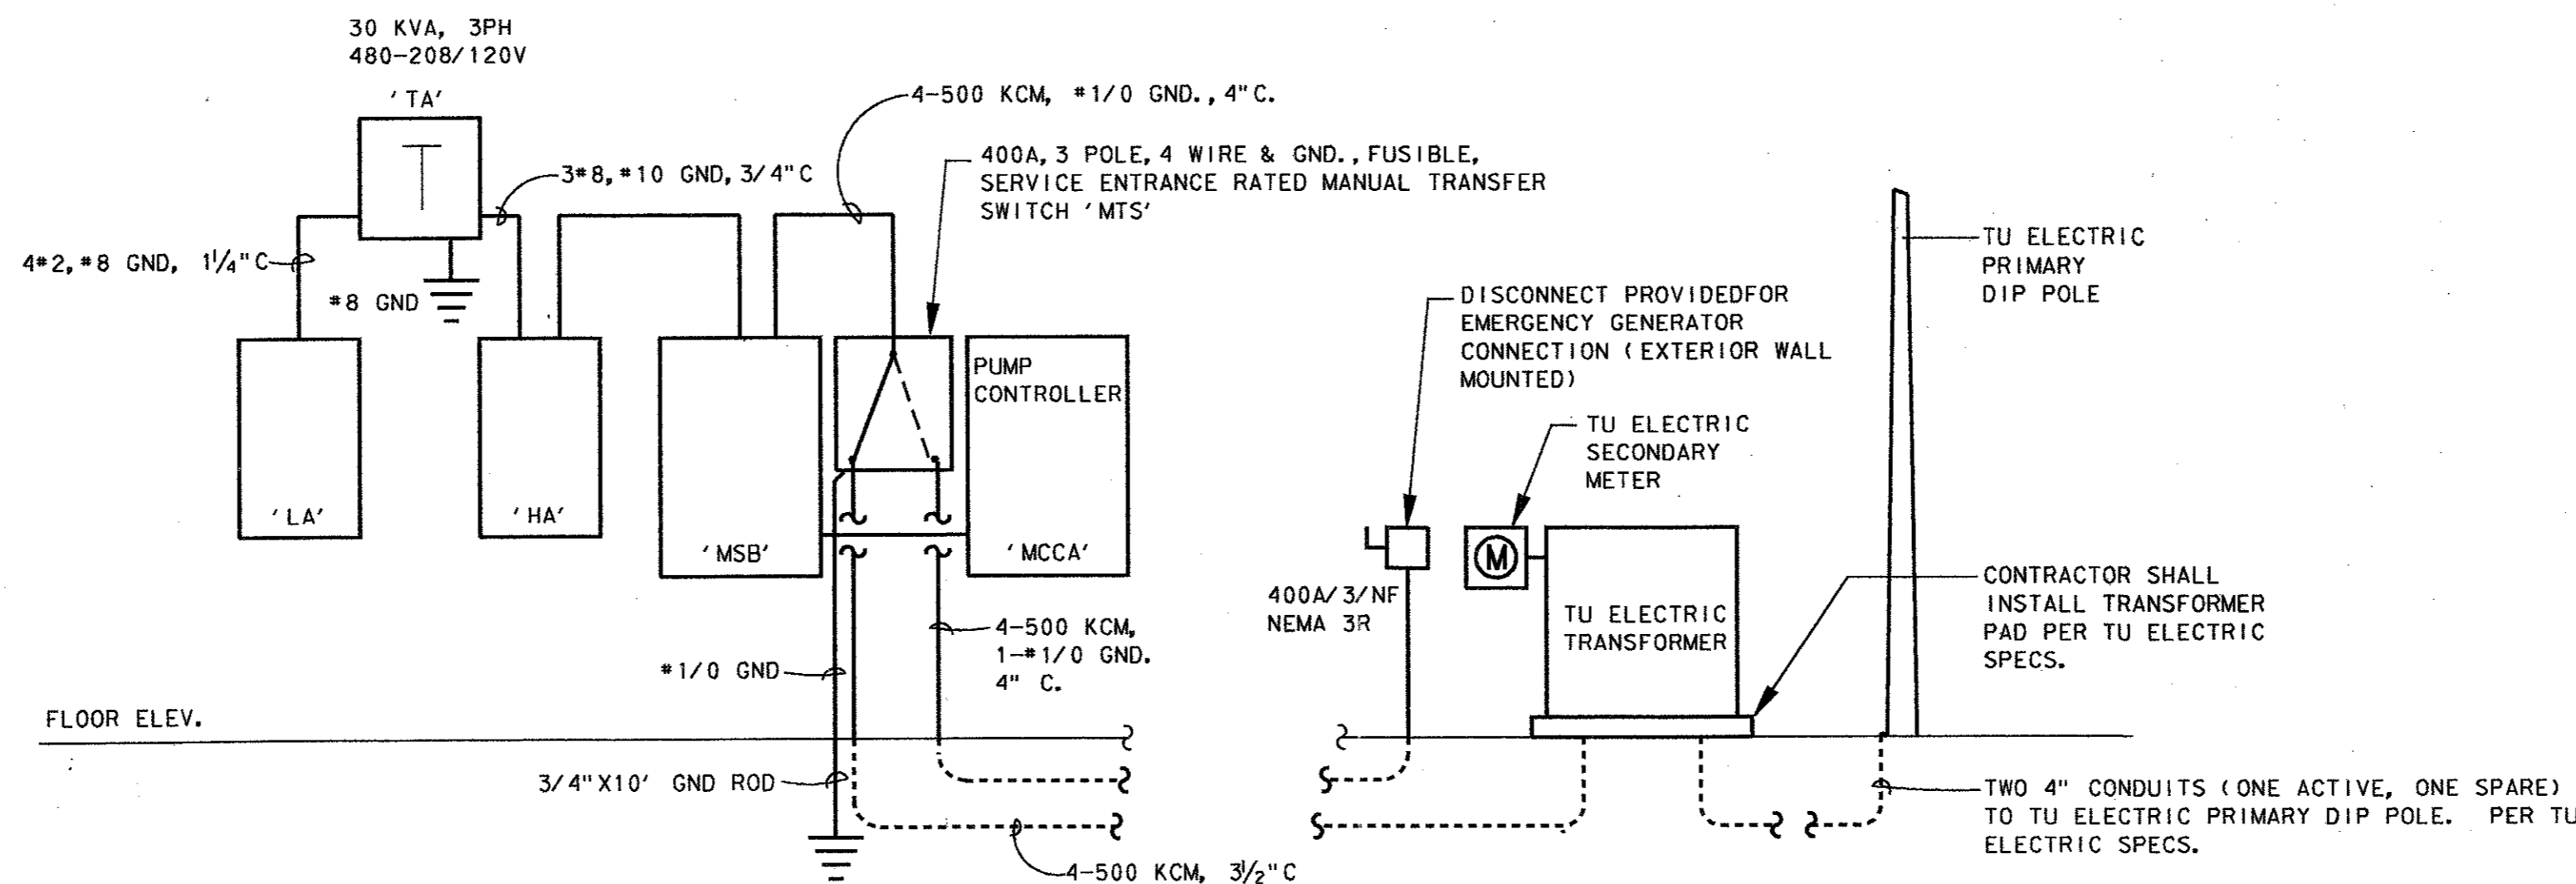

C ELECTRICAL RISER DIAGRAM
SCALE: NO SCALE

4			
3			
2			
1			
NO.	DATE	REVISION	APPROV.
TOWN OF ADDISON, TEXAS			
MIDWAY/BELTLINE SANITARY SEWER PHASE II			
LIFT STATION ELECTRICAL FLOOR PLAN			
Carter Burgess Consultants in Engineering, Architecture, Planning and the Environment CARTER & BURGESS, INC. 7950 ELMBROOK DRIVE, SUITE 250 DALLAS, TX 75247-4961			
Unit:	Scale:	Date:	04-05-96
Designed:	R. POWELL	Checked:	R. POWELL
Drawn:	J. WEBB	Approved:	J. Lindner
		Sheet:	56 of 63

