


HOT WATER BOILER SCHEDULE

MAKE	MODEL NO.	QTY.	LOCATION	BTH INPUT EA.	REC TO 100 REE EA.	GAS CON.	FLUE SIZE
LAARS	625-S	1 EA.	Bldg# 22	625,000	600 GPH	1"	12" φ
LAARS	750-S	2 EA.	Bldg# 23	750,000	720 GPH	1 1/4"	14" φ
LAARS	625-S	2 EA.	Bldg# 24	625,000	600 GPH	1"	12" φ

PLUMBING SYMBOLS	
SYMBOL	DESCRIPTION
(Symbol)	CITY SANITARY SEWER MAIN
(Symbol)	CITY WATER MAIN
(Symbol)	CITY WATER METER
(Symbol)	SANITARY SEWER PIPE
(Symbol)	SANITARY SEWER VENT PIPE
(Symbol)	COLD WATER SUPPLY PIPE
(Symbol)	HOT WATER SUPPLY PIPE
(Symbol)	HOT WATER RETURN PIPE
(Symbol)	VALVE BOX AND VALVES
(Symbol)	DOUBLE CHECK ASSEMBLY 45 IN. X 40 X
(Symbol)	GAS MAIN - INTERMEDIATE HIGH PRESSURE
(Symbol)	GAS SUPPLY PIPE - HIGH PRESSURE 3/8"
(Symbol)	GAS SUPPLY PIPE - LOW PRESSURE 1/2"
(Symbol)	GAS METER AND REGULATOR
(Symbol)	GAS REGULATOR
(Symbol)	GAS STOP
(Symbol)	GATE VALVE
(Symbol)	CHECK VALVE
(Symbol)	GLOBE VALVE
(Symbol)	ONE-WAY SANITARY SEWER CLEAN-OUT
(Symbol)	TWO-WAY SANITARY SEWER CLEAN-OUT
(Symbol)	WALL CLEAN-OUT
(Symbol)	FLOOR DRAIN
(Symbol)	ROOF DRAIN
(Symbol)	AREA DRAIN
(Symbol)	FROST PROOF HOSE BIB
(Symbol)	TEMP. PRES. AND RELIEF VALVE

NOTE: ALL SYMBOLS SHOWN MAY NOT NECESSARILY BE USED

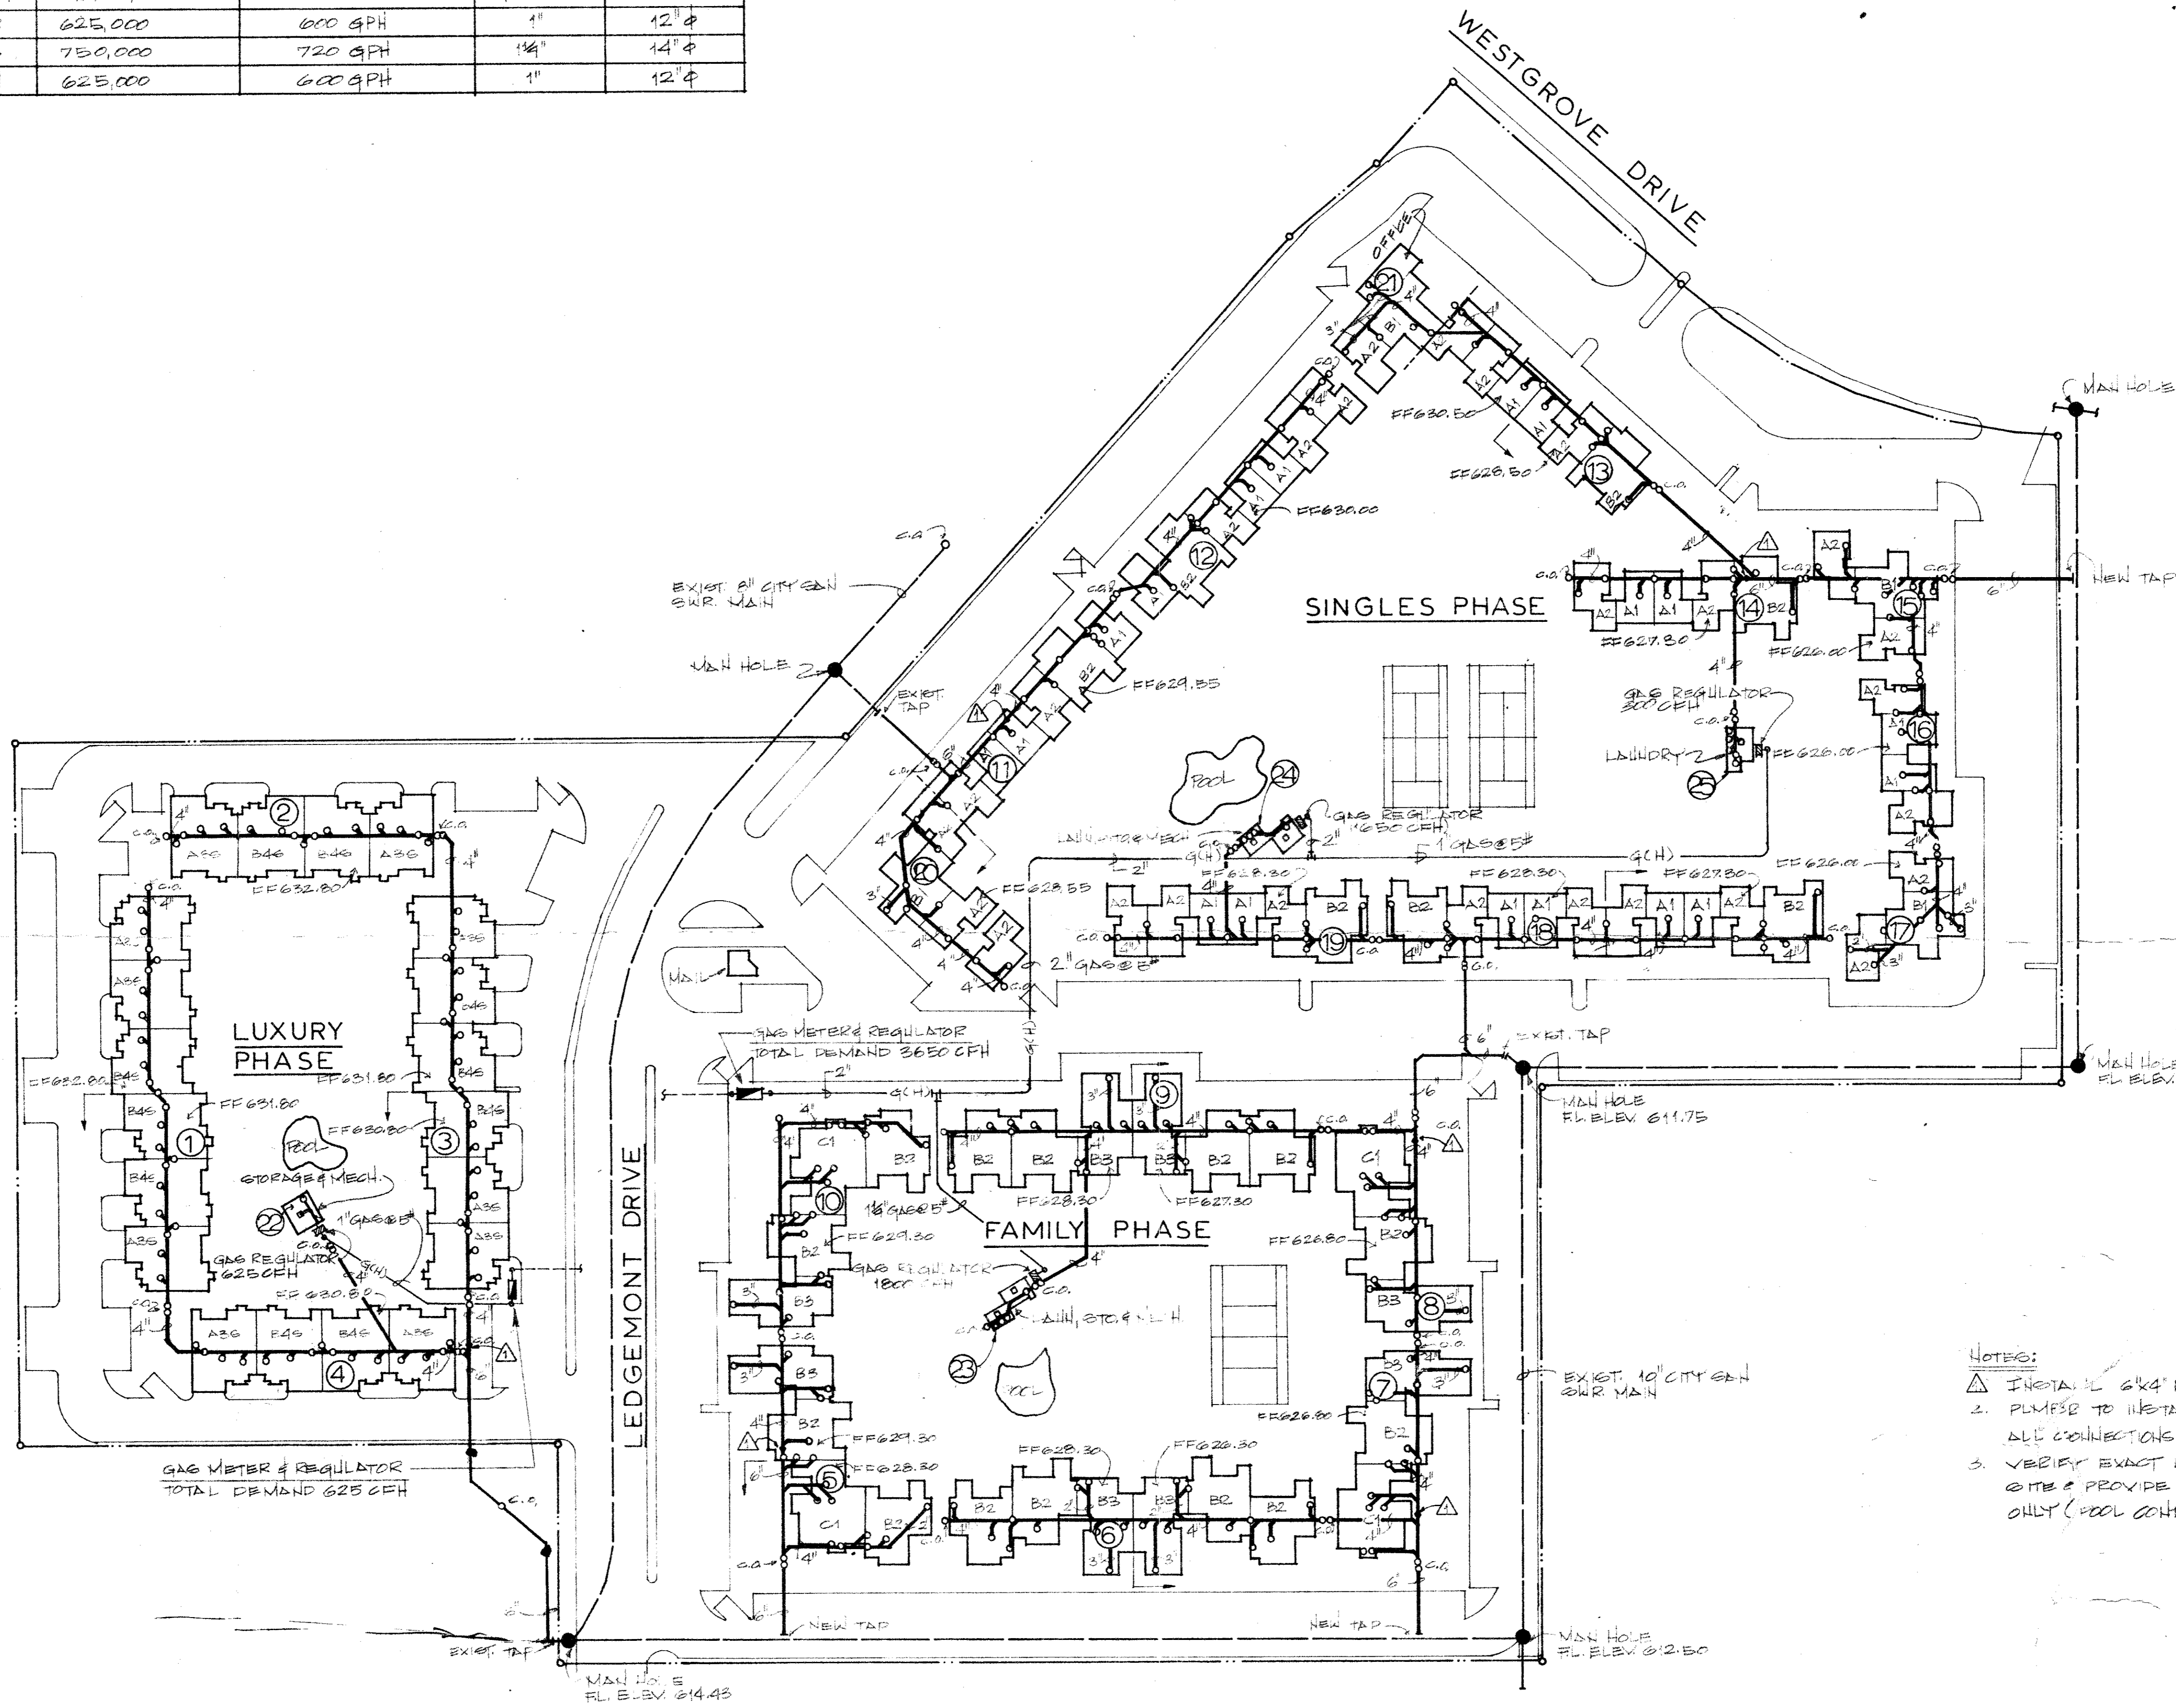

- NOTES:
1. INSTALL 1/2" 6"x4" REDUCER @ THIS LOCATION
 2. PUMPER TO INSTALL WATER METERS AND MAKE ALL CONNECTIONS RECD TO EXIST. CITY SAN. SWR MAIN
 3. VERIFY EXACT LOCATIONS OF POOL EQUIP @ JOB SITE & PROVIDE 2" DRAIN @ 2' SPLT ROUGH-IN ONLY (POOL CONTR TO MAKE FINAL CONN'S)



PLUMBING SITE PLAN - SANITARY SEWER & GAS PIPING
 SCALE: 1" = 50'-0"

REV: 8-21-79 (GH)

PLUMBING SITE PLAN THE FOUNTAINS - 184 UNITS 16400 LEDGEMONT DR.	Job No. 526
Tempo Mechanical A Texas Distributors Inc. Company 2252 Wisconsin St. Dallas, Texas 75229 Phone 214-241-9475	Date 7-22-79 Dwn By G.M. Ckd By Scale: 1" = 50'-0" Dwg No. 1 of 7