

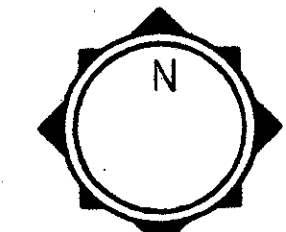


MARSH LANE

(100.0' FOOT RIGHT-OF-WAY)

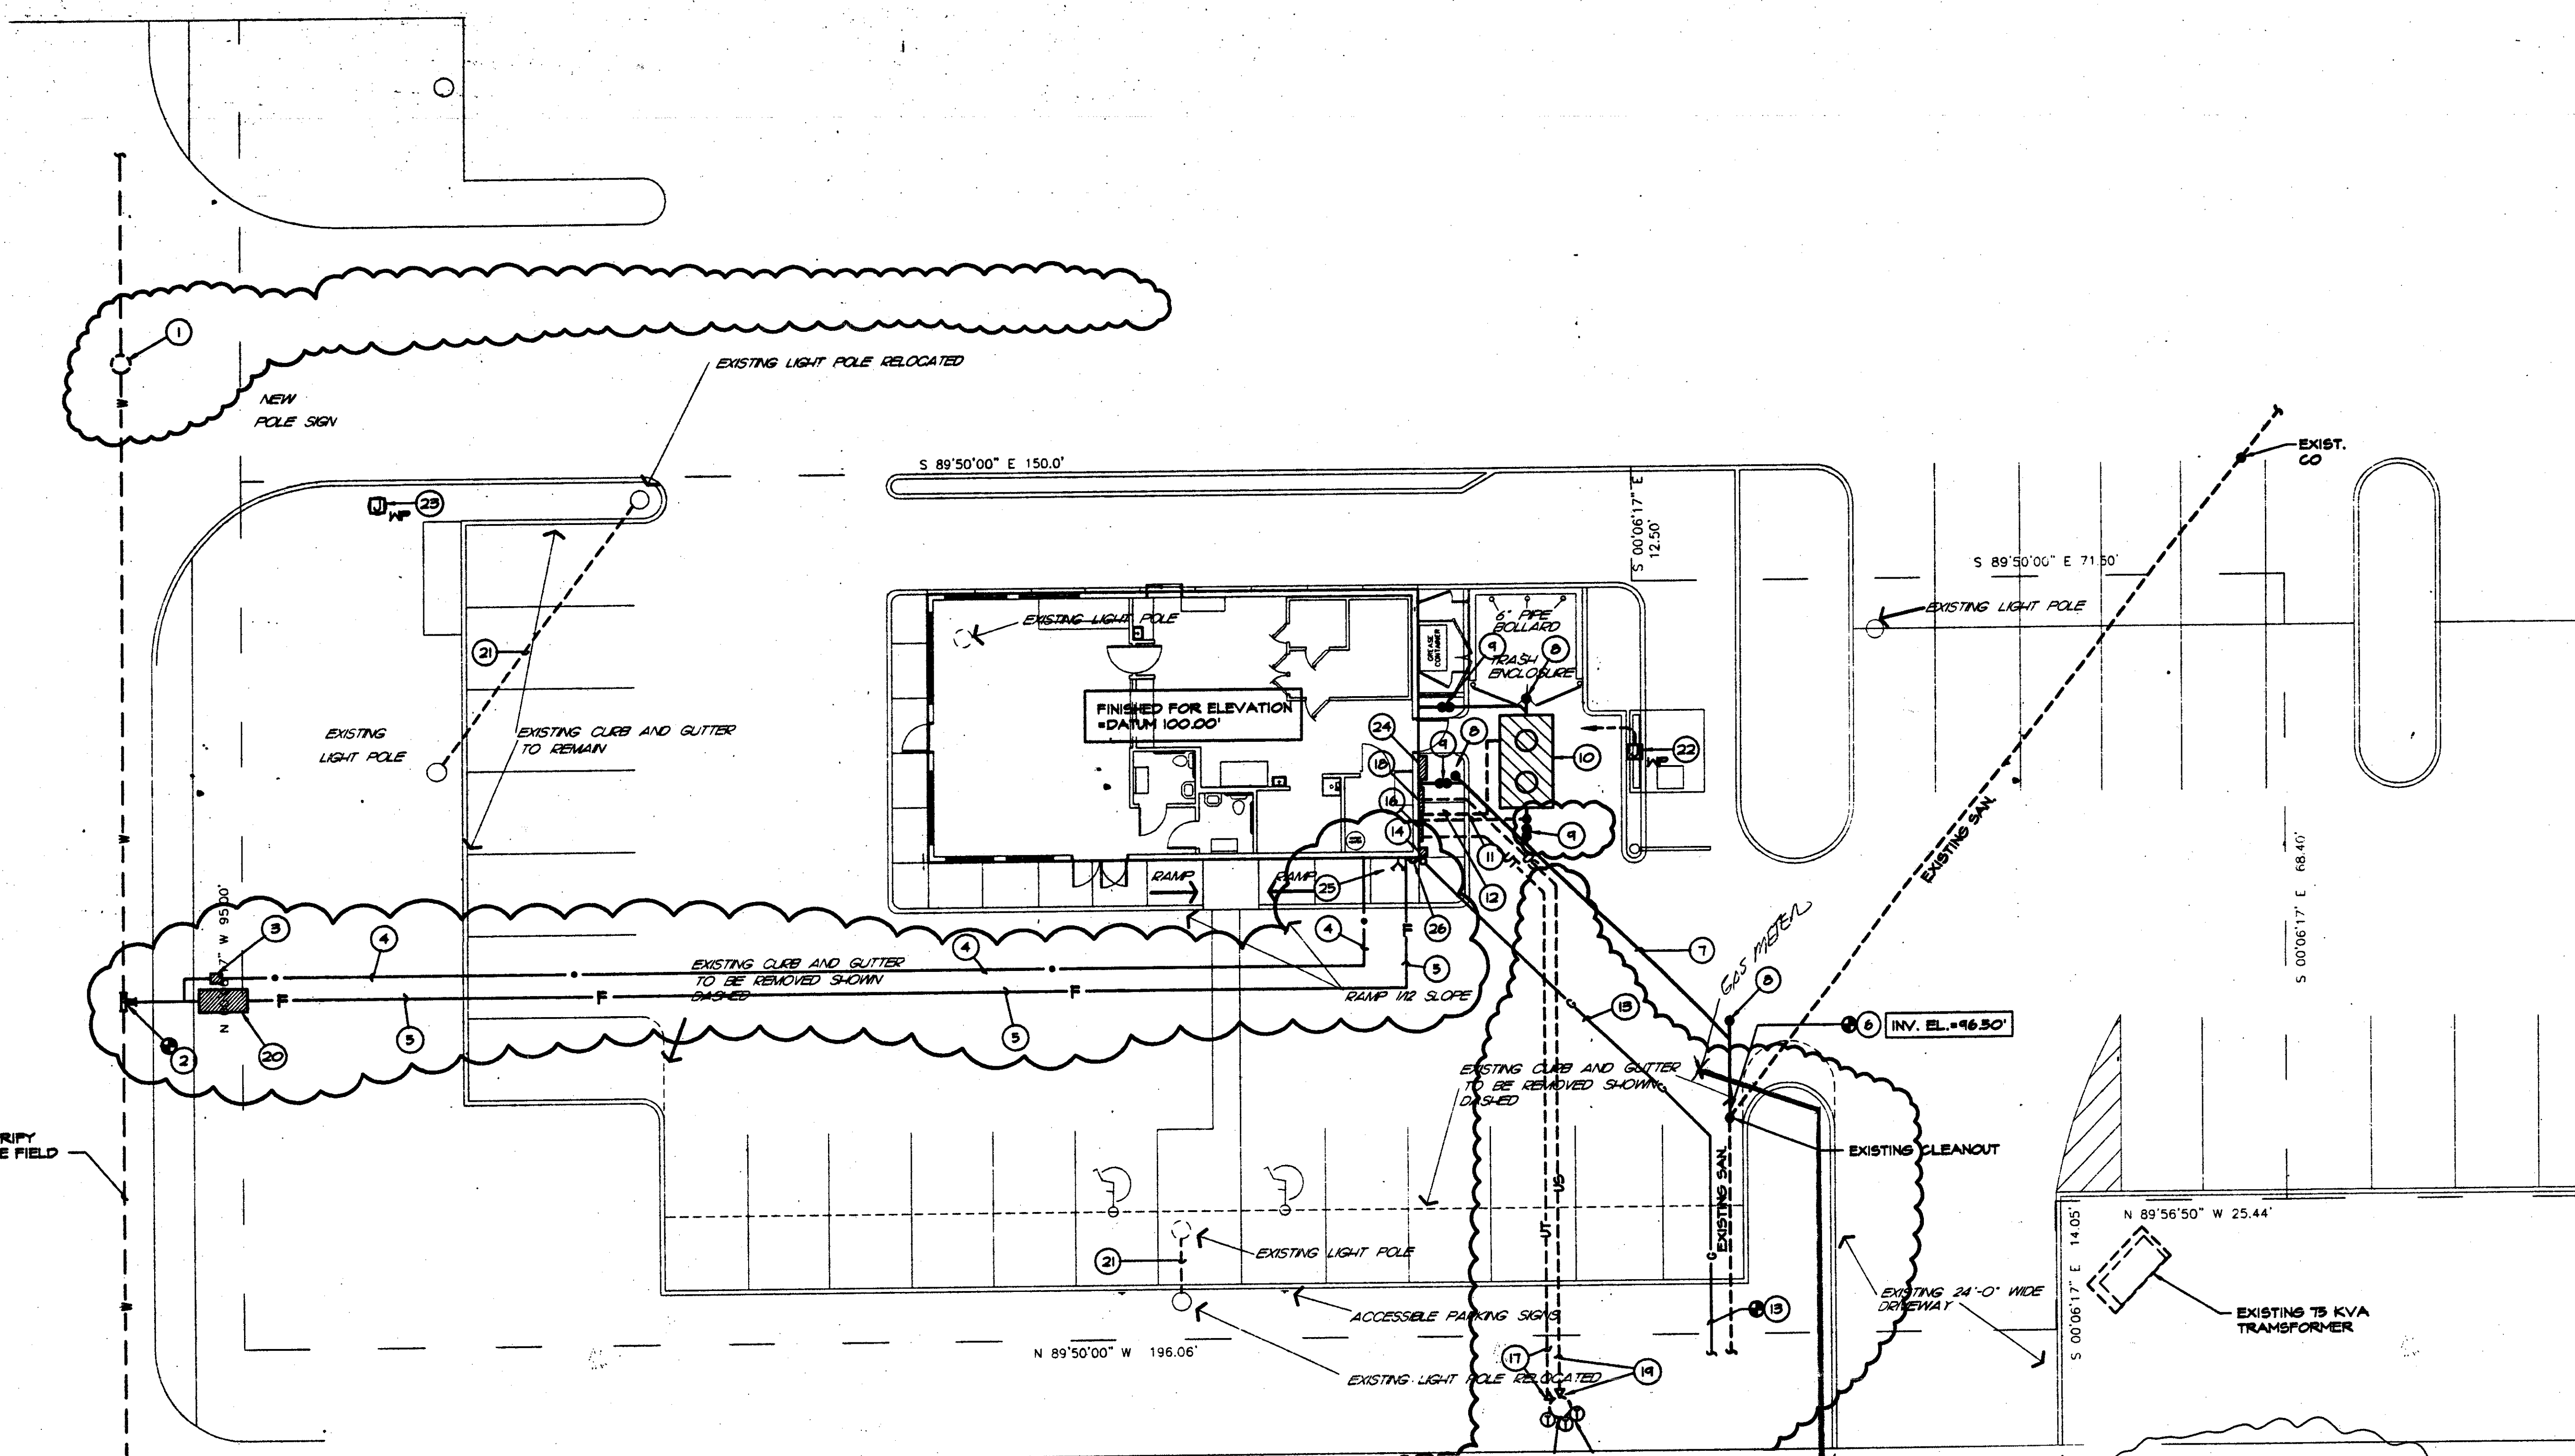

01 SITE PLAN
SCALE: 1"=20'-0"

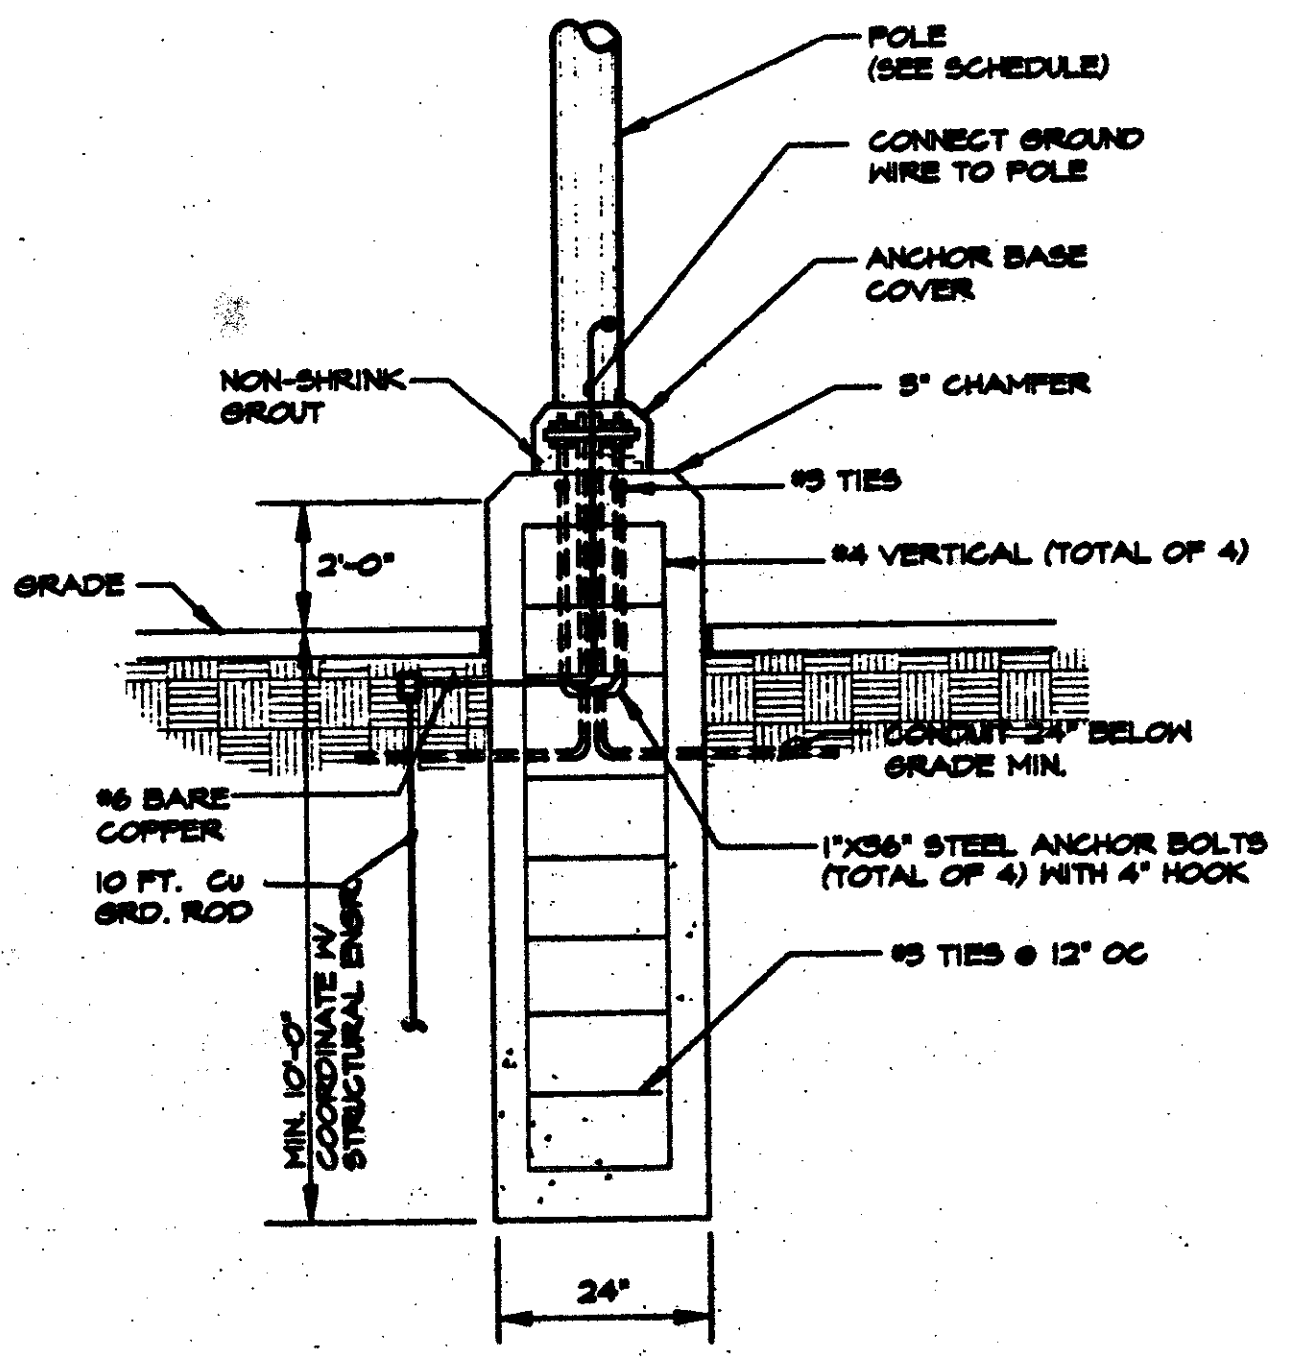

02 POLE BASE DETAIL
NO SCALE

GAS LOAD SUMMARY	
DESCRIPTION	CFH
RTU'S (HEATING)	270
KITCHEN (COOKING)	179
WATER HEATING	70
TOTAL BUILDING GAS DEMAND	519

PROPOSED 1/2" GAS SERVICE

EXISTING 1/2" GAS MAIN

1 1/2" GAS SERVICE TO BE INSTALLED 18" DEEP.



UTILITY CONTACTS:

TELEPHONE:


EAGE
IES (ELECTRIC)
SERVICE CENTER
LLE AVE.
75206
- 6652
- 6673

MS. JERI SHELBY
SOUTHWESTERN BELL
1255 TAVAROS AVE.
DALLAS, TX. 75218
T. (214) 320 - 6440
F. (214) 324 - 7898

CTRIC:
DEBRAND
IES (GAS)
- 1929

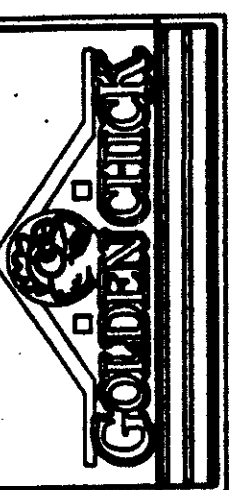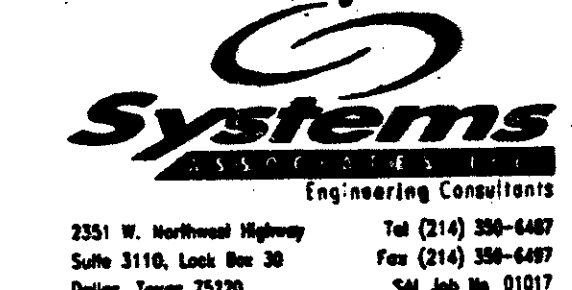

SMALL PROTOTYPE
ADDISON, TEXAS

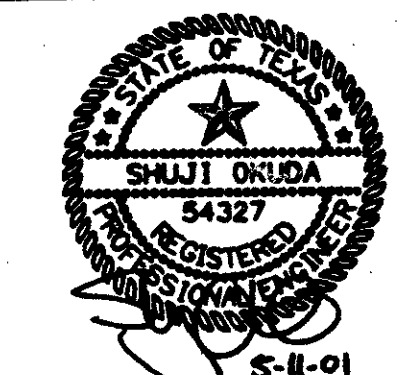

JOB NO. 0106

REVISIONS

NO.	DATE	DESCRIPTION
1	5-8-01	CITY COMMENTS

DATE 03-28-01
SHEET

MEP1

JOHN E WHEELER III
ARCHITECTS
5454 LA SIERRA DRIVE #203 DALLAS, TEXAS 75231
(214) 987-0160

