



MARSH LANE

(100.0' FOOT RIGHT-OF-WAY)

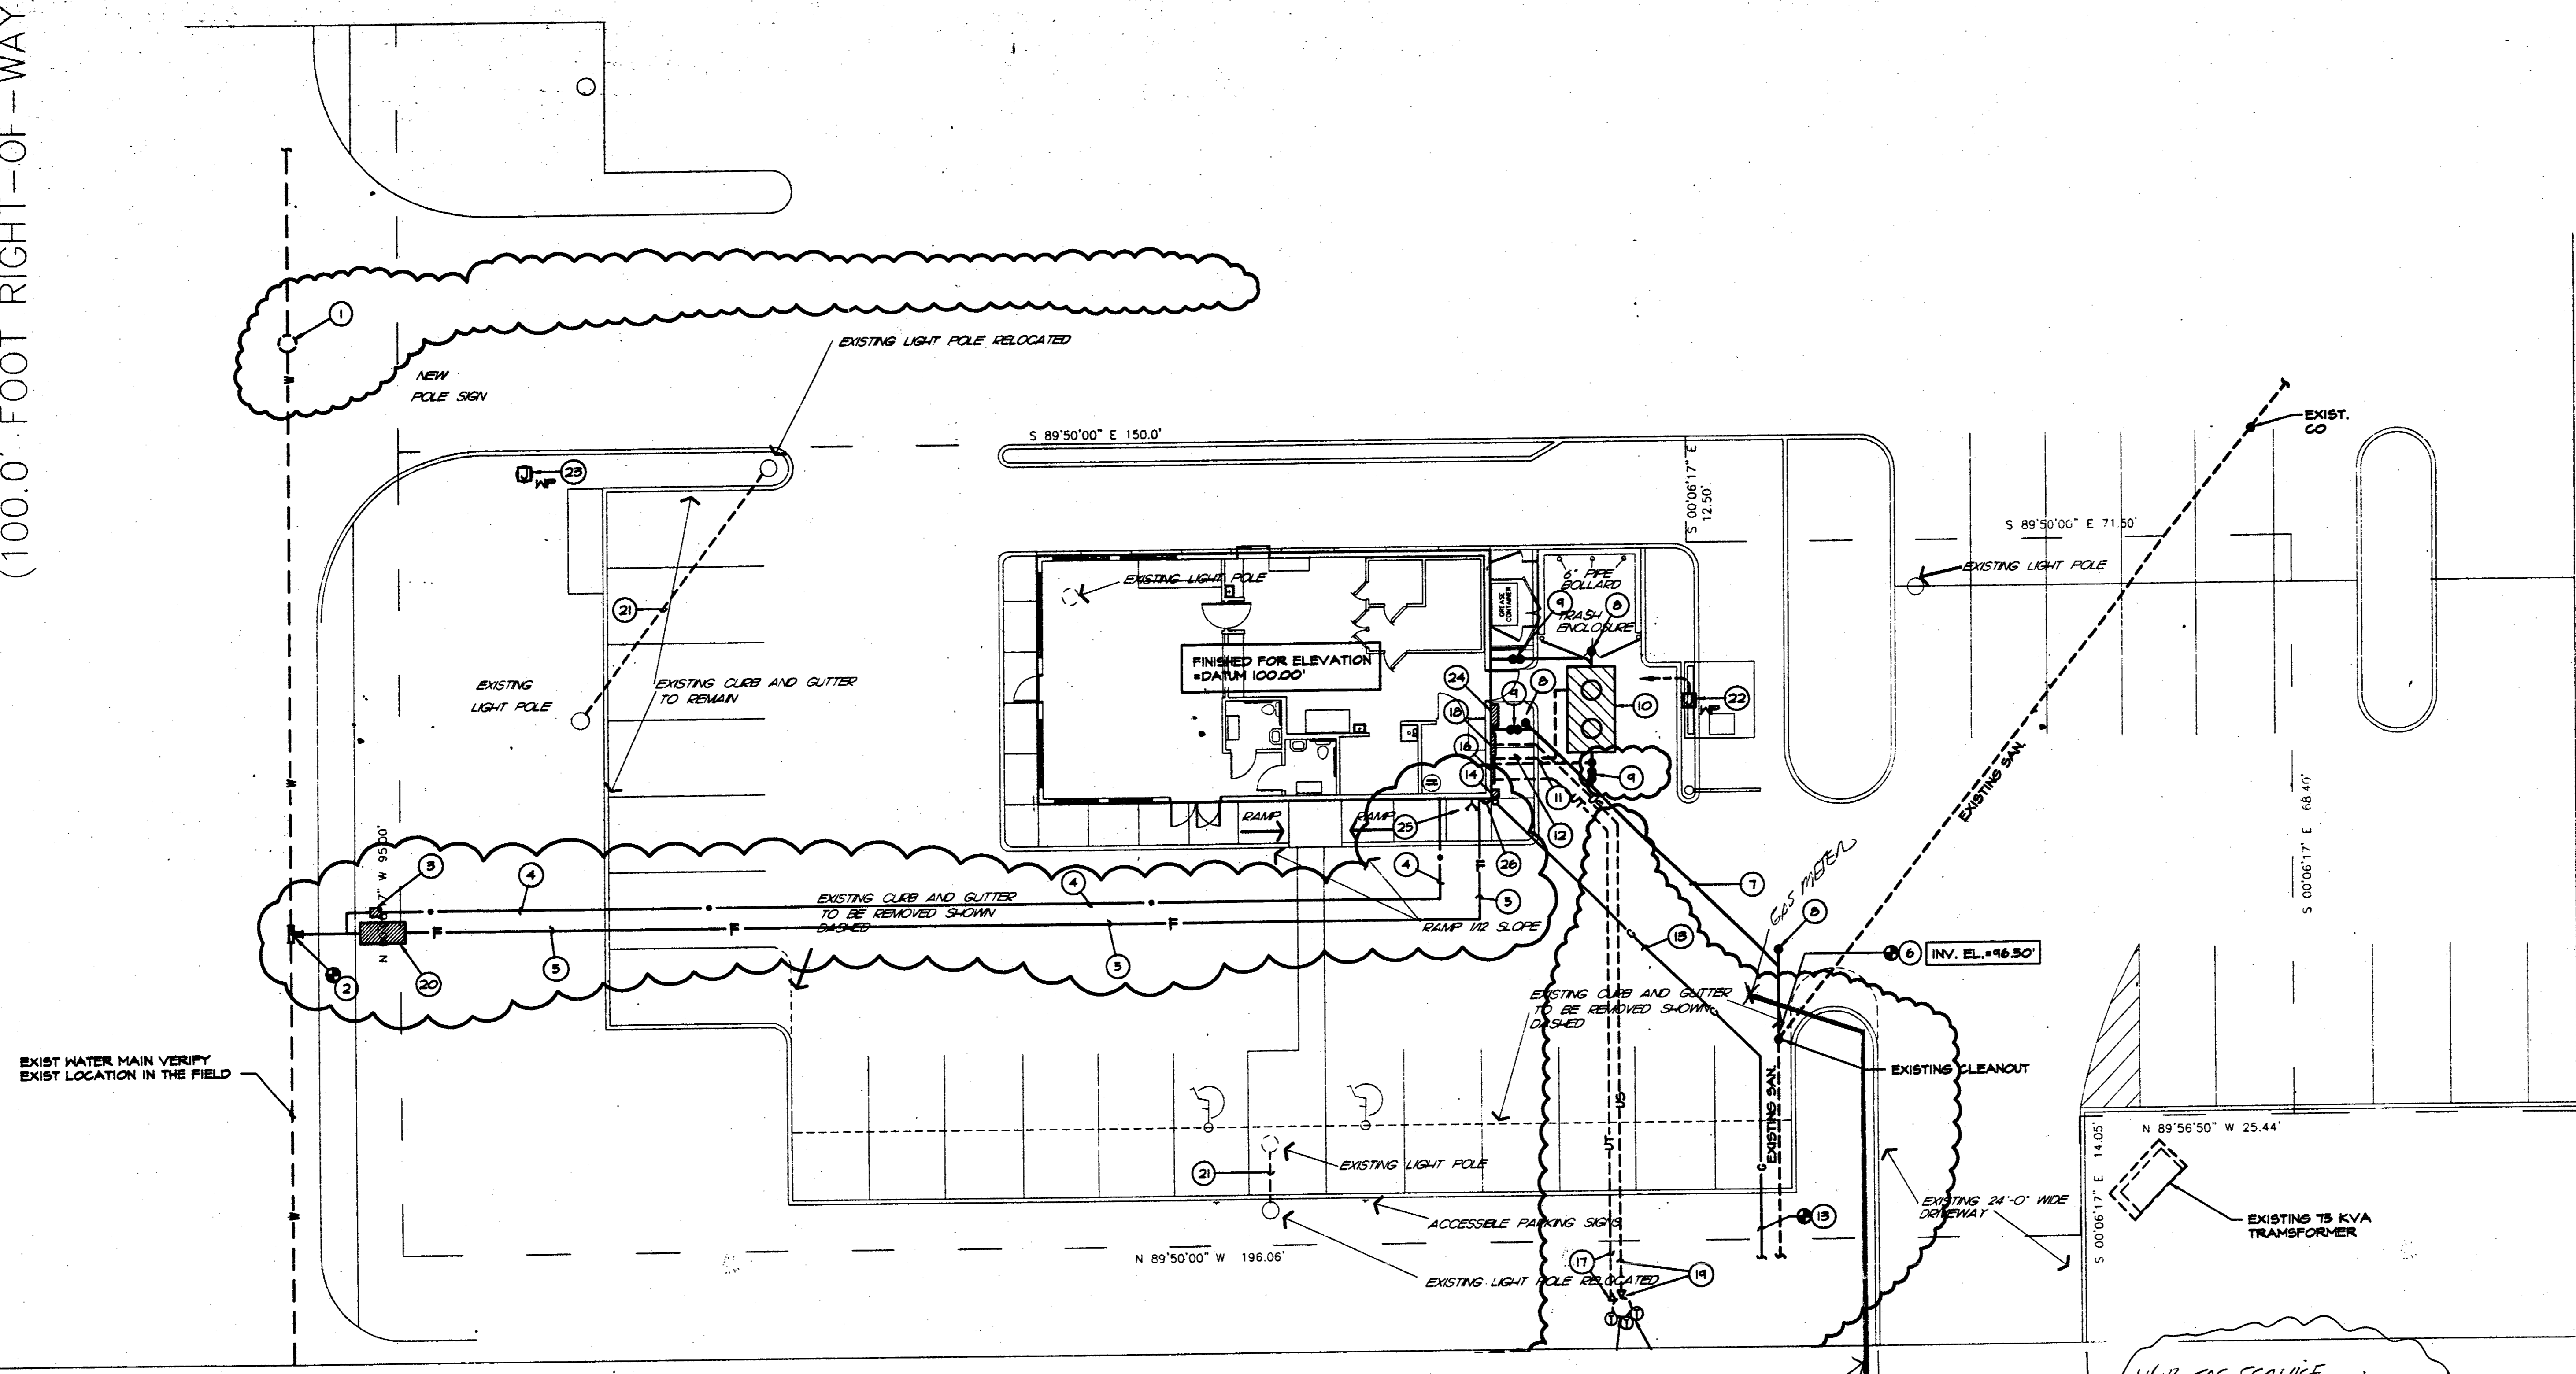

01 SITE PLAN
SCALE: 1"=20'-0"

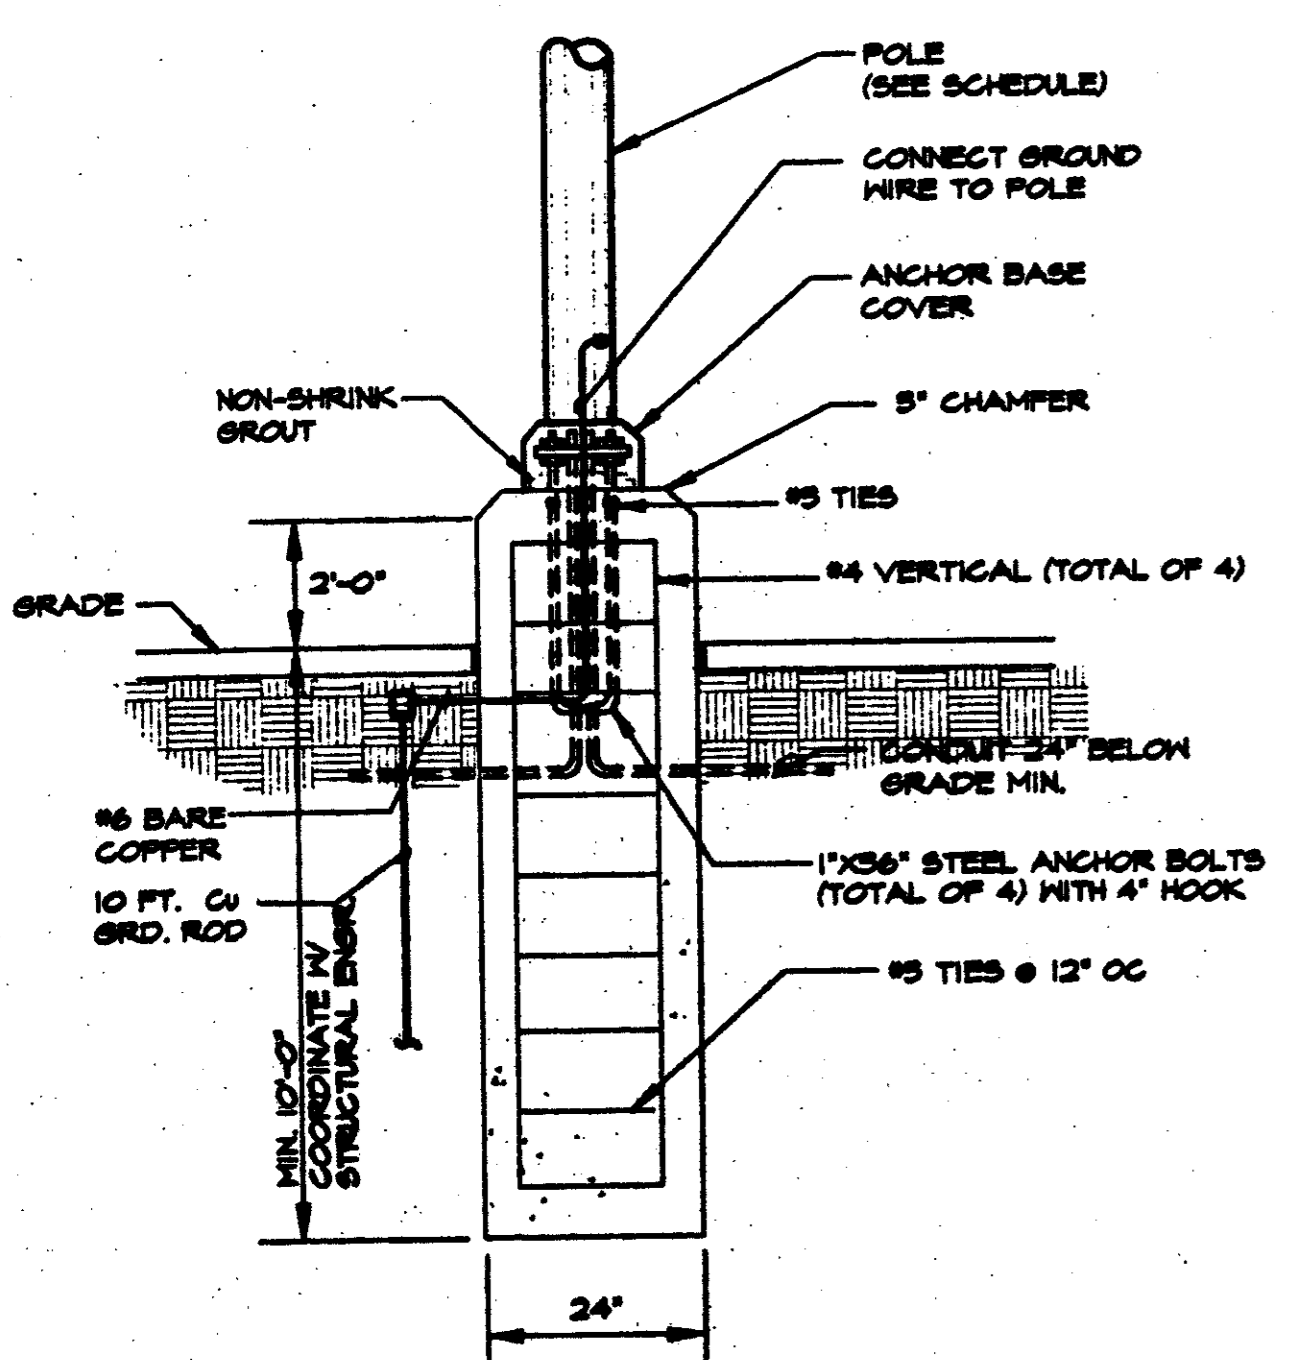

02 POLE BASE DETAIL
NO SCALE

GAS LOAD SUMMARY	
DESCRIPTION	CFH
RTU'S (HEATING)	270
KITCHEN (COOKING)	179
WATER HEATING	70
TOTAL BUILDING GAS DEMAND	519

PROVIDED 1/4" GAS SERVICE

EXISTING 1/4" GAS MAIN

1/4" GAS SERVICE TO BE INSTALLED 18" DEEP.


CITY CONTACTS:

SACE
IES (ELECTRIC)
SERVICE CENTER
LLE AVE.
75206
- 6652
- 6675


TELEPHONE:
MS. JERI SHELBY
SOUTHWESTERN BELL
1255 TAVAROS AVE
DALLAS, TX. 75210
T. (214) 820 - 6440
F. (214) 324 - 7898

CTRIC:
DEBRAND
IES (GAS)
- 1529

JOHN E WHEELER III
ARCHITECTS
5454 LA SIERRA DRIVE, #203 DALLAS, TEXAS 75231
(214) 987-0160

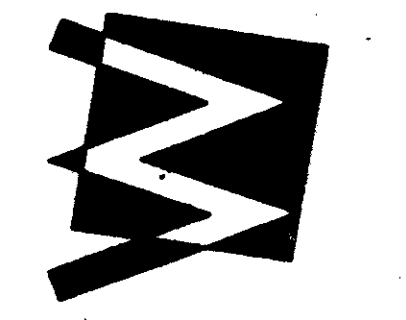

GOLDEN CHOICE
SMALL PROTOTYPE
ADDISON, TEXAS

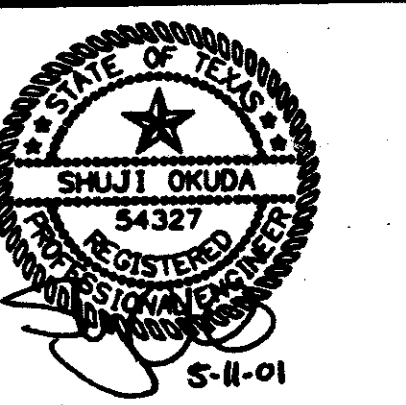

JOB NO. 0106

REVISIONS

NO.	DATE	DESCRIPTION
1	5-8-01	CITY COMMENTS

DATE 03-28-01
SHEET

MEP1

