



MARSH LANE


(100.0' FOOT RIGHT-OF-WAY)

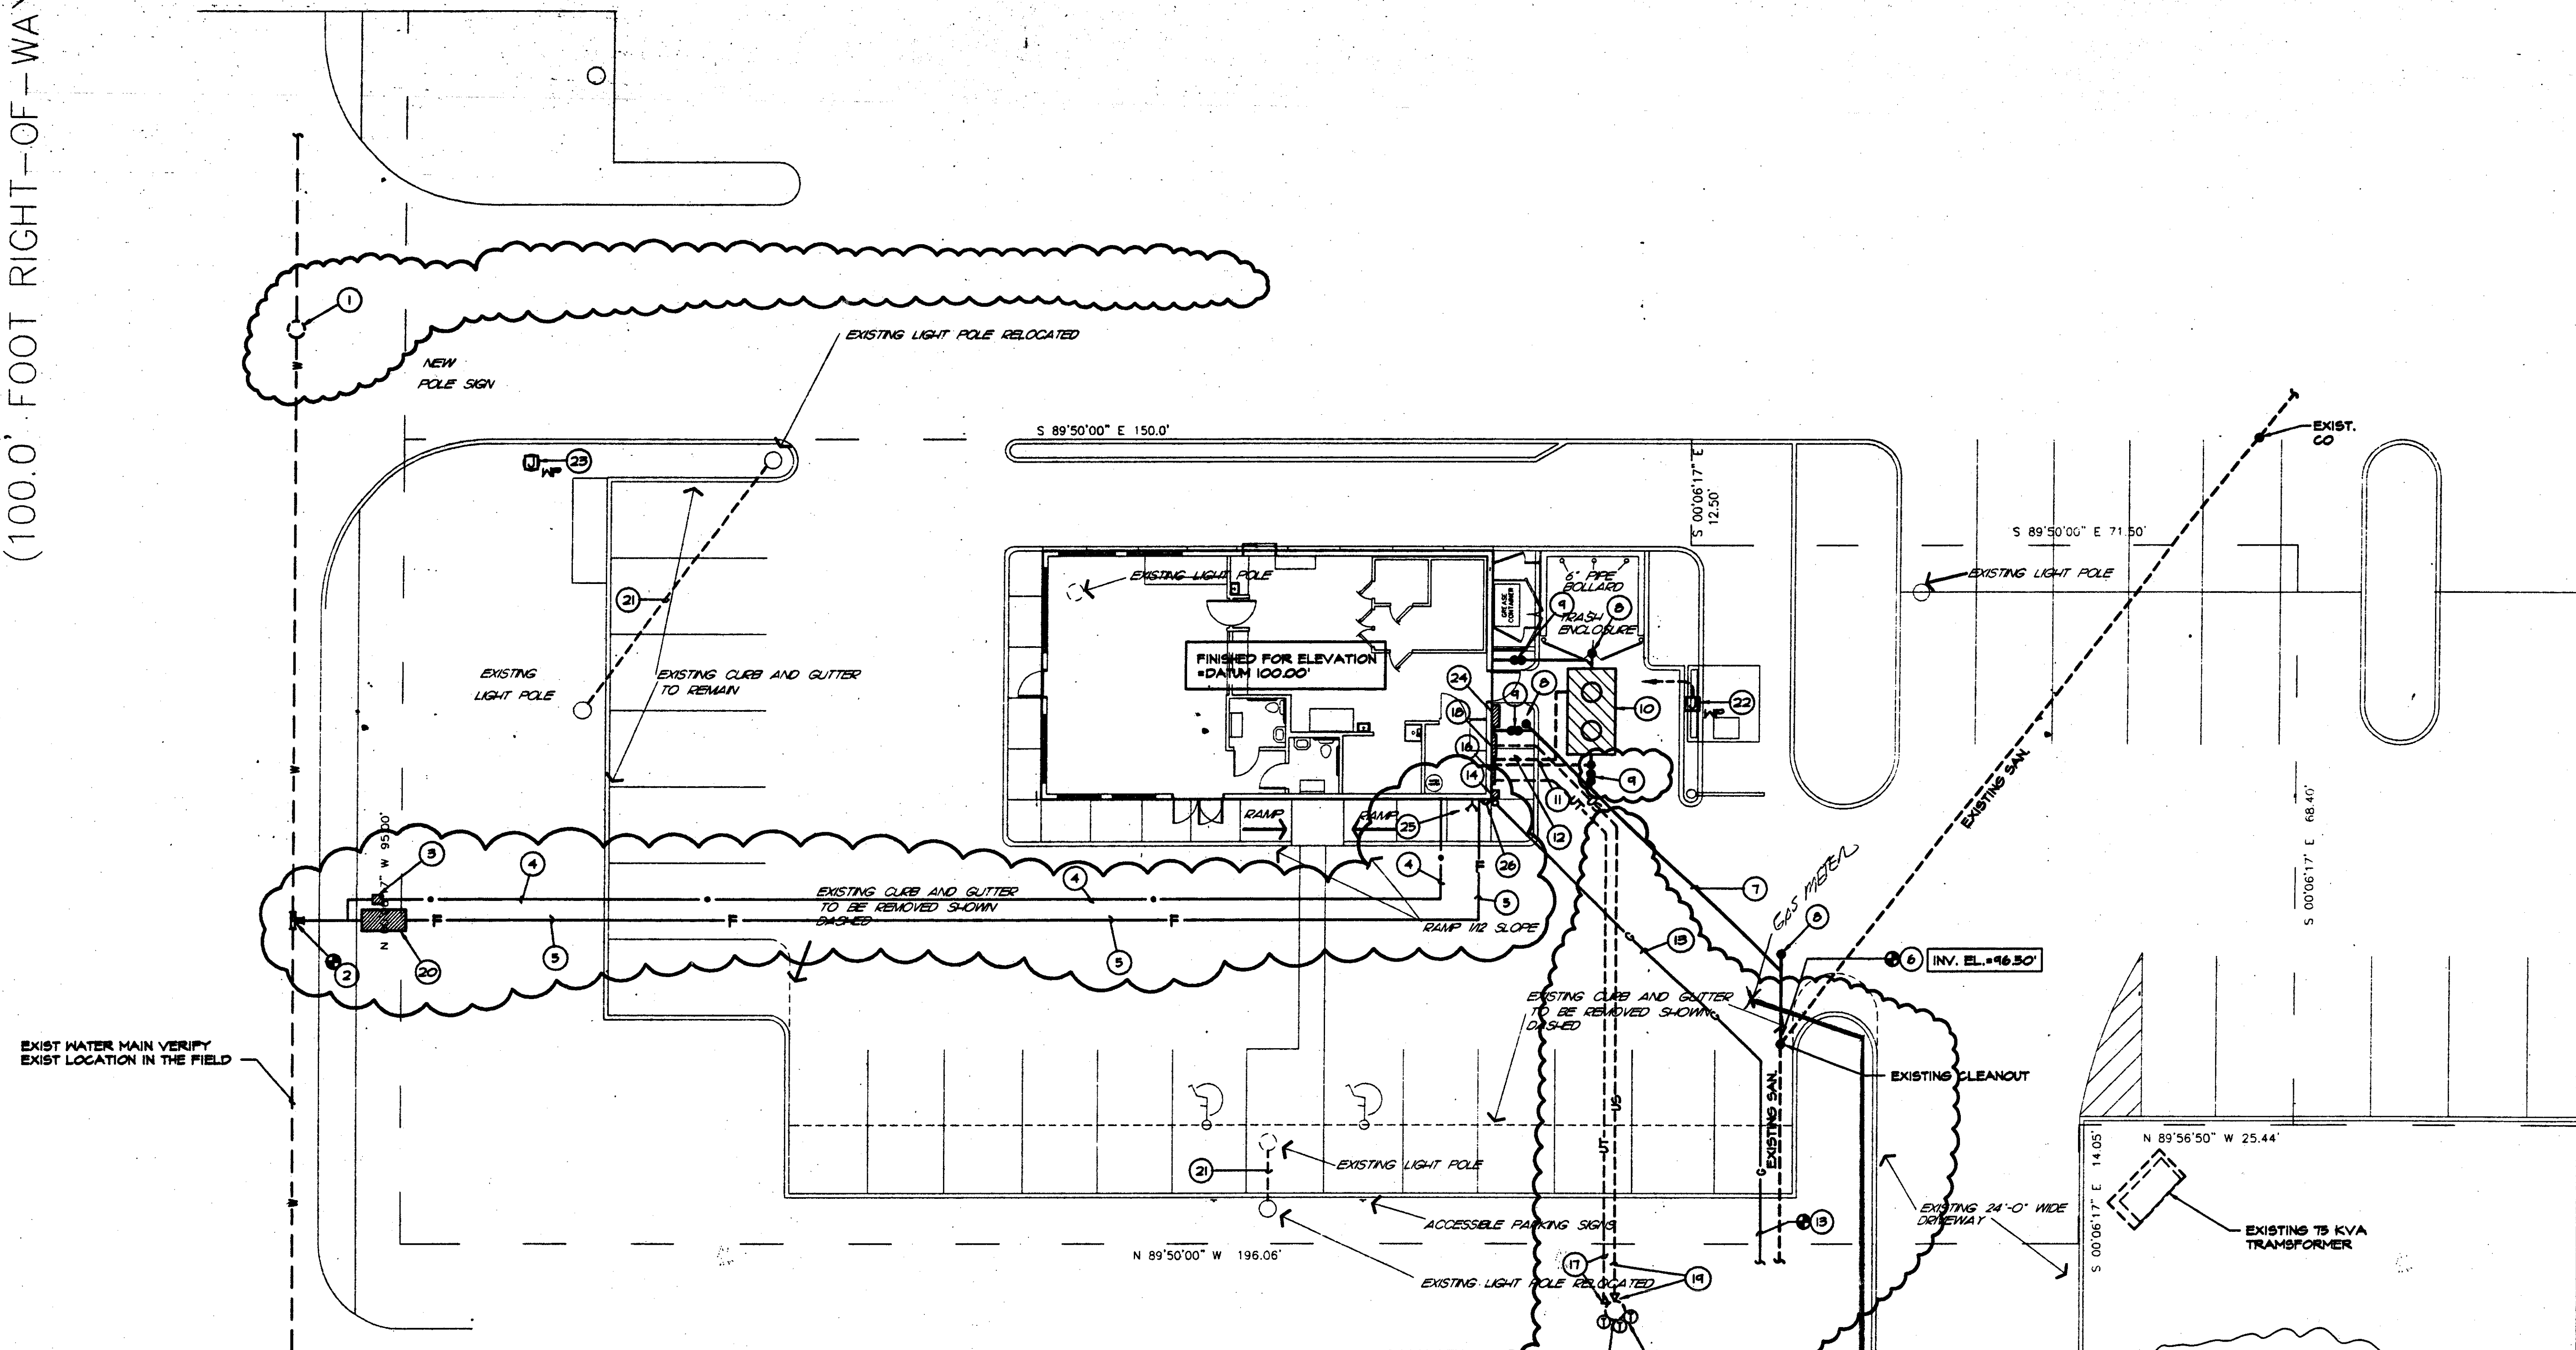

EXIST WATER MAIN VERIFY EXIST LOCATION IN THE FIELD

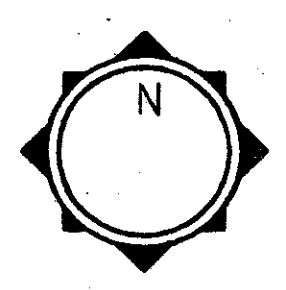

01 SITE PLAN
SCALE: 1"=20'-0"

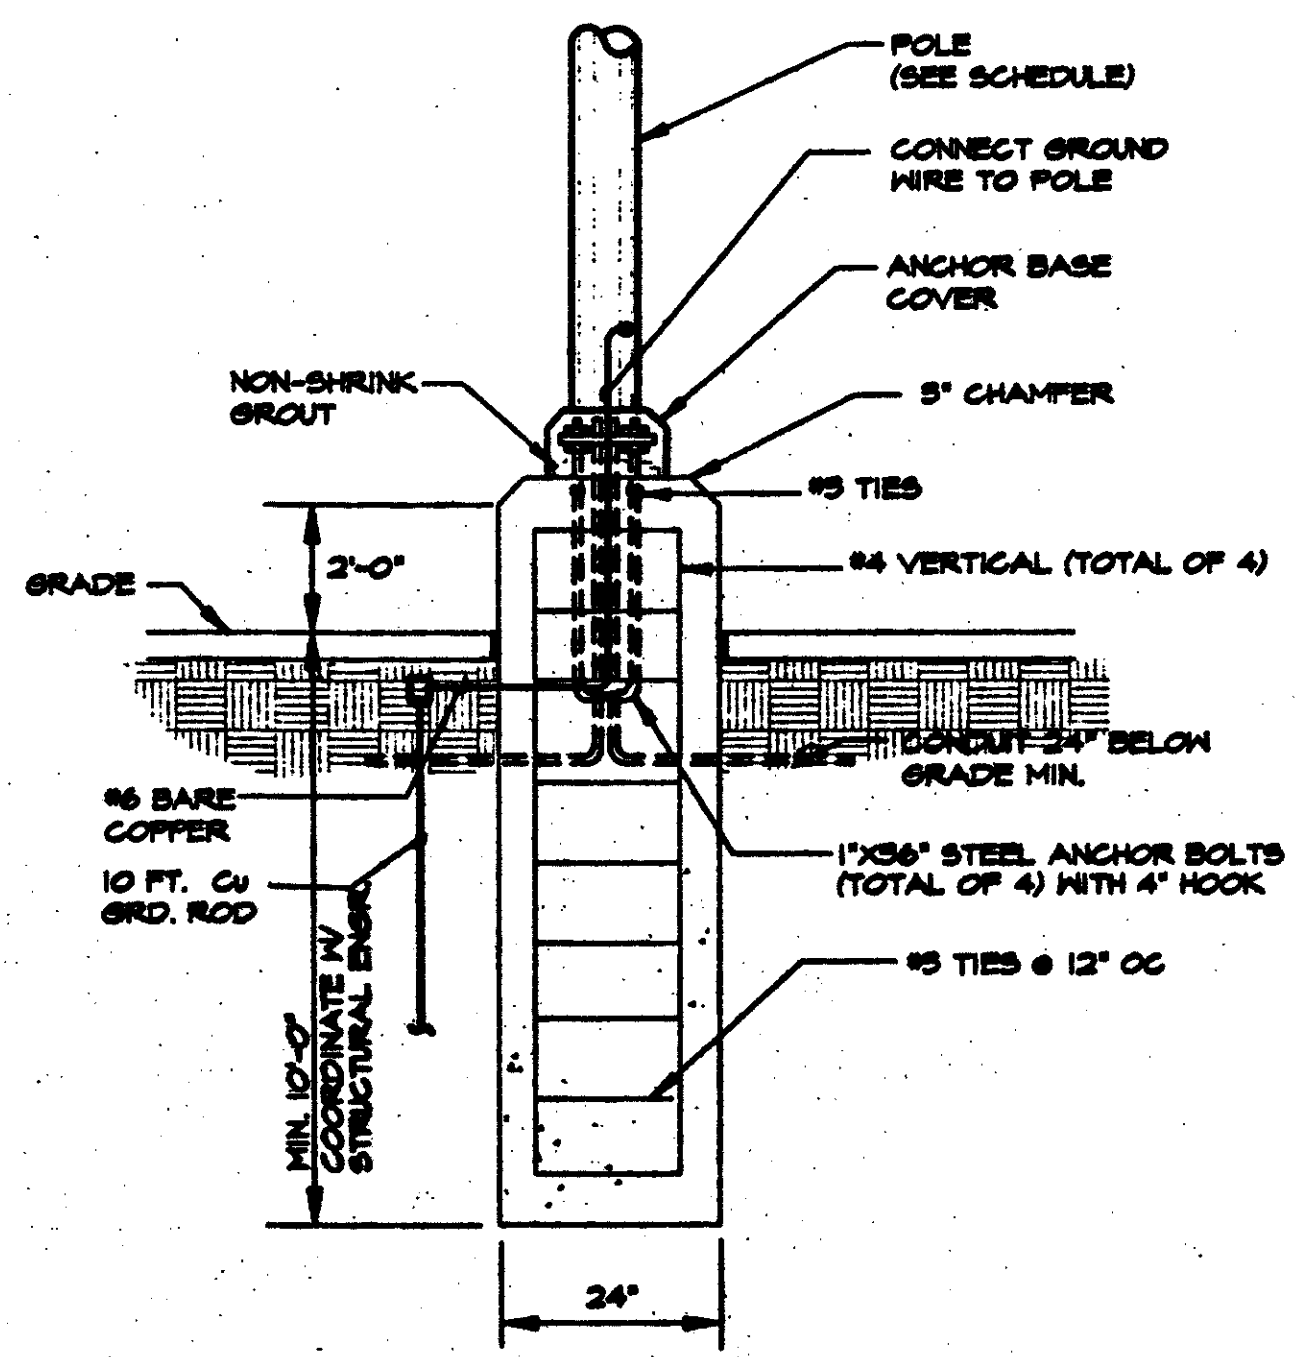

02 POLE BASE DETAIL
NO SCALE

GAS LOAD SUMMARY	
DESCRIPTION	CFH
RTU'S (HEATING)	270
KITCHEN (COOKING)	179
WATER HEATING	70
TOTAL BUILDING GAS DEMAND	519

PROPOSED 1/2" GAS SERVICE

EXISTING 1/4" GAS MAIN

1/4" GAS SERVICE TO BE INSTALLED 18" DEEP.


SPRING VALLEY

CITY CONTACTS:

EACE	TELEPHONE:
IES (ELECTRIC)	MS. JERI SHELBY
SERVICE CENTER	SOUTHWESTERN BELL
11E AVE.	1255 TAVAROS AVE.
75206	DALLAS, TX. 75218
- 6652	T. (214) 320 - 6440
- 6678	F. (214) 324 - 7898

CTRIC:

DEBRAND
IES (GAS)
- 1329

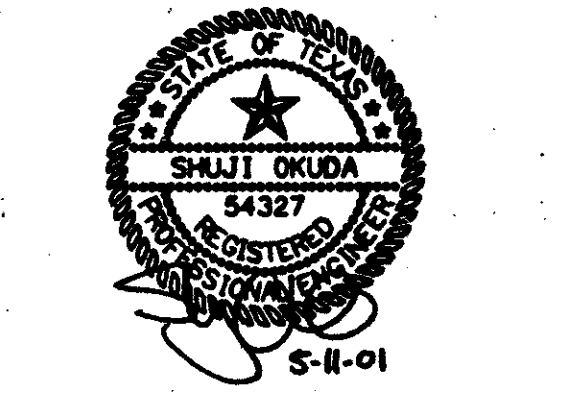

JOB NO. 0106

REVISIONS

NO.	DATE	DESCRIPTION
1	5-8-01	CITY COMMENTS

DATE 03-28-01
SHEET