


GENERAL NOTES


- ① VERIFY LOCATION OF TU ELECTRIC PRIMARY DIP POLE PRIOR TO INSTALLATION OF UNDERGROUND PRIMARY DUCT BANK. TWO 4" C (ONE ACTIVE, ONE SPARE). TU REPRESENTATIVE - JOEL PORTER (214) 888-1313
- ② VERIFY LOCATION OF SW BELL TELEPHONE PEDESTAL PRIOR TO INSTALLATION OF 2" C. FOR UNDERGROUND TELEPHONE.

A SITE PLAN - ELECTRICAL
 55 SCALE: 1"=20'

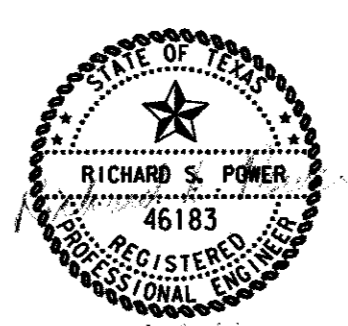

4			
3			
2			
1			
NO.	DATE	REVISION	APPROV.

TOWN OF ADDISON, TEXAS
 MIDWAY/BELTLINE SANITARY SEWER
 PHASE II
 LIFT STATION
 ELECTRICAL SITE PLAN

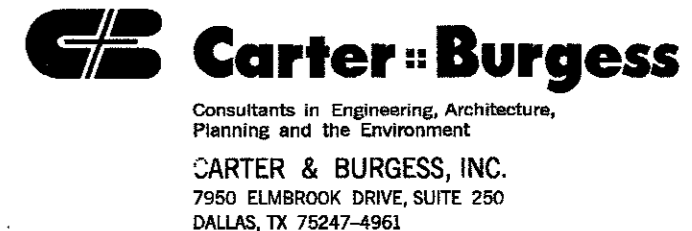

Unit	Scale	Hor. 1/2. 1"=20'	Date	04-05-96
Designed	R. J. [Signature]	Checked	J. L. [Signature]	Job No. 933276010
Drawn	J. WEBB	Approved	J. Lindner	Sheet 55 of 63

PROJECT NO. 933276010
 SHEET NO. 55 OF 63
 DATE: 04-05-96
 DRAWN BY: J. WEBB
 CHECKED BY: J. LINDNER
 APPROVED BY: RICHARD S. POWER
 REGISTERED PROFESSIONAL ENGINEER
 STATE OF TEXAS
 NO. 46183