



**A LOWER LEVEL LIGHTING/POWER**  
SCALE: 1/4" = 1' - 0"

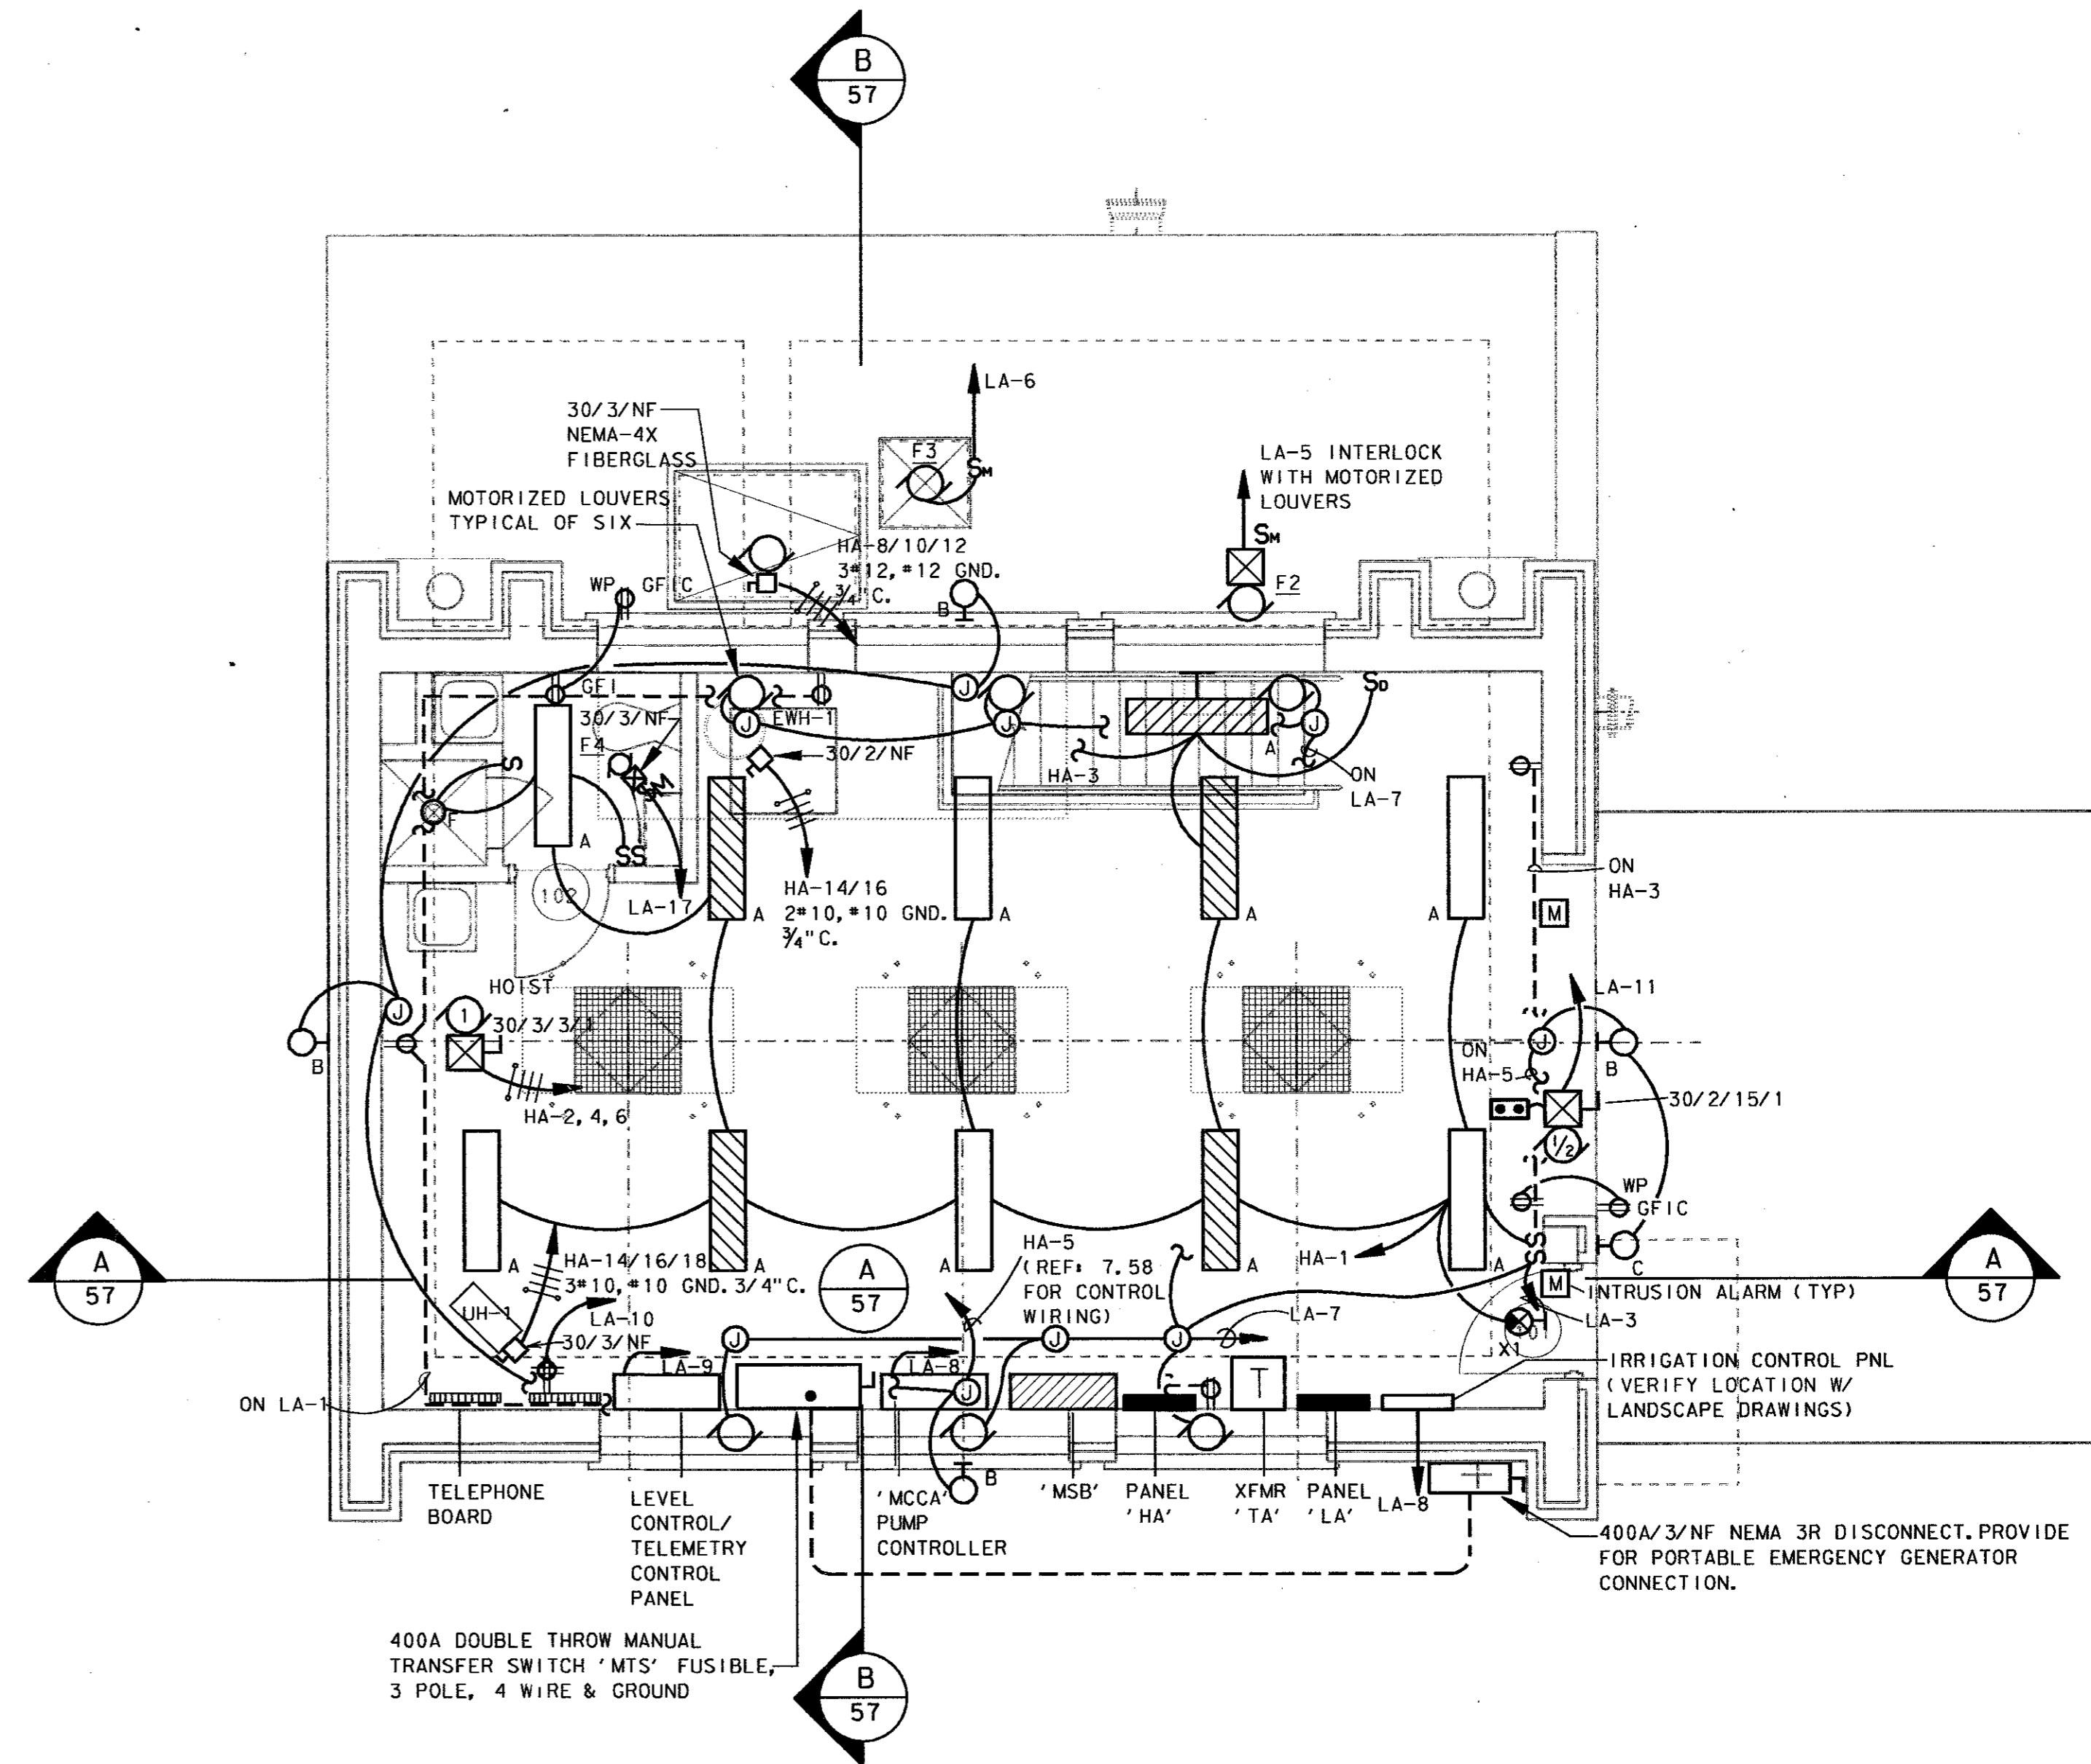

**B GROUND LEVEL LIGHTING/POWER**  
SCALE: 1/4" = 1' - 0"

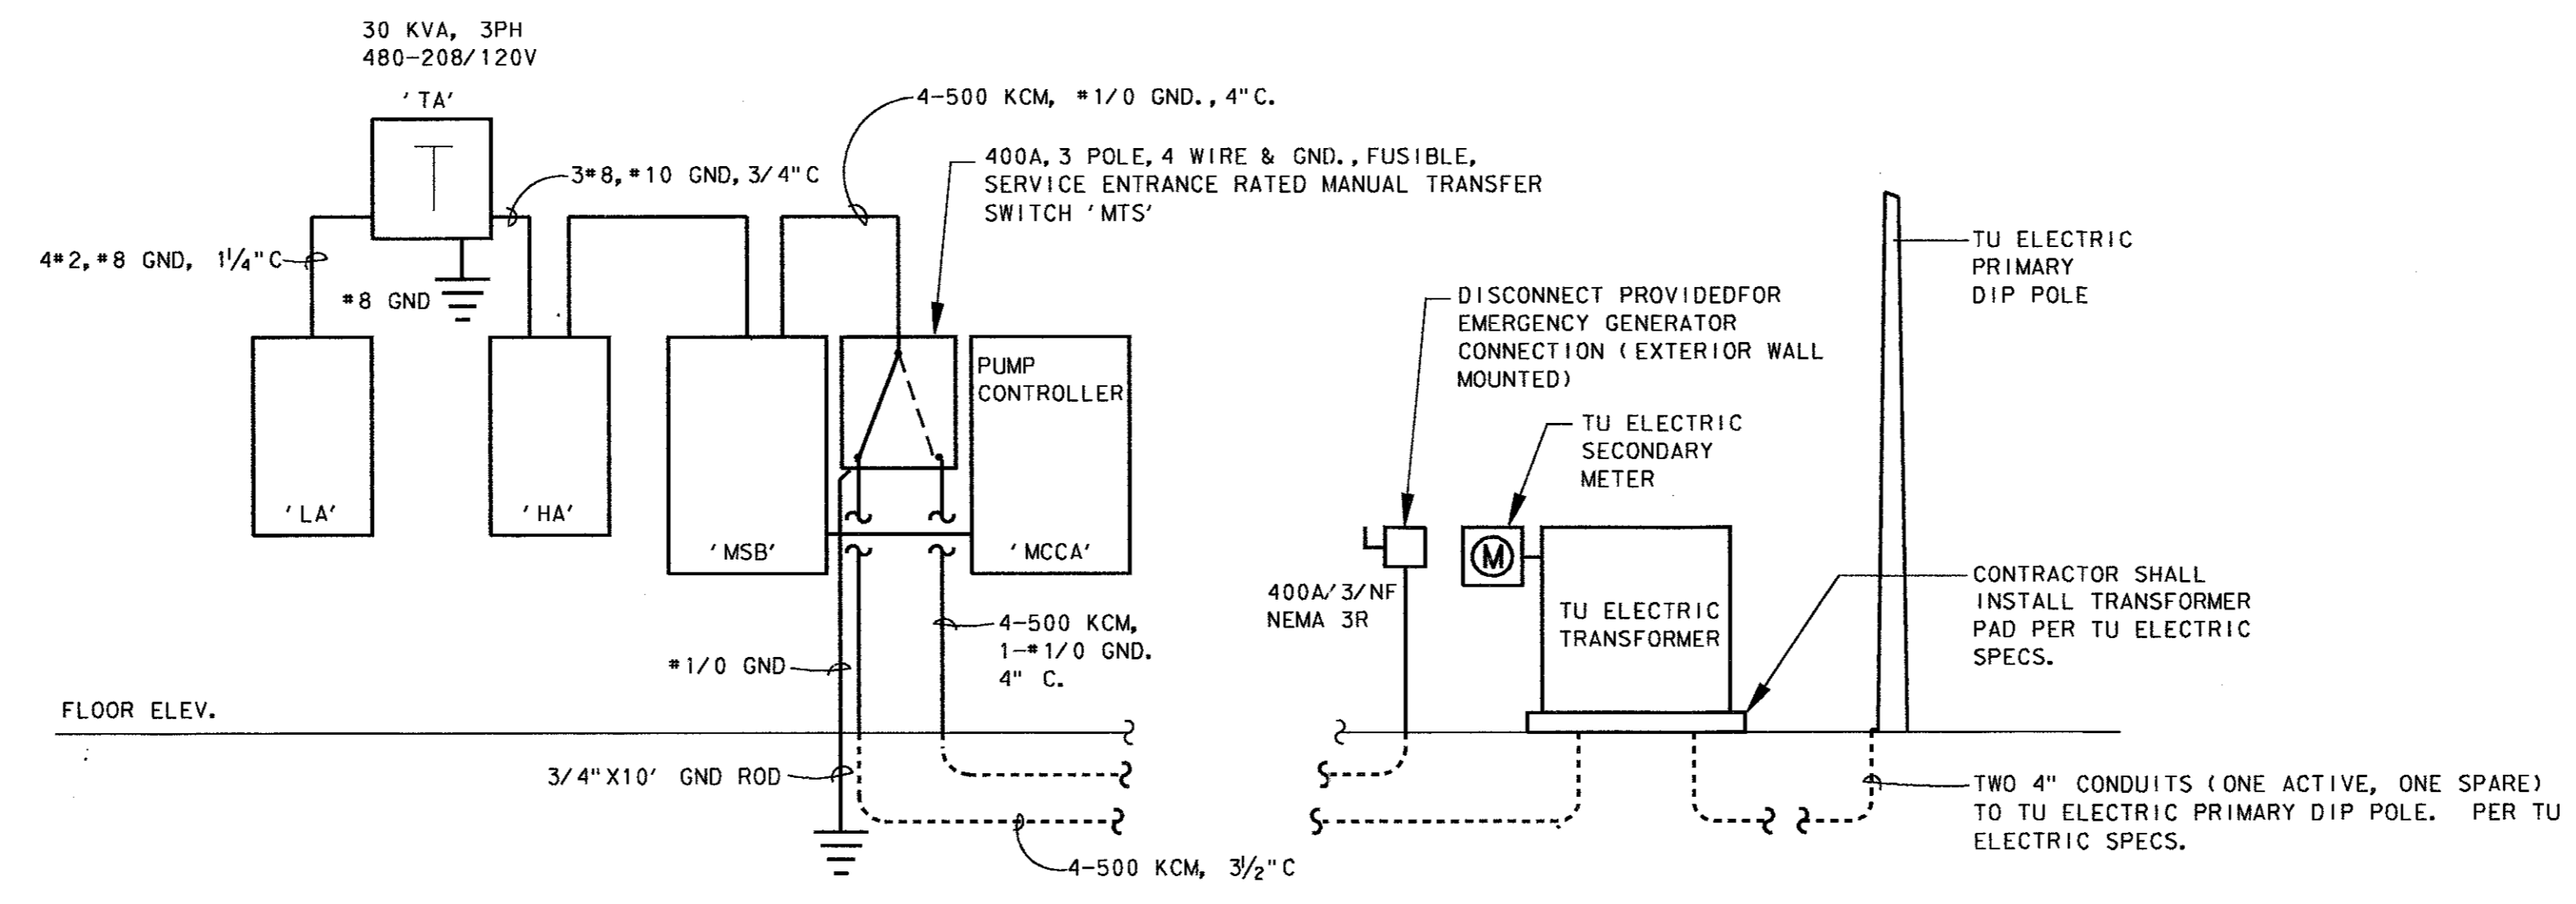

**C ELECTRICAL RISER DIAGRAM**  
SCALE: NO SCALE

4			
3			
2			
1			
NO.	DATE	REVISION	APPROV.
<b>TOWN OF ADDISON, TEXAS</b>			
<b>MIDWAY/BELTLINE SANITARY SEWER PHASE II</b>			
<b>LIFT STATION ELECTRICAL FLOOR PLAN</b>			
 Consultants in Engineering, Architecture, Planning and the Environment <b>CARTER &amp; BURGESS, INC.</b> 7950 ELMBROOK DRIVE, SUITE 250 DALLAS, TX 75247-4961			
Unit#	Scale	Date	04-05-96
Designed	R. P. M. / J. L.	Checked	R. P. M. / J. L.
Drawn	J. WEBB	Approved	J. Lindner
		Job No.	93327601D
		Sheet	56 of 63

