

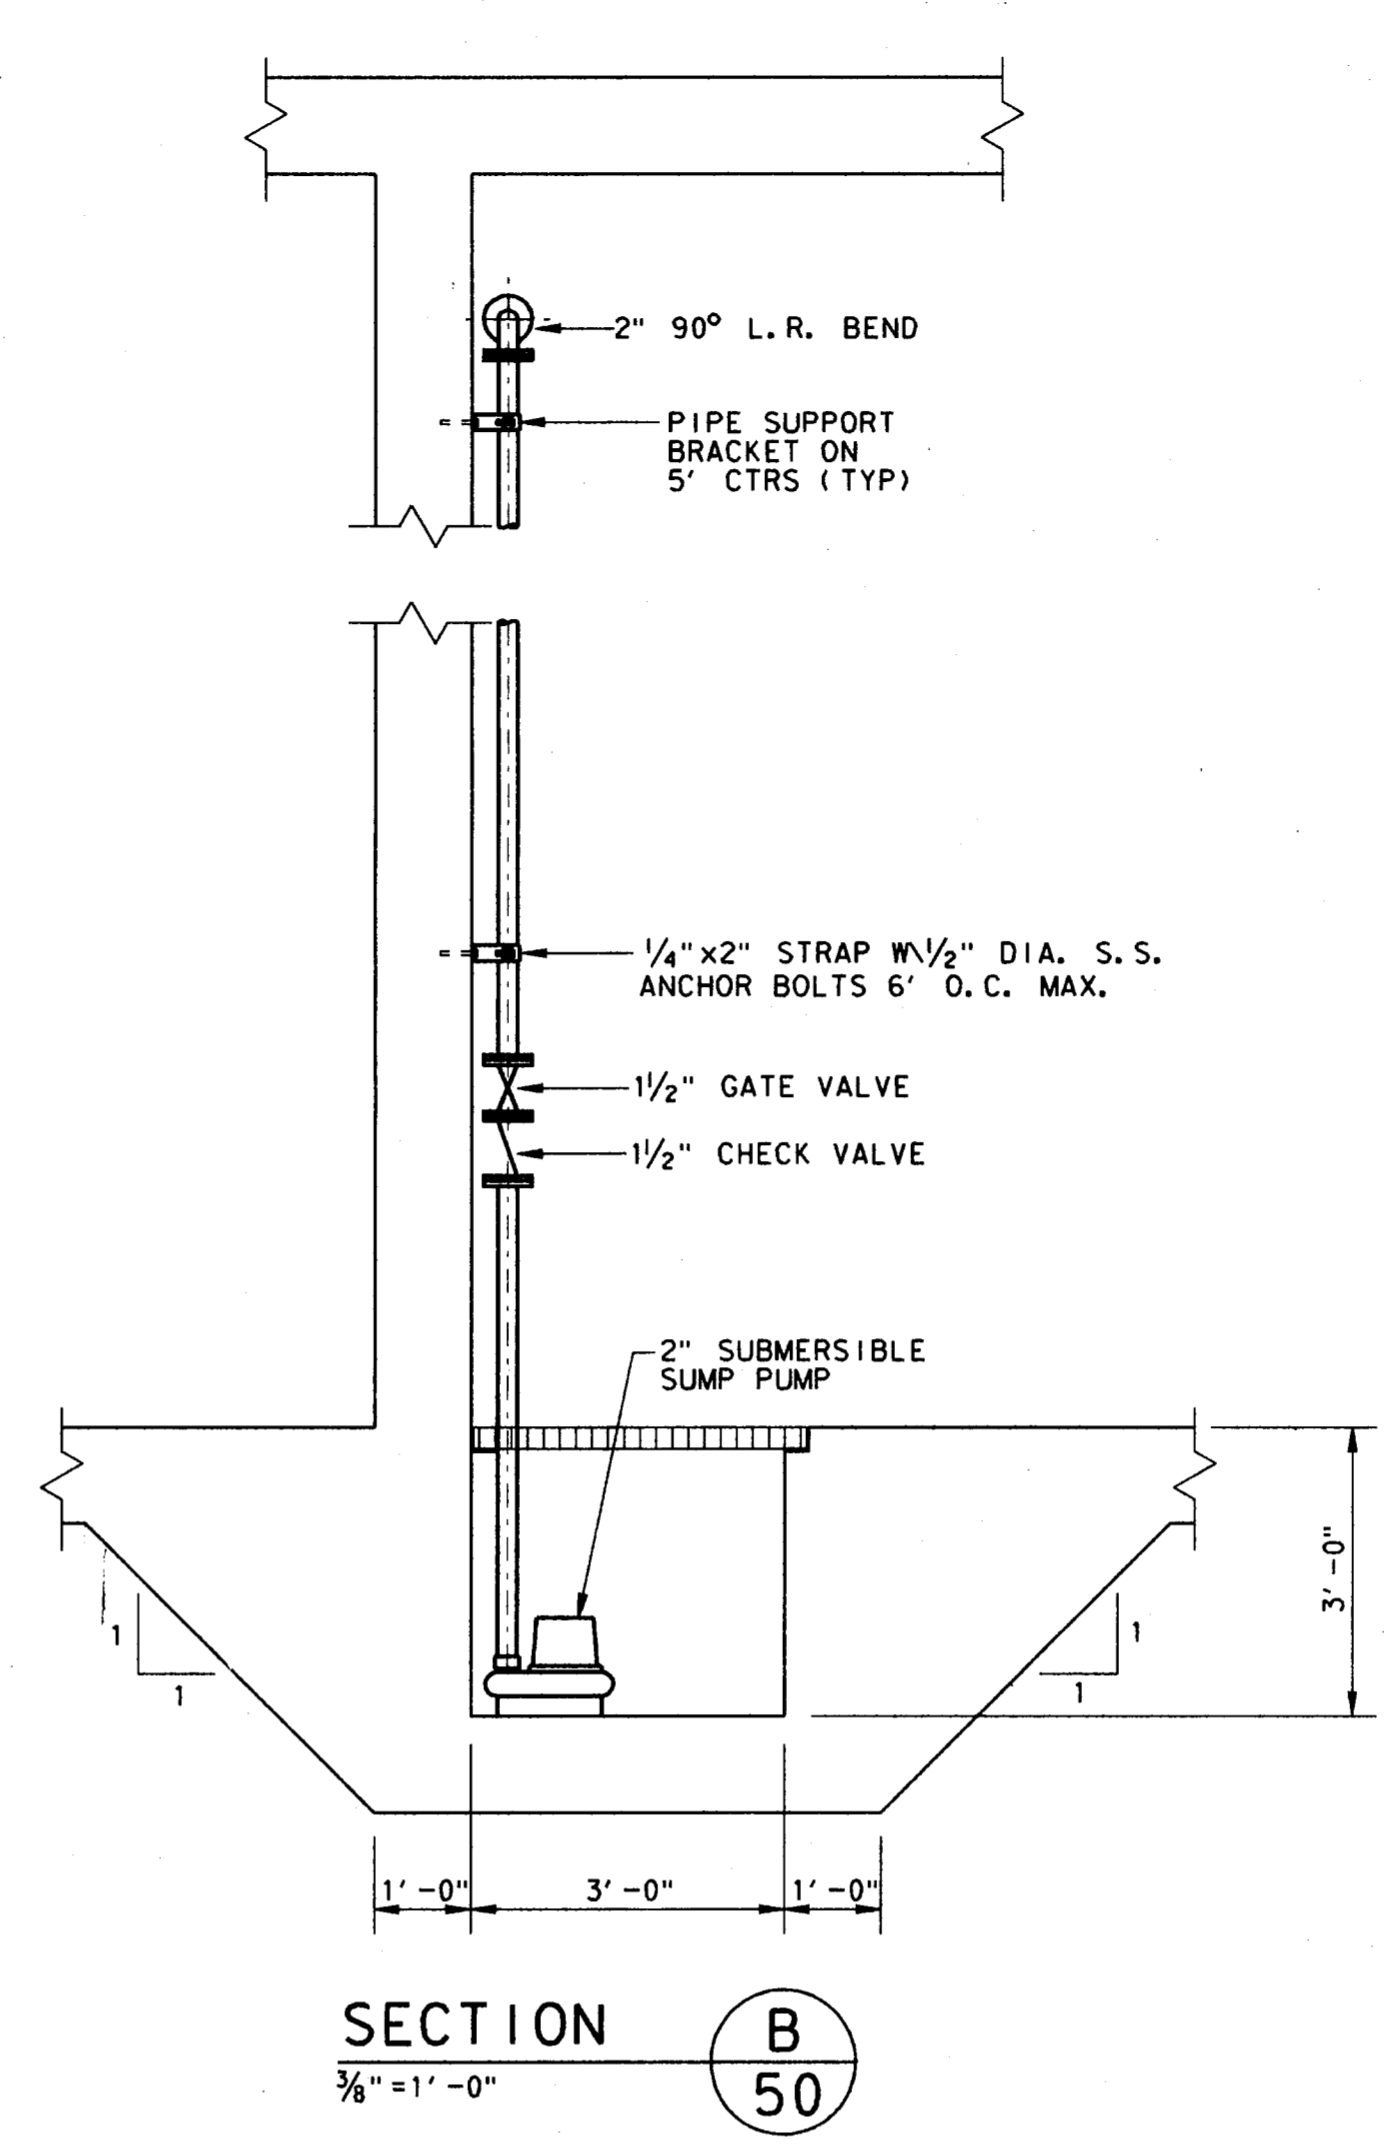


REVISIONS  
 NO. DATE BY  
 1 9-4-98 AS BUILT DRAWING J. H. L.  
 2  
 3  
 4

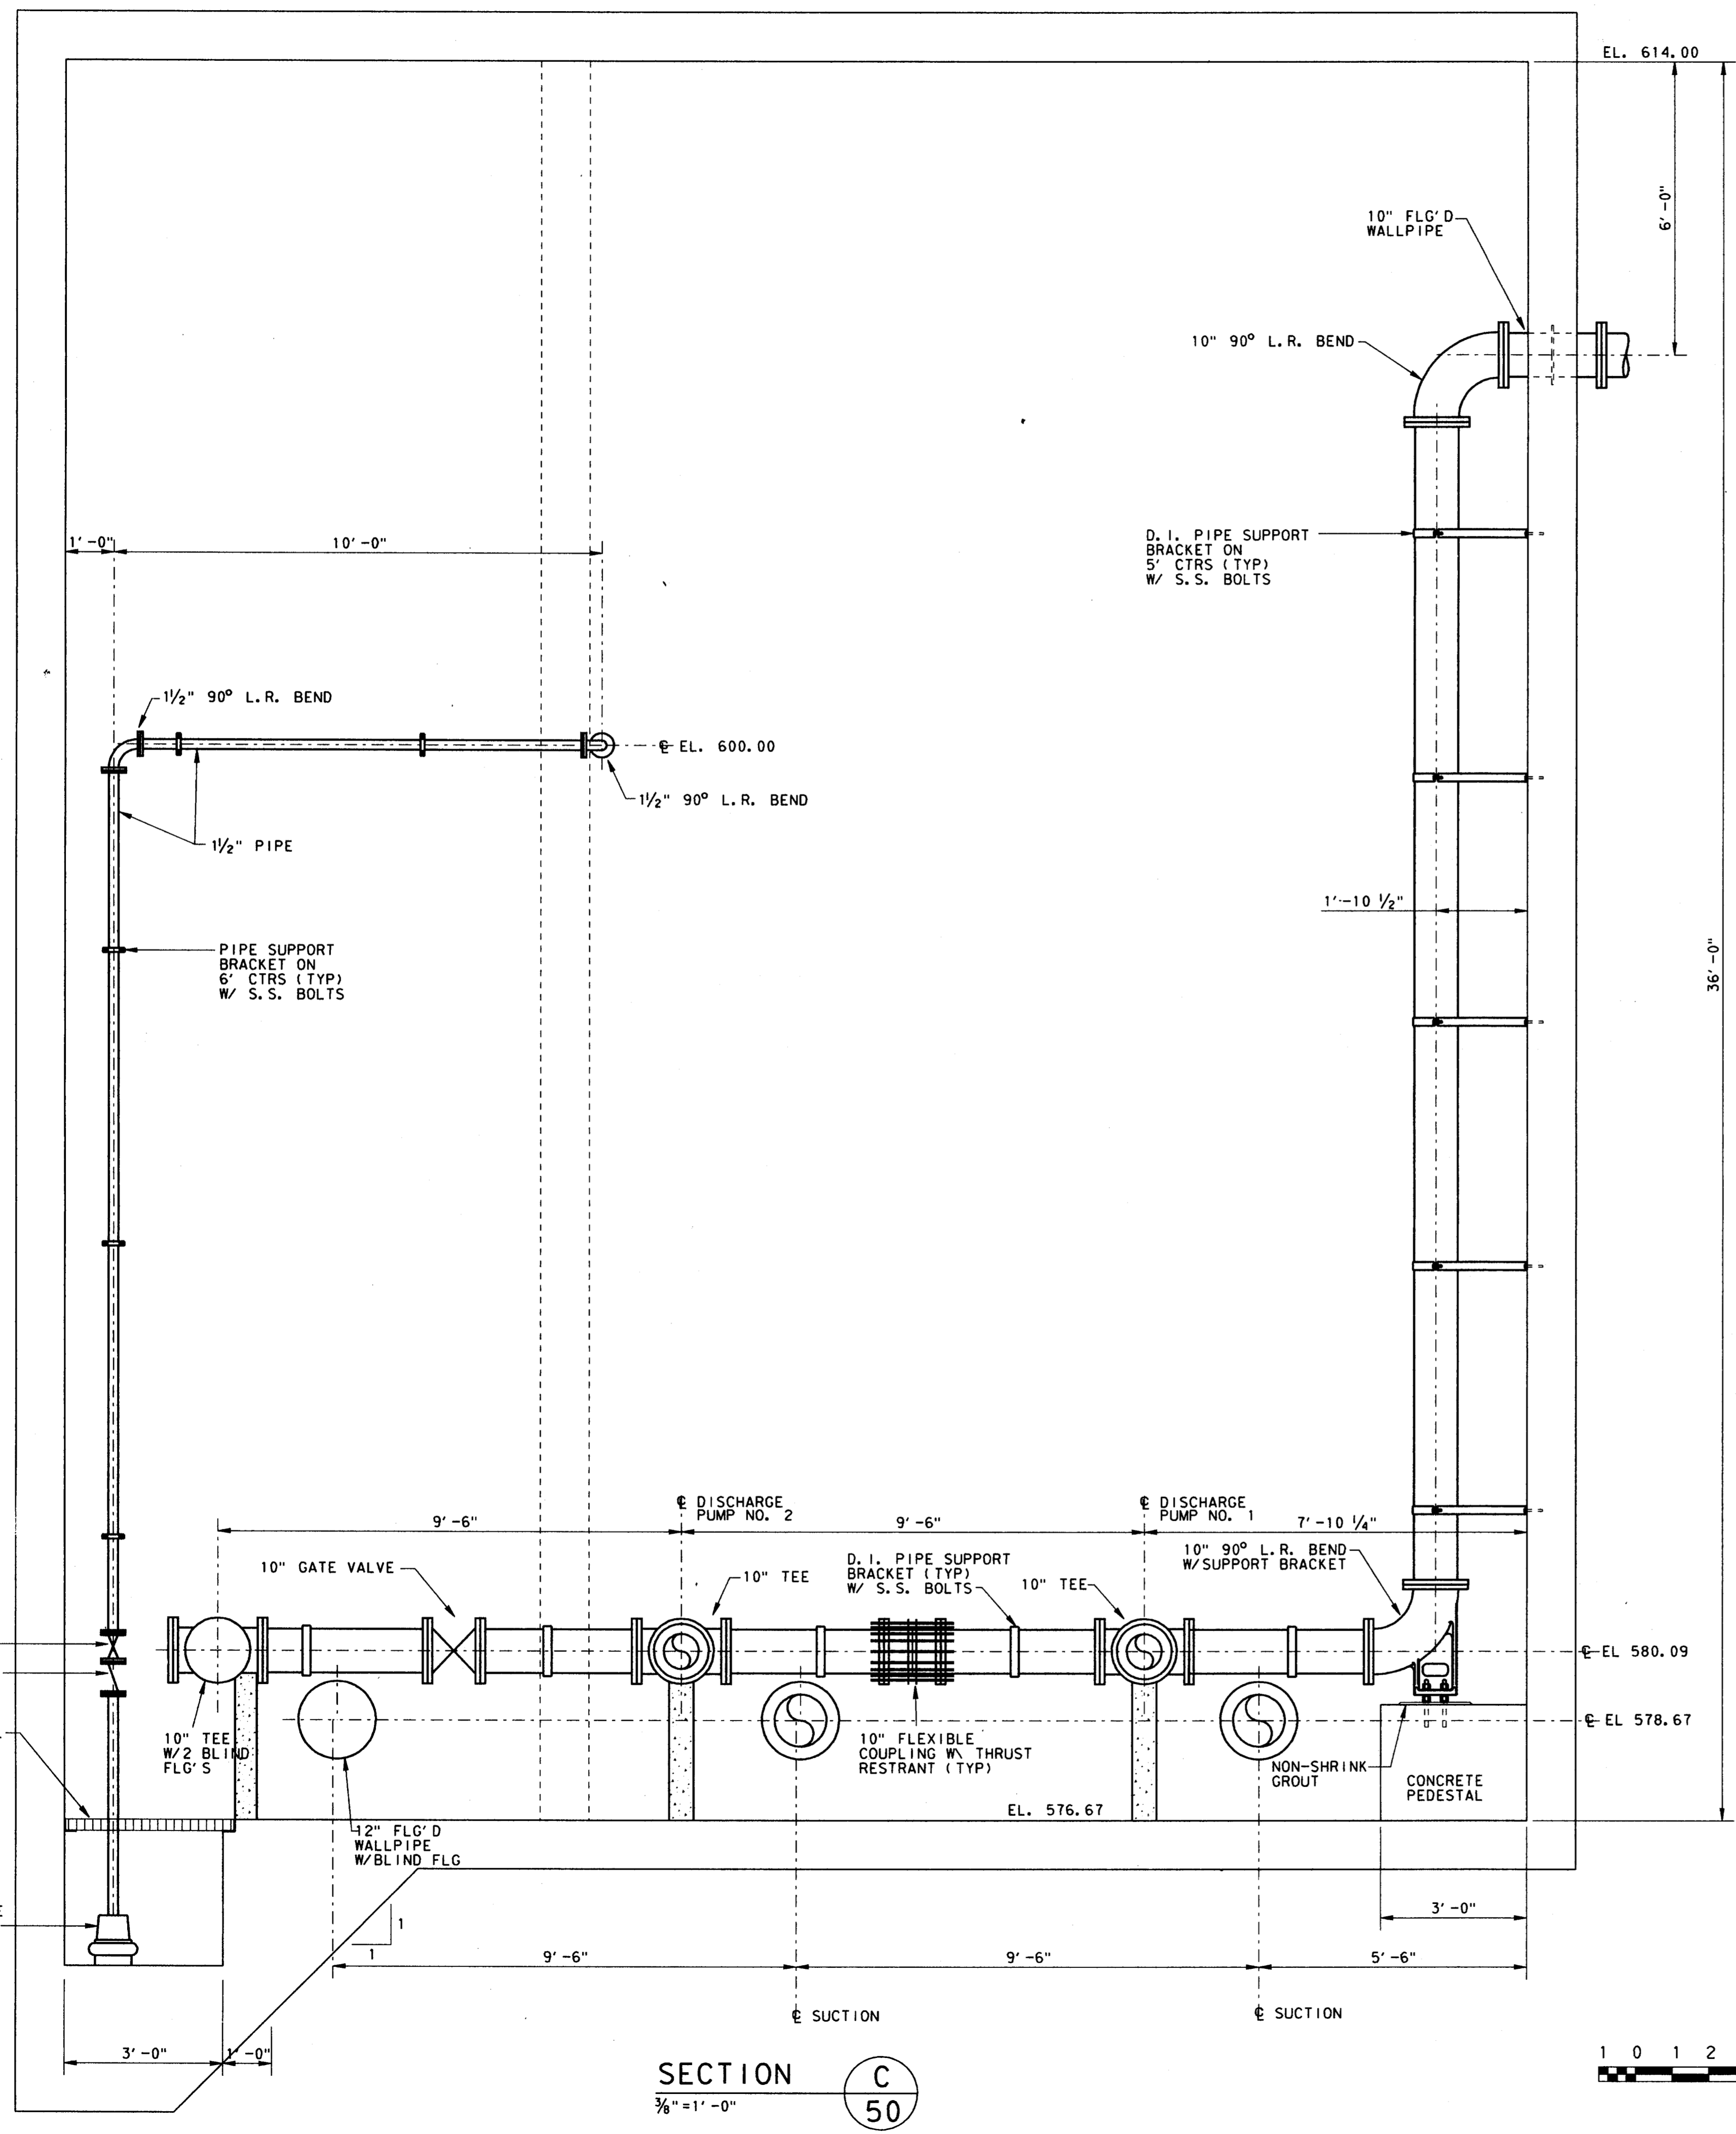

SECTION C  
3/8" = 1'-0"

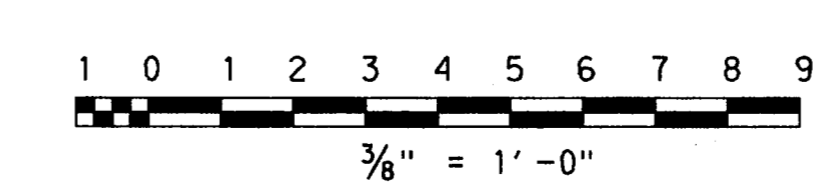

4			
3			
2			
1	9-4-98	AS BUILT DRAWING	J. H. L.
NO.	DATE	REVISION	APPROV.
TOWN OF ADDISON, TEXAS			
MIDWAY/BELTLINE SANITARY SEWER PHASE II			
LIFT STATION MECHANICAL PLAN SECTIONS			
<b>Carter &amp; Burgess</b> <small>Consultants in Engineering, Architecture, Planning and the Environment</small> CARTER & BURGESS, INC. 7950 EMBROOK DRIVE, SUITE 250 DALLAS, TX 75247-4961			
Unit	Scale	3/8" = 1'	Date 04-05-96
Designed	J. Lindner	Checked	J. Lindner Job No. 93327601D
Drawn	R. Howman	Approved	J. Lindner Sheet 51 of 63

