



- GENERAL NOTES**
1. WATER LINES SHALL BE LOCATED A MINIMUM OF 48" DEPTH EXCEPT WHERE NOTED.
 2. 6" GATE VALVES SHALL BE INSTALLED WITH ALL FIRE HYDRANTS.
 3. ALL FIRE HYDRANTS SHALL BE LOCATED 1.5 FEET INSIDE R.O.W.
 4. ALL STORM DRAIN CURB INLETS SHALL BE RECESSED AND STANDARD 10" INLETS.
 5. ALL MATERIALS AND WORKMANSHIP TO CONFORM TO CITY OF ADDISON STANDARDS.
 6. WATER MAIN TO BE AT THE FOLLOWING DEPTH BETWEEN THE LISTED STATIONS.
 - 1) 7+20 TO 7+30 6FT. TO E. AT STORM DRAIN.
 - 2) 7+40 8" CROSSING 8FT. TO E. AT STORM DRAIN.
 - 3) 7+90 8" CROSSING 8.5FT. TO E. AT STORM DRAIN.
 - 4) 35+20 TO 35+70 11FT. TO E.
 - 5) 12" CROSSING AT FACTORY 8 FT. TO E. AT STORM DRAIN.
 - 6) 12" FACTORY AT MARCEY 6 FT. TO E. AT STORM DRAIN.
 7. ALL 8" SANITARY SEWER STUBS TO BE LAID ON A 1% GRADE.

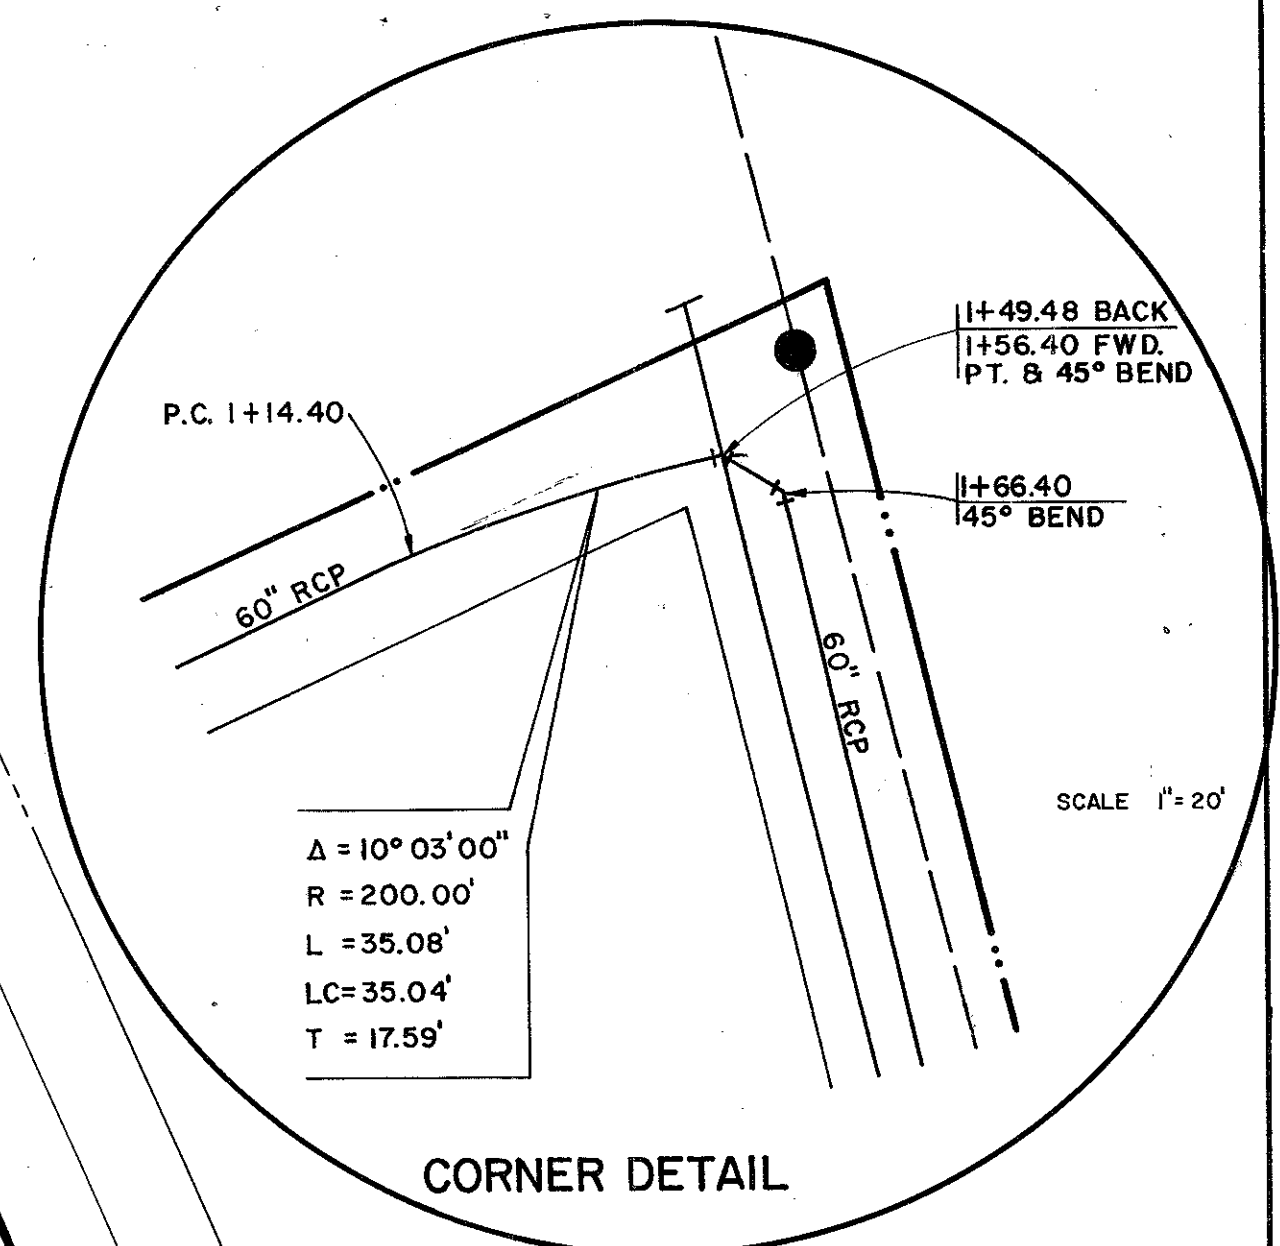

REVISED TO CONFORM TO CONSTRUCTION RECORDS:
 BY K.A.B.
 DATE 5-25-80

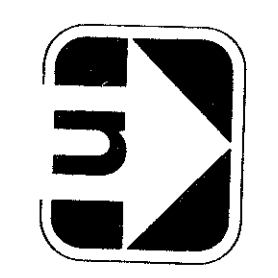

SCALE 1"=100'

REVISED TO CONFORM TO CONSTRUCTION RECORDS:
 BY _____
 DATE _____

UTILITY SITE PLAN
QUORUM NORTH
 CITY OF ADDISON, TEXAS

Graham Associates, Inc.
 CONSULTING ENGINEERS & PLANNERS

Drawn By: G. A. I. Sheet 2 of 19

Date: 9/20/79
 File: 314-1441